


ALL DIMENSIONS IN METERS EXCEPT PAY ITEMS AND UNLESS NOTED OTHERWISE

F.A.I. RTE.	SECTION	COUNTY	TOTAL SHEETS	SHEET NO.
80/94	2626.2-R-2	COOK/LAKE	1207	49
STA.	TO STA.			
FED. ROAD DIST. NO.	ILLINOIS	FED. AID PROJECT		
CONTRACT NO. 62114	INDOT DES. NO. 0100987			

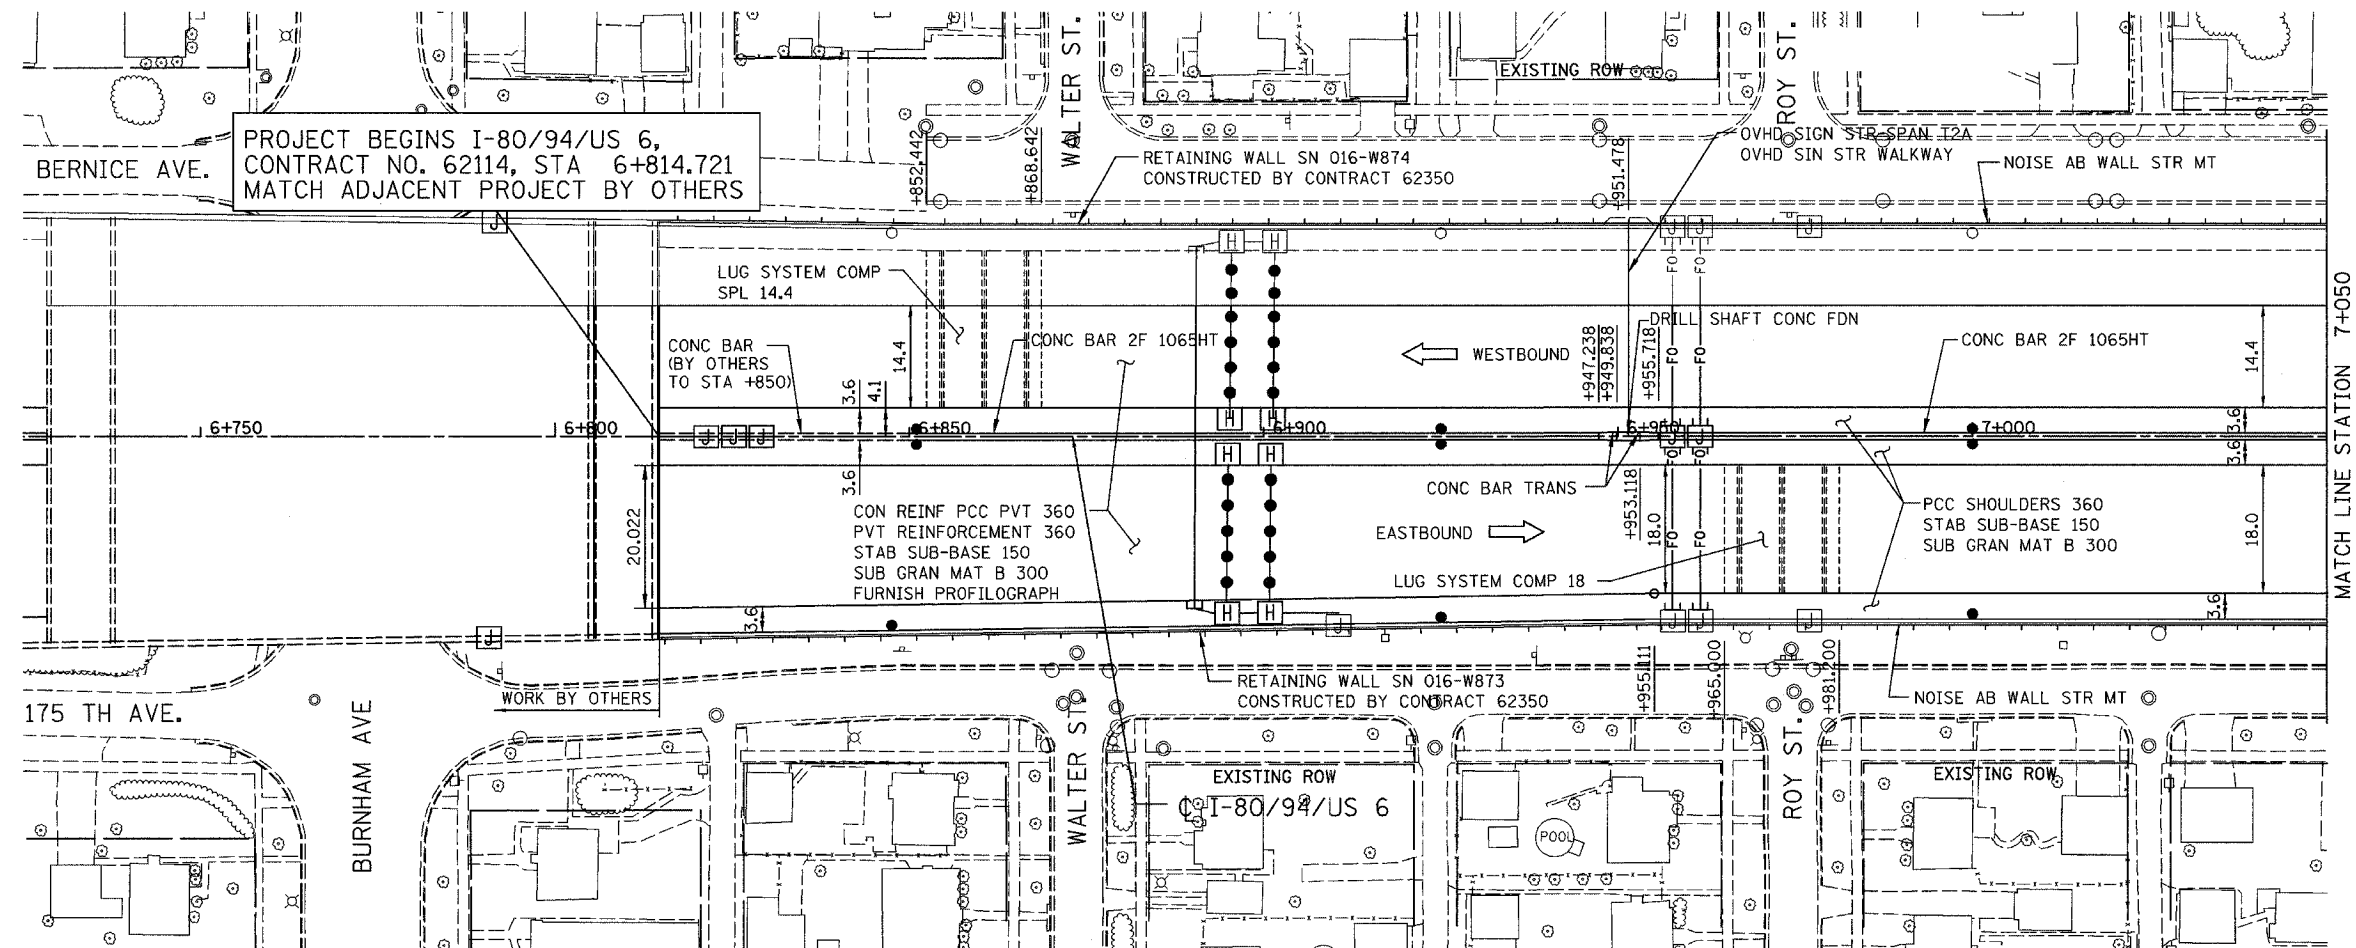


PROJECT BEGINS I-80/94/US 6,
CONTRACT NO. 62114, STA 6+814.721
MATCH ADJACENT PROJECT BY OTHERS



PROPOSED LEGEND:

- NOISE ABATEMENT (SOUND) WALL
- QC/QA PCCP 330
- SUBBASE PCCP 225 (IN)
- SUBGRD TRTMT T1A (IN)

NOTE: FOR ELECTRICAL WORK IN CONTRACT, SEE "ELECTRICAL INSTALLATION PLANS".
FOR ELECTRICAL WORK BY OTHERS, SUBJECT TO CONTRACTOR MODIFICATION,
SEE "EXISTING LIGHTING PLAN" SHEETS.

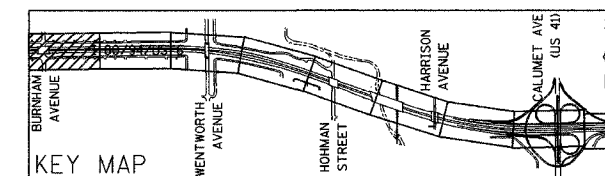

REVISIONS	
NAME	DATE

ILLINOIS DEPARTMENT OF TRANSPORTATION
I-80/94/US 6
KINGERY-BORMAN EXPRESSWAY
BURNHAM ROAD TO US 41
PROPOSED PLAN

STA. 6 + 814.721 TO STA. 7 + 050

SCALE 1:500
DATE 07/05

DRAWN BY ACE/CAD
CHECKED BY TAE