


ALL DIMENSIONS IN METERS EXCEPT PAY ITEMS AND UNLESS NOTED OTHERWISE


F.A.I. RTE.	SECTION	COUNTY	TOTAL SHEETS	SHEET NO.
80/94	2626.2-R-2	COOK/LAKE	1207	51
STA.	TO STA.			
FED. ROAD DIST. NO.	ILLINOIS FED. AID PROJECT			
CONTRACT NO. 62114	INDOT DES. NO. 0100987			

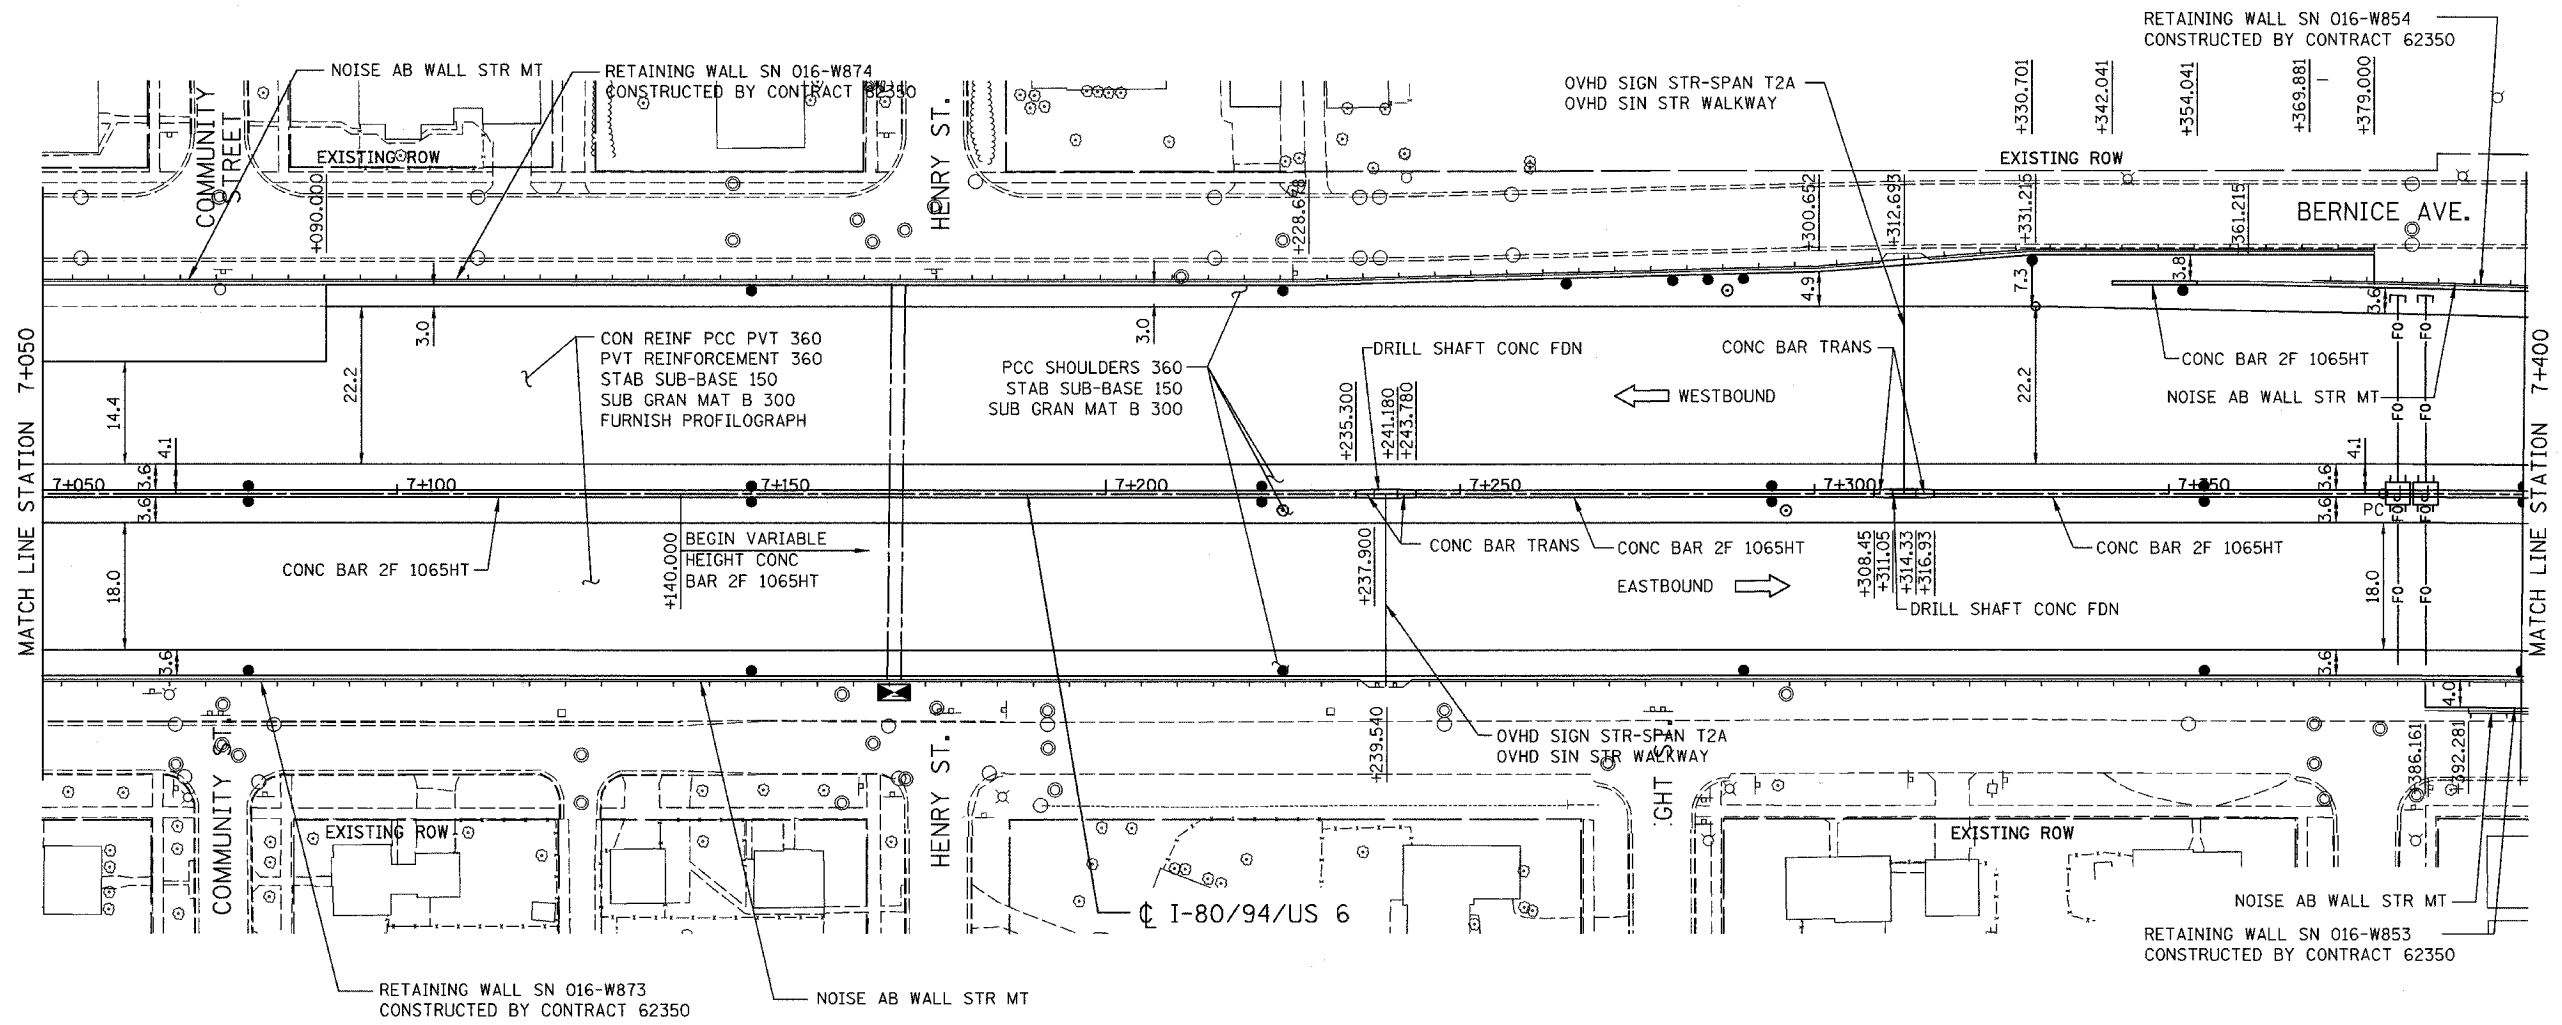

PROPOSED LEGEND:

	NOISE ABATEMENT (SOUND) WALL
	OC/OA PCCP 330
	SUBBASE PCCP 225 (IN)
	SUBGRD TRTMT T1A (IN)

NOTE: FOR ELECTRICAL WORK IN CONTRACT, SEE "ELECTRICAL INSTALLATION PLANS".
 FOR ELECTRICAL WORK BY OTHERS, SUBJECT TO CONTRACTOR MODIFICATION,
 SEE "EXISTING LIGHTING PLAN" SHEETS.

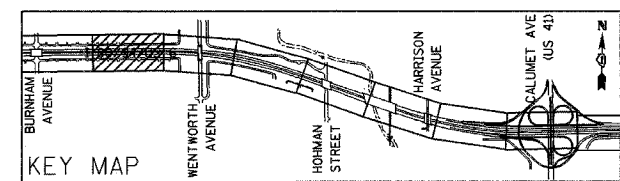

REVISIONS	
NAME	DATE

ILLINOIS DEPARTMENT OF TRANSPORTATION
 I-80/94/US 6
 KINGERY-BORMAN EXPRESSWAY
 BURNHAM ROAD TO US 41
PROPOSED PLAN

STA. 7+050 TO STA. 7+400
 SCALE 1:500 DRAWN BY ACE/CAD
 DATE 07/05 CHECKED BY TAE

AMERICAN
 CONSULTING ENGINEERS