


F.A.I. RTE.	SECTION	COUNTY	TOTAL SHEETS	SHEET NO.
80/94	2003-089I	COOK	1207	458
STA.	TO STA.			
FED. ROAD DIST. NO.	ILLINOIS	FED. AID PROJECT	CONTRACT * 62114	

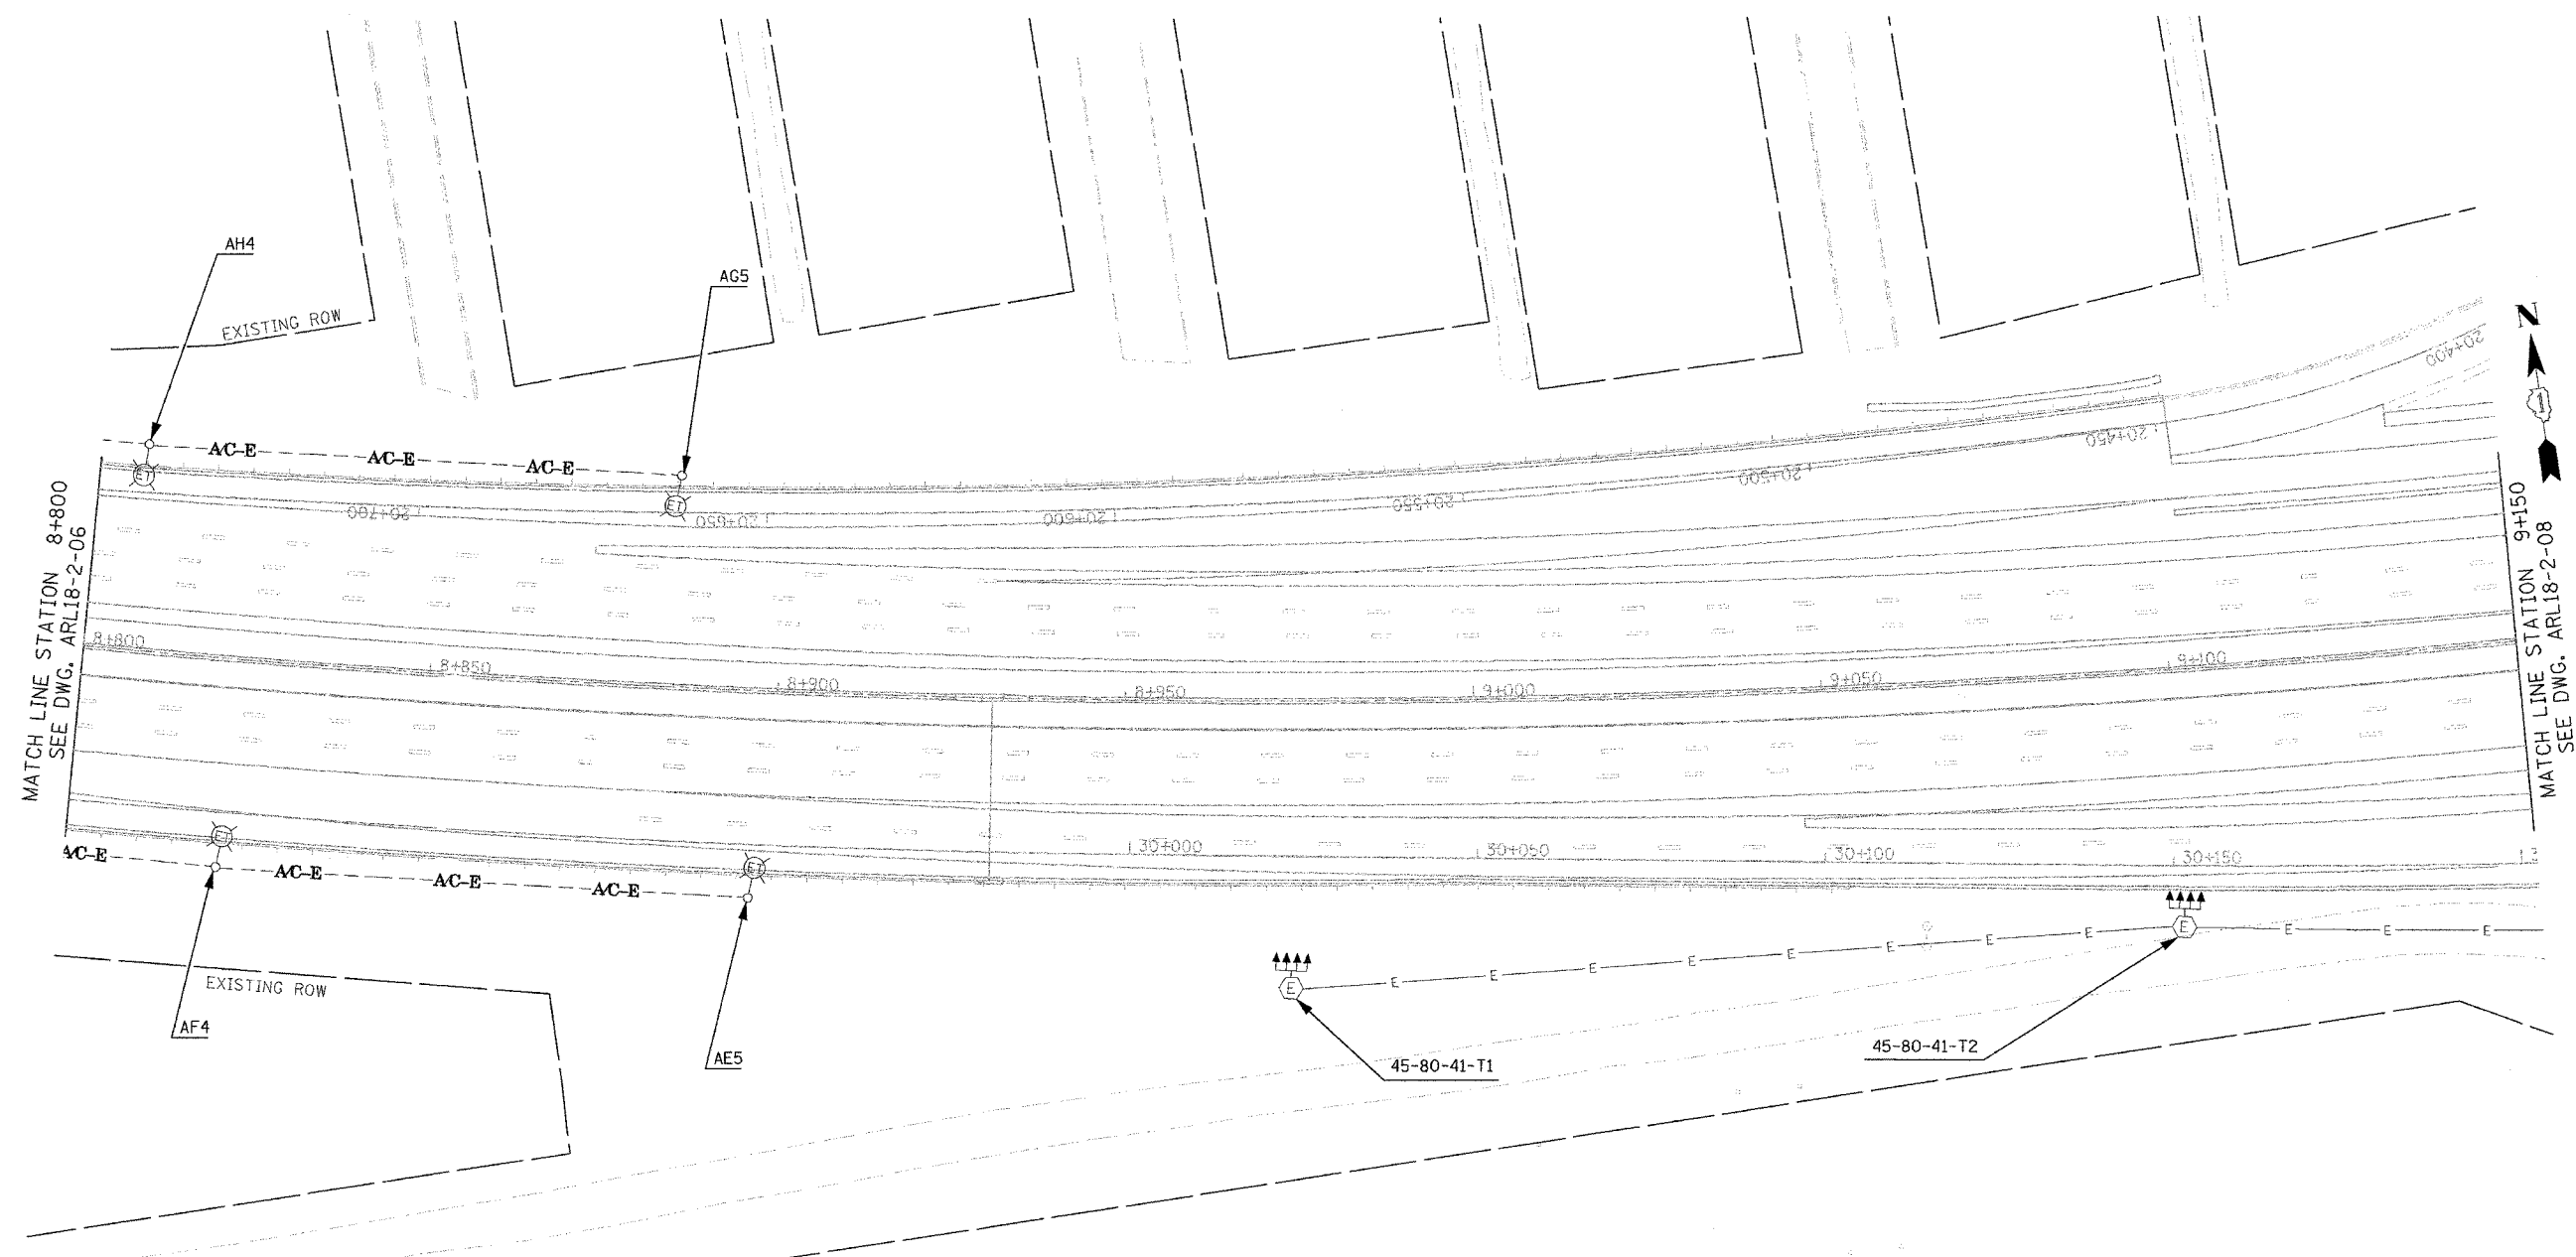


NOTE:
 INSTALLATION OF TEMPORARY LIGHT POLE UNITS, AND AERIAL CABLE ON NORTHSIDE IN INDIANA SHALL BE COORDINATED WITH CONTRACT 62664.

ARL18-2-07

ILLINOIS DEPARTMENT OF TRANSPORTATION
 I-80/94/US 6
 KINGERY-BORMAN EXPRESSWAY
 BURNHAM ROAD TO US 41
EXISTING LIGHTING PLAN
 I-80 /94 /US-6
STA. 8+800 TO STA. 9+150
 SCALE 1:500 DRAWN BY EAO/BC
 DATE 07/18/05 CHECKED BY PKG/BC

GANDHI AND ASSOCIATES, INC.
 ENGINEERS AND PLANNERS
 5000 N. BURNHAM HIGHWAY
 SUITE 200
 CHICAGO, ILLINOIS 60631 TEL: 773.3714.5900

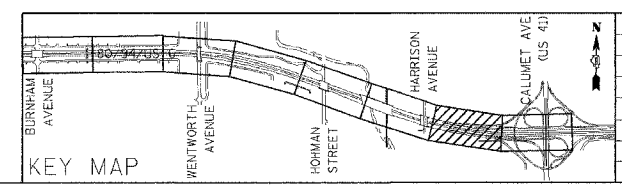

REVISIONS	
NAME	DATE

FILED
 DATE
 TIME