



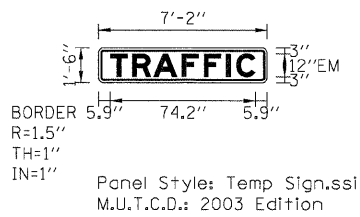


STAGE 2  
BLACK LETTERS ON ORANGE BACKGROUND  
STA 795+00

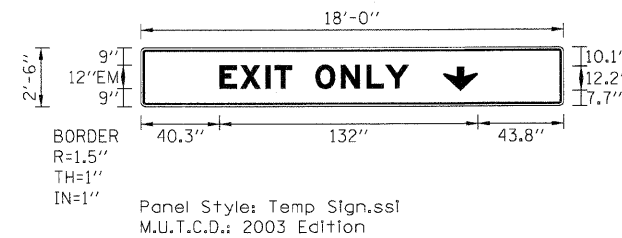


STAGE 1 AND STAGE 2  
WHITE LETTERS ON GREEN BACKGROUND  
STA 468+05  
STA 482+30




STAGE 2  
BLACK LETTERS ON ORANGE BACKGROUND  
STA 809+40  
STA 836+30

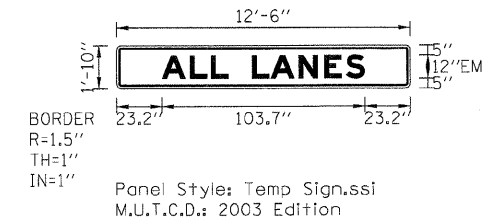


STAGE 1  
BLACK LETTERS ON ORANGE BACKGROUND  
STA 505+00  
STA 522+50  
STA 546+40

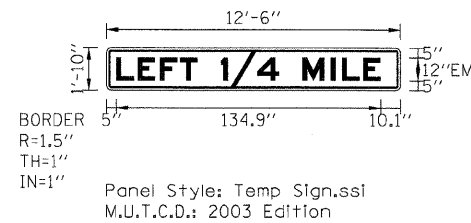


STAGE 1 AND STAGE 2  
BLACK LETTERS ON ORANGE BACKGROUND  
STA 522+50

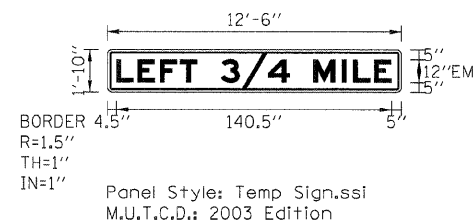


STAGE 1 AND STAGE 2  
BLACK LETTERS ON ORANGE BACKGROUND  
STA 546+40

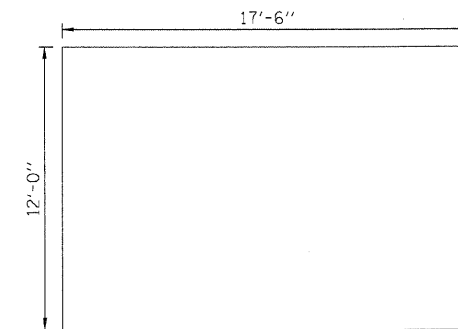

STAGE 1 AND STAGE 2  
ORANGE COVER  
STA 600+00

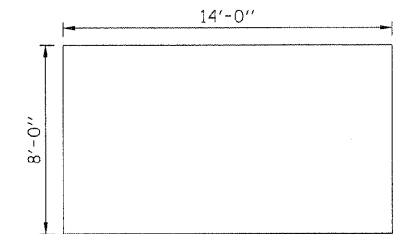


STAGE 1 AND STAGE 2  
ORANGE COVER  
STA 590+80

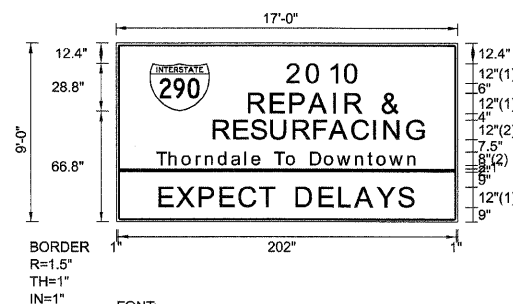


FONT:  
(1) ClearviewHwy-5-W  
(2) ClearviewHwy-5-W-R


Panel Style: Temp Sign.ssi  
M.U.T.C.D.: 2003 Edition

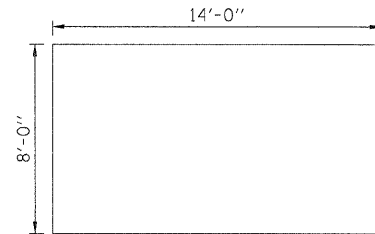

STAGE 1 AND STAGE 2  
ORANGE COVER  
STA 482+30

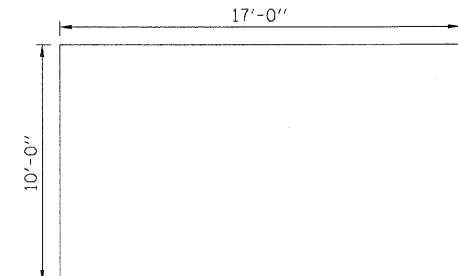

 STAGE 1 AND STAGE 2  
ORANGE COVER  
STA 468+05  
STA 482+30



STAGE 1  
YELLOW COVER  
STA 496+20

PLACE PROJECT TEMPORARY INFORMATION SIGN PRIOR TO STAGE 1 AT THE FOLLOWING LOCATIONS AS DIRECTED BY THE ENGINEER:

EASTBOUND I-88 NEAR YORK RD



STAGE 1  
GREEN COVER  
STA 505+00  
STAGE 2  
STA 505+00  
STA 522+50



BORDER  
R=1.5"  
TH=1"  
IN=1"

STAGE 2  
WHITE ARROW ON GREEN BACKGROUND  
STA 522+50

Panel Style: Temp Sign.ssi  
M.U.T.C.D.: 2003 Edition



BORDER  
R=1.5"  
TH=1"  
IN=1"

STAGE 1  
BLACK ARROW ON ORANGE BACKGROUND  
STA 505+00 (TWO PANELS)

Panel Style: Temp Sign.ssi  
M.U.T.C.D.: 2003 Edition

FILE NAME =	DESIGNED - AJP	REVISED -
...prp\in_ABC_C2_TempSignDetails_01.dgn	DRAWN - TMB	REVISED -
USER NAME = tblank	CHECKED - JJT	REVISED -
PLOT DATE = 12/16/2009	DATE - 10/16/09	REVISED -

**benesch**

**STATE OF ILLINOIS  
DEPARTMENT OF TRANSPORTATION**

**MAINTENANCE OF TRAFFIC  
TEMPORARY INFORMATION SIGNING**

SCALE: N.T.S. SHEET NO. 96 OF 96 SHEETS STA. TO STA.

F.A.I. RTE.	SECTION	COUNTY	TOTAL SHEETS	SHEET NO.
290	(3031.1, ETC., 3838)RS-5	COOK	298	190
CONTRACT NO. 60G52			FED. ROAD DIST. NO. ILLINOIS/FED. AID PROJECT	