


SIGN DETAIL
1:75

EB-TR-52
STA. 550+10

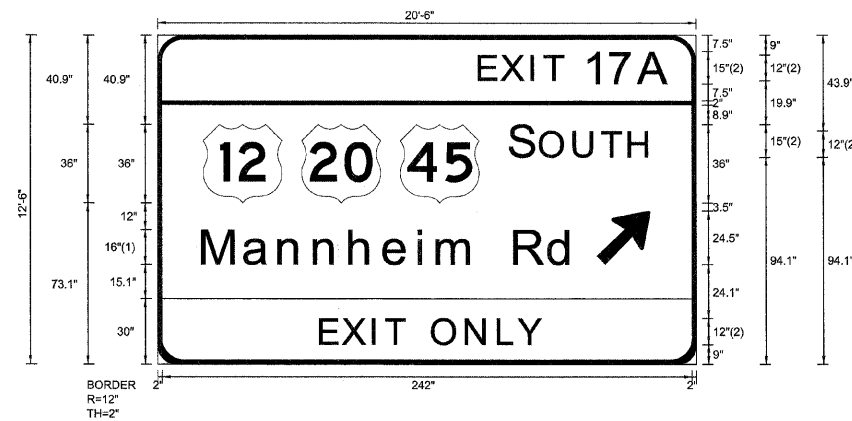

SIGN NUMBER	name	
WIDTH x HGHT.	20'-6" x 12'-6"	
BORDER WIDTH	2"	
CORNER RADIUS	12"	
MOUNTING	Overhead	
BACKGROUND	TYPE:	Reflective
	COLOR:	Green
LEGEND/BORDER	TYPE:	Reflective
	COLOR:	White,Black/White

Panel Style: sign_default.ssi
Dimensions are in inches.tenths

FONT:
(1) ClearviewHwy-5-W-R
(2) ClearviewHwy-5-W

Letter locations are panel edge to lower left corner

SYMBOL	ROT	X	Y	WID	HT
M1_4	0	20.9	73.1	36	36
M1_4	0	65.9	73.1	36	36
M1_4	0	110.9	73.1	36	36
ARMED	45	200.6	45.1	20	31.5

LETTER POSITIONS (X)

															LENGTH	SERIES/SIZE	
E	X	I	T	1	7	A											ClearviewHwy-5-W
147.3	157.6	171.2	177.1	195.8	207	220.4											87.1 12,15
S	O	U	T	H													ClearviewHwy-5-W
161.4	175.2	190.7	203.5	215.8													63.5 15,12
M	a	n	n	h	e	i	m		R	d							ClearviewHwy-5-W-R
20.9	39.8	55.8	72	88.1	103.7	119.5	128	146.1	163.3	179							169.7 16/13
E	X	I	T		O	N	L	Y									ClearviewHwy-5-W
74.7	85	98.6	104.6	113.2	125.9	141.3	155.9	165.2									101 12

FILE NAME =	DESIGNED - SEW	REVISED -
#FILE#	DRAWN - SEW	REVISED -
USER NAME = #USER#	CHECKED - FML	REVISED -
PLOT DATE = #DATE#	DATE - 12/2009	REVISED -



STATE OF ILLINOIS
DEPARTMENT OF TRANSPORTATION

SIGNING DETAILS

SCALE: N.T.S. SHEET NO. 5 OF 77 SHEETS STA. TO STA.

F.A.I. RTE.	SECTION	COUNTY	TOTAL SHEETS	SHEET NO.
290	(3031.1, ETC., 3838)RS-5	COOK	413	333
FED. ROAD DIST. NO.			ILLINOIS FED. AID PROJECT	
			CONTRACT NO. 60652	