


SIGN DETAIL  
1:75

EB-BM-55  
STA. 563+50

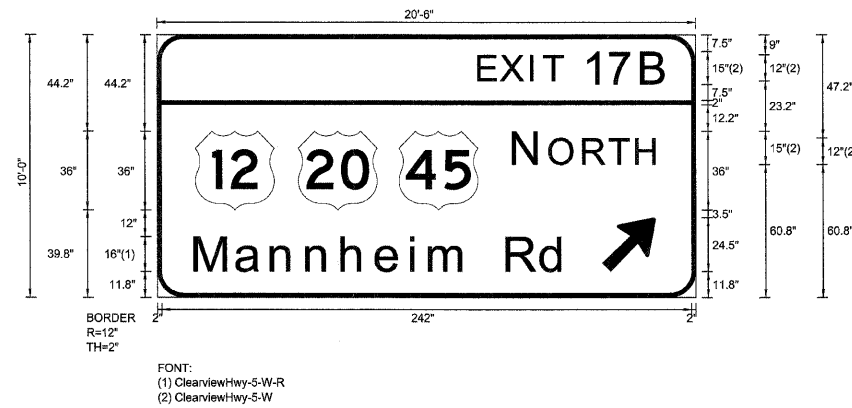

Panel Style: sign\_default.ssi  
Dimensions are in inches.tenths

Letter locations are panel edge to lower left corner

SIGN NUMBER	name
WIDTH x HIGHT.	20'-6" x 10'-0"
BORDER WIDTH	2"
CORNER RADIUS	12"
MOUNTING	Overhead
BACKGROUND	TYPE: Reflective
	COLOR: Green
LEGEND/BORDER	TYPE: Reflective
	COLOR: WhiteWhite

SYMBOL	ROT	X	Y	WID	HT
M1_4	0	17.5	39.8	36	36
M1_4	0	64.5	39.8	36	36
M1_4	0	110.5	39.8	36	36
ARMED	45	203.2	11.8	20	31.5

LETTER POSITIONS (X)

											LENGTH	SERIESSIZE
E	X	I	T	1	7	B						ClearviewHwy-5-W
147.3	157.6	171.2	177.1	195.8	207	222					86.1	12,15
N	O	R	T	H								ClearviewHwy-5-W
163.4	179.8	195.2	207.1	219.3							65.1	15,12
M	a	n	n	h	e	i	m	R	d			ClearviewHwy-5-W-R
17.5	36.4	52.4	68.6	84.7	100.2	116.1	124.6	142.7	159.9	175.6	169.7	16,13

FILE NAME =	DESIGNED - SEW	REVISED -
\$FILEL*	DRAWN - SEW	REVISED -
USER NAME = #USER#	CHECKED - FML	REVISED -
PLOT DATE = #DATE#	DATE - 12/2009	REVISED -



STATE OF ILLINOIS  
DEPARTMENT OF TRANSPORTATION

SIGNING DETAILS

SCALE: N.T.S. SHEET NO. 8 OF 77 SHEETS STA. TO STA.

F.A.I. RTE.	SECTION	COUNTY	TOTAL SHEETS	SHEET NO.
290	(3031.1, ETC., 3838RS-5	COOK	413	336
FED. ROAD DIST. NO.			ILLINOIS FED. AID PROJECT	
			CONTRACT NO. 60G52	