


SIGN DETAIL
1:75

WB-TR-67
STA. 541+20

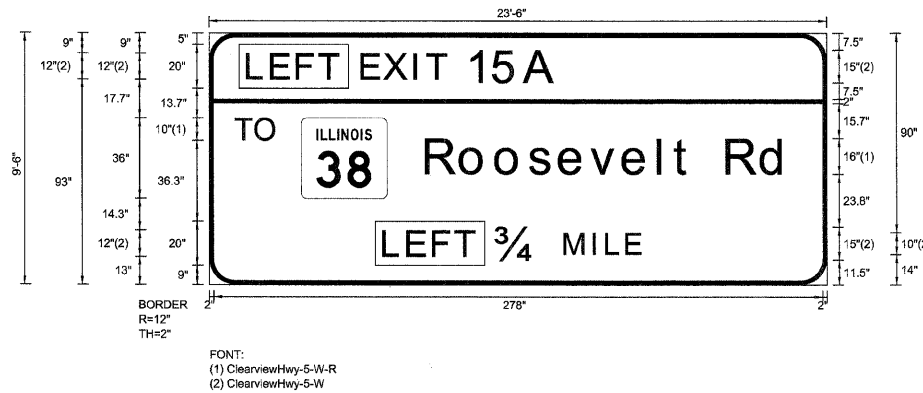

Panel Style: sign_default.ssi
Dimensions are in inches.tenths

Letter locations are panel edge to lower left corner

SIGN NUMBER	name
WIDTH x HGHT.	23'-6" x 9'-6"
BORDER WIDTH	2"
CORNER RADIUS	12"
MOUNTING	Overhead
BACKGROUND	TYPE: Reflective COLOR: Green
LEGEND/BORDER	TYPE: Reflective COLOR: WhiteWhite

SYMBOL	ROT	X	Y	WID	HT
M1-I100A-2-22-10D	10D	42	39.3	39.3	36

LETTER POSITIONS (X)

LETTER POSITIONS (X)											LENGTH	SERIESSIZE	
L	E	F	T								41.2	ClearviewHwy-5-W 12	
18	28.8	40.5	50.6										
E	X	I	T	1	5	A					88.6	ClearviewHwy-5-W 12,15	
70.1	80.4	94.1	100	118.6	130.6	144.7							
T	O										18.5	ClearviewHwy-5-W-R 10	
12	21.2												
R	o	o	s	e	v	e	l	t	R	d	164.7	ClearviewHwy-5-W-R 16/13	
99.4	115.1	131.2	146.6	160.3	174.6	189.3	205.5	212.8	220.6	236.7	252.4		
L	E	F	T								41.2	ClearviewHwy-5-W 12	
80.1	91	102.7	112.7										
3/4	M	I	L	E							65.7	ClearviewHwy-5-W 15,10	
131.4	162.6	175.7	181.7	190.7									

FILE NAME =	DESIGNED - SEW	REVISED -
#FILE#	DRAWN - SEW	REVISED -
USER NAME = #USER#	CHECKED - FML	REVISED -
PLOT DATE = #DATE#	DATE - 12/2009	REVISED -



STATE OF ILLINOIS
DEPARTMENT OF TRANSPORTATION

SIGNING DETAILS

SCALE: N.T.S. SHEET NO. 42 OF 77 SHEETS STA. TO STA.

F.A.I. RTE.	SECTION	COUNTY	TOTAL SHEETS	SHEET NO.
290	(3031.1, ETC., 3838)RS-5	COOK	413	370
FED. ROAD DIST. NO.		ILLINOIS FED. AID PROJECT		
		CONTRACT NO. 60G52		