


SIGN DETAIL

1:75

WB-BM-99  
STA. 809+40

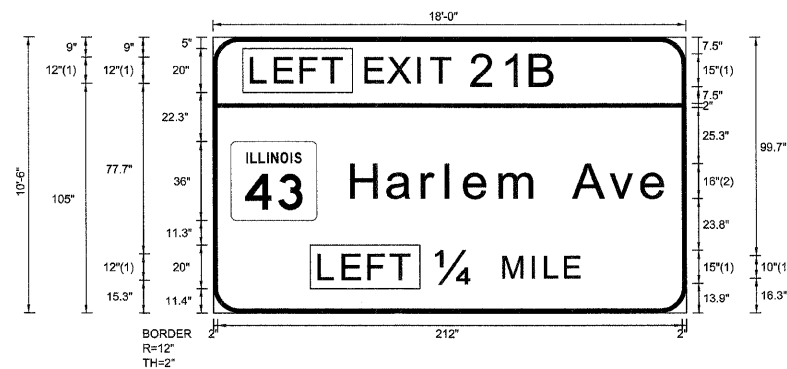

SIGN NUMBER	name
WIDTH x HGT.	18'-0" x 10'-6"
BORDER WIDTH	2"
CORNER RADIUS	12"
MOUNTING	Overhead
BACKGROUND	TYPE: Reflective COLOR: Green
LEGEND/BORDER	TYPE: Reflective COLOR: White/White

SYMBOL	ROT	X	Y	WID	HT
M1-H00A-2-22-10D	0	8.1	42.7	39.3	36

Panel Style: sign\_default.ssi  
Dimensions are in inches.tenths

Letter locations are panel edge to lower left corner

FONT:  
(1) ClearviewHwy-5-W  
(2) ClearviewHwy-5-W-R

LETTER POSITIONS (X)

													LENGTH	SERIESSIZE			
L	E	F	T														ClearviewHwy-5-W
18	28.8	40.5	50.6													41.2	12
E	X	I	T	2	1	B											ClearviewHwy-5-W
70.1	80.4	94.1	100	118.6	132.8	145.5										86.8	12,15
H	a	r	i	e	m		A	v	e								ClearviewHwy-5-W-R
63.4	79.9	95.9	106.9	115.1	131.3	149.4	164.9	181.4	196.1							144.5	16/13
L	E	F	T														ClearviewHwy-5-W
48.7	59.5	71.2	81.3													41.2	12
14	M	I	L	E													ClearviewHwy-5-W
101.9	132.9	146	152	161												65.5	15,10

FILE NAME =	DESIGNED - SEW	REVISED -
\$FILEL\$	DRAWN - SEW	REVISED -
USER NAME = \$USER\$	CHECKED - FML	REVISED -
PLOT DATE = \$DATE\$	DATE - 12/2009	REVISED -



STATE OF ILLINOIS  
DEPARTMENT OF TRANSPORTATION

SIGNING DETAILS

SCALE: N.T.S. SHEET NO. 67 OF 77 SHEETS STA. TO STA.

F.A.I. RTE.	SECTION	COUNTY	TOTAL SHEETS	SHEET NO.
290	(3031.1, ETC., 3838)RS-5	COOK	413	395
FED. ROAD DIST. NO.	ILLINOIS FED. AID PROJECT	CONTRACT NO. 60G52		