


SIGN DETAIL
1:75

EB-BM-98
STA. 942+80

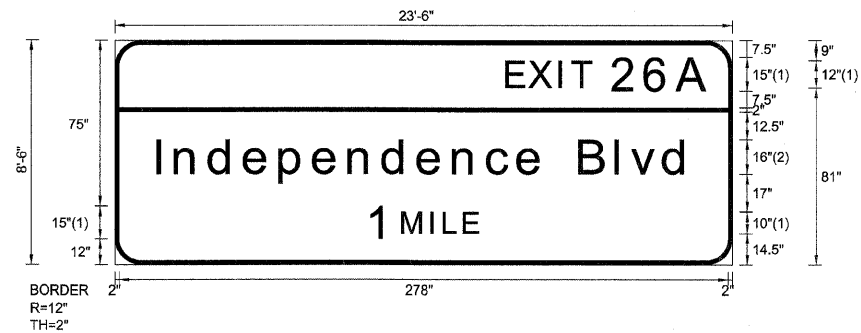

FONT:
(1) ClearviewHwy-5-W
(2) ClearviewHwy-5-W-R

Panel Style: sign_default.ssi
Dimensions are in inches.tenths

Letter locations are panel edge to lower left corner

SIGN NUMBER	name
WIDTH x HGHT.	23'-6" x 8'-6"
BORDER WIDTH	2"
CORNER RADIUS	12"
MOUNTING	Overhead
BACKGROUND	TYPE: Reflective
	COLOR: Green
LEGEND/BORDER	TYPE: Reflective
	COLOR: White/White

SYMBOL	ROT	X	Y	WID	HT

LETTER POSITIONS (X)

																				LENGTH	SERIESIZE
E	X	I	T	2	6	A														92	12,15
179.4	189.7	203.3	209.3	227.9	243	257.4														243	1613
I	n	d	e	p	e	n	d	e	n	c	e		B	I	v	d					
19.5	27.9	43.4	59.4	75.6	91	107.2	122.8	138.8	155	170.5	184.4	196.1	212.7	229.3	236.2	250.9					
1	M	I	L	E																50.2	15,10
115.9	131.7	144.8	150.7	159.8																	

FILE NAME =	DESIGNED - SEW	REVISED -
FILEL	DRAWN - SEW	REVISED -
USER NAME = *USER*	CHECKED - SEW	REVISED -
PLOT DATE = *DATE*	DATE - 12/2009	REVISED -



STATE OF ILLINOIS
DEPARTMENT OF TRANSPORTATION

SIGNING DETAILS			
SCALE: N.T.S.	SHEET NO. 4 OF 79 SHEETS	STA.	TO STA.

F.A.I. RTE.	SECTION	COUNTY	TOTAL SHEETS	SHEET NO.
290	(2828B,D, ETC., 3031)RS-6	COOK	300	217
FED. ROAD DIST. NO.			ILLINOIS FED. AID PROJECT	
			CONTRACT NO. 60G53	