


SIGN DETAIL
1:75

EB-BM-104
STA. 1037+40

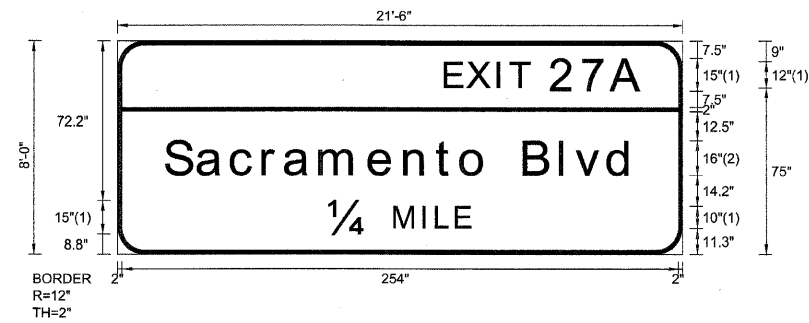

FONT:
(1) ClearviewHwy-5-W
(2) ClearviewHwy-5-W-R

Panel Style: sign_default.ssi
Dimensions are in inches.tenths

Letter locations are panel edge to lower left corner

SIGN NUMBER	name
WIDTH x HGHT.	21'-6" x 8'-0"
BORDER WIDTH	2"
CORNER RADIUS	12"
MOUNTING	Overhead
BACKGROUND	TYPE: Reflective
	COLOR: Green
LEGEND/BORDER	TYPE: Reflective
	COLOR: White/White

SYMBOL	ROT	X	Y	WID	HT

LETTER POSITIONS (X)

		LENGTH	SERIESIZE
E	X		ClearviewHwy-5-W
149.9	160.2	90.1	12,15
I	T		ClearviewHwy-5-W-R
173.9	179.8	213.8	1613
S	a		ClearviewHwy-5-W
22.1	36.9	64.5	15,10
52.2	66.7		
76.7	92.7		
115.2	131.4		
146	157.2		
169.5	186.1		
202.6	209.6		
224.3			
1/4	M		
96.8	126.8		
139.9	145.9		
154.9			

FILE NAME =	DESIGNED - SEW	REVISED -
#FILEL*	DRAWN - SEW	REVISED -
USER NAME = #USER*	CHECKED - SEW	REVISED -
PLOT DATE = #DATE*	DATE - 12/2009	REVISED -



STATE OF ILLINOIS
DEPARTMENT OF TRANSPORTATION

SIGNING DETAILS

SCALE: N.T.S. SHEET NO. 8 OF 79 SHEETS STA. TO STA.

F.A.I. RTE.	SECTION	COUNTY	TOTAL SHEETS	SHEET NO.
290	(2828B,D, ETC., 3031.1)RS-6	COOK	300	221
FED. ROAD DIST. NO.		ILLINOIS FED. AID PROJECT		CONTRACT NO. 60G53