


SIGN DETAIL

1:75

EB-BM-105
STA. 1050+70

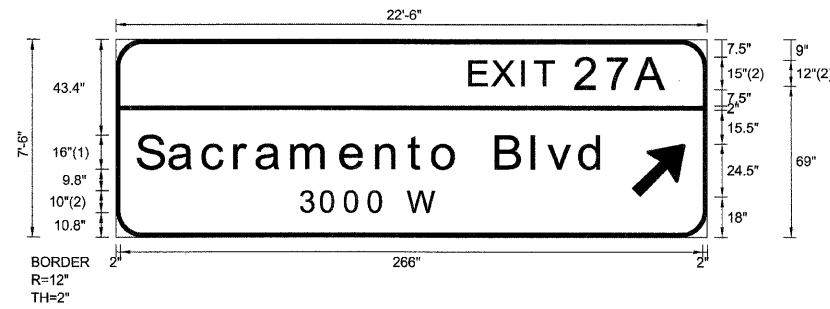

BORDER
R=12"
TH=2"

FONT:
(1) ClearviewHwy-5-W-R
(2) ClearviewHwy-5-W

SIGN NUMBER	name
WIDTH x HGHT.	22'-6" x 7'-6"
BORDER WIDTH	2"
CORNER RADIUS	12"
MOUNTING	Overhead
BACKGROUND	TYPE: Reflective COLOR: Green
LEGEND/BORDER	TYPE: Reflective COLOR: White/White

SYMBOL	ROT	X	Y	WID	HT
ARMED	45	235.5	18	20	31.5

Panel Style: sign_default.ssi
Dimensions are in inches.tenths

Letter locations are panel edge to lower left corner

LETTER POSITIONS (X)														LENGTH	SERIESSIZE		
E	X	I	T	2	7	A										ClearviewHwy-5-W	
161.9	172.2	185.9	191.8	210.4	224.6	238										90.1	12,15
S	a	c	r	a	m	e	n	t	o		B	l	v	d			ClearviewHwy-5-W-R
10	24.7	40.1	54.5	64.6	80.5	103.1	119.3	133.8	145	157.3	173.9	190.5	197.5	212.2		213.8	1613
3	0	0	0		W												ClearviewHwy-5-W-R
84.3	93.9	104.8	115.7	123.8	133.4											62.3	10

FILE NAME =	DESIGNED - SEW	REVISED -
FILEL	DRAWN - SEW	REVISED -
USER NAME = *LSER*	CHECKED - SEW	REVISED -
PLOT DATE = *DATE*	DATE - 12/2009	REVISED -



STATE OF ILLINOIS
DEPARTMENT OF TRANSPORTATION

SIGNING DETAILS		
SCALE: N.T.S.	SHEET NO. 10 OF 79 SHEETS	STA. TO STA.

F.A.I. RTE.	SECTION	COUNTY	TOTAL SHEETS	SHEET NO.
290	(2828B,D, ETC., 3031.1)RS-6	COOK	300	223
FED. ROAD DIST. NO. [ILLINOIS] FED. AID PROJECT			CONTRACT NO. 60G53	