


SIGN DETAIL
1:75

EB-BM-123
STA. 1151+20

SIGN NUMBER	name
WIDTH x HGT.	15'-6" x 8'-0"
BORDER WIDTH	2"
CORNER RADIUS	12"
MOUNTING	Overhead
BACKGROUND	TYPE: Reflective COLOR: Green
LEGEND/BORDER	TYPE: Reflective COLOR: White/White

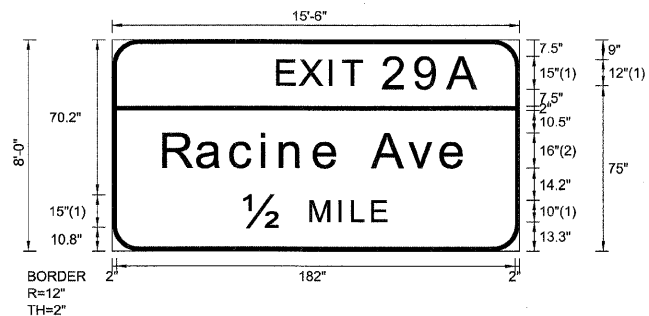

Panel Style: sign_default.ssi
Dimensions are in inches.tenths

Letter locations are panel edge to lower left corner

SYMBOL	ROT	X	Y	WID	HT

LETTER POSITIONS (X)

							LENGTH			SERIESIZE		
E	X	I	T	2	9	A						
75.9	86.2	99.9	105.8	124.4	139.3	154					92.1	12,15
R	a	c	i	n	e		A	v	e			
23.8	39.2	54.5	68.7	77.1	92.7	104.4	119.2	135.8	150.5		138.5	1613
1/2	M	I	L	E								
60.6	90.9	104.1	110	119							64.8	15,10

FILE NAME -	DESIGNED - SEW	REVISED -
FILEL	DRAWN - SEW	REVISED -
USER NAME = #USER#	CHECKED - SEW	REVISED -
PLOT DATE = #DATE#	DATE - 12/2009	REVISED -



STATE OF ILLINOIS
DEPARTMENT OF TRANSPORTATION

SIGNING DETAILS

SCALE: N.T.S. SHEET NO. 23 OF 79 SHEETS STA. TO STA.

F.A.I. RTE.	SECTION	COUNTY	TOTAL SHEETS	SHEET NO.
290 (2828B,D, ETC., 3031.1)RS-6		COOK	300	236
FED. ROAD DIST. NO. ILLINOIS FED. AID PROJECT			CONTRACT NO. 60653	