


SIGN DETAIL
1:75

EB-BM-130
STA. 1204+80

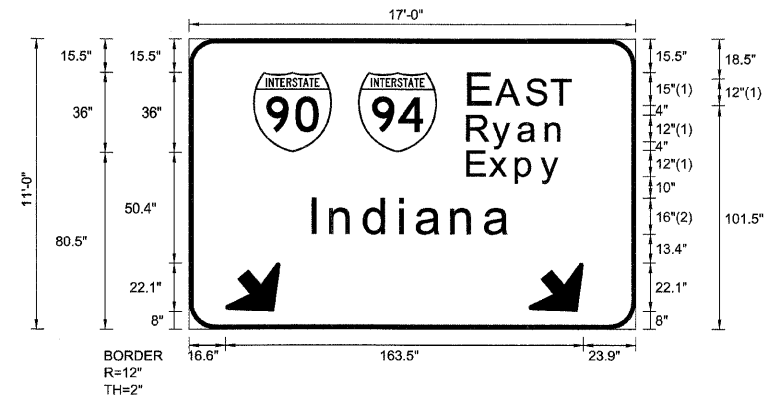

| | |
|---------------|--------------------|
| SIGN NUMBER | name |
| WIDTH x HGHT. | 17'-0" x 11'-0" |
| BORDER WIDTH | 2" |
| CORNER RADIUS | 12" |
| MOUNTING | Overhead |
| BACKGROUND | TYPE: Reflective |
| | COLOR: Green |
| LEGEND/BORDER | TYPE: Reflective |
| | COLOR: White/White |

| SYMBOL | ROT | X | Y | WID | HT |
|--------|-----|-------|------|-----|----|
| M1_1 | 0 | 29.3 | 80.5 | 36 | 36 |
| M1_1 | 0 | 77.3 | 80.5 | 36 | 36 |
| ARDOWN | 40 | 16.6 | 8 | 32 | 22 |
| ARDOWN | 40 | 155.2 | 8 | 32 | 22 |

Panel Style: sign_default.ssi
Dimensions are in inches.tenths

FONT:
(1) ClearviewHwy-5-W
(2) ClearviewHwy-5-W-R

Letter locations are panel edge to lower left corner

LETTER POSITIONS (X)

| | | | | | | | LENGTH | SERIESSIZE |
|-------|-------|-------|-------|-------|-------|-------|--------|--------------------|
| E | A | S | T | | | | | ClearviewHwy-5-W |
| 128.3 | 141 | 154.7 | 166.1 | | | | 46.5 | 15,12 |
| R | y | a | n | | | | | ClearviewHwy-5-W |
| 127.7 | 139.2 | 151 | 163.7 | | | | 44.3 | 129.8 |
| E | x | p | y | | | | | ClearviewHwy-5-W |
| 127.7 | 137.7 | 149.9 | 161.2 | | | | 42.9 | 129.8 |
| I | n | d | i | a | n | a | | ClearviewHwy-5-W-R |
| 56.6 | 65 | 80.5 | 96.9 | 104.4 | 120.4 | 135.6 | 90.8 | 1613 |

| | | |
|--------------------|----------------|-----------|
| FILE NAME = | DESIGNED - SEW | REVISED - |
| *FILEL* | DRAWN - SEW | REVISED - |
| USER NAME = *USER* | CHECKED - SEW | REVISED - |
| PLOT DATE = *DATE* | DATE - 12/2009 | REVISED - |



STATE OF ILLINOIS
DEPARTMENT OF TRANSPORTATION

SIGNING DETAILS

SCALE: N.T.S. SHEET NO. 29 OF 79 SHEETS STA. TO STA.

| | | | | |
|---|----------------------------|--------|--------------------|-----------|
| F.A.I. RTE. | SECTION | COUNTY | TOTAL SHEETS | SHEET NO. |
| 290 | (2828B,D, ETC., 3031)DRS-6 | COOK | 300 | 242 |
| FED. ROAD DIST. NO. [ILLINOIS] FED. AID PROJECT | | | CONTRACT NO. 60653 | |