


SIGN DETAIL
1:75

EB-TR-132
STA. 1208+20

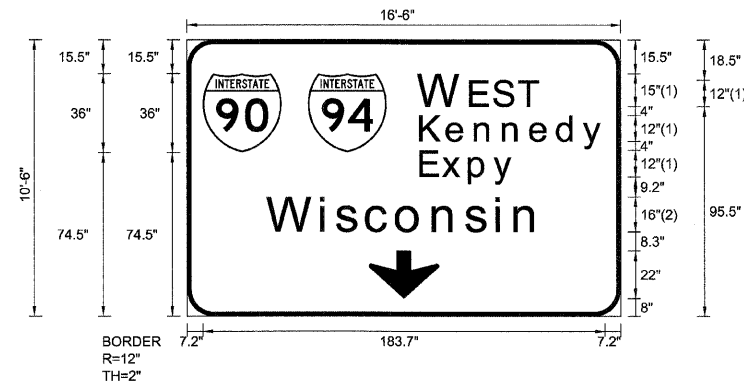

BORDER
R=12"
TH=2"

FONT:
(1) ClearviewHwy-5-W
(2) ClearviewHwy-5-W-R

Panel Style: sign_default.ssi
Dimensions are in inches.tenths

Letter locations are panel edge to lower left corner

SIGN NUMBER	name
WIDTH x HGHT.	16'-6" x 10'-6"
BORDER WIDTH	2"
CORNER RADIUS	12"
MOUNTING	Overhead
BACKGROUND	TYPE: Reflective COLOR: Green
LEGEND/BORDER	TYPE: Reflective COLOR: White/White

SYMBOL	ROT	X	Y	WID	HT
M1_1	0	7.2	74.5	36	36
M1_1	0	55.2	74.5	36	36
ARDOWN	0	83	8	32	22

LETTER POSITIONS (X)

										LENGTH	SERIESIZE
W	E	S	T								ClearviewHwy-5-W
106.2	129.9	140.6	152							54.5	15,12
K	e	n	n	e	d	y					ClearviewHwy-5-W
107.1	119.2	132.1	144.9	157.3	169.7	181.5				83.8	129.8
E	x	p	y								ClearviewHwy-5-W
107.1	117.1	129.3	140.6							42.9	129.8
W	i	s	c	o	n	s	i	n			ClearviewHwy-5-W-R
36.9	61.4	68.5	82.2	96	112.8	127.5	141.5	150		124.1	1613

FILE NAME -	DESIGNED - SEW	REVISED -
FILEL	DRAWN - SEW	REVISED -
USER NAME - *USER*	CHECKED - SEW	REVISED -
PLDT DATE - *DATE*	DATE - 12/2009	REVISED -



STATE OF ILLINOIS
DEPARTMENT OF TRANSPORTATION

SIGNING DETAILS

SCALE: N.T.S. SHEET NO. 31 OF 79 SHEETS STA. TO STA.

F.A.I. RTE.	SECTION	COUNTY	TOTAL SHEETS	SHEET NO.
290	(2828B,D, ETC., 3031.1)RS-6	COOK	300	244
CONTRACT NO. 60653				
FED. ROAD DIST. NO. [ILLINOIS] FED. AID PROJECT				