


SIGN DETAIL

1:75

EB-TR-133  
STA. 1208+20

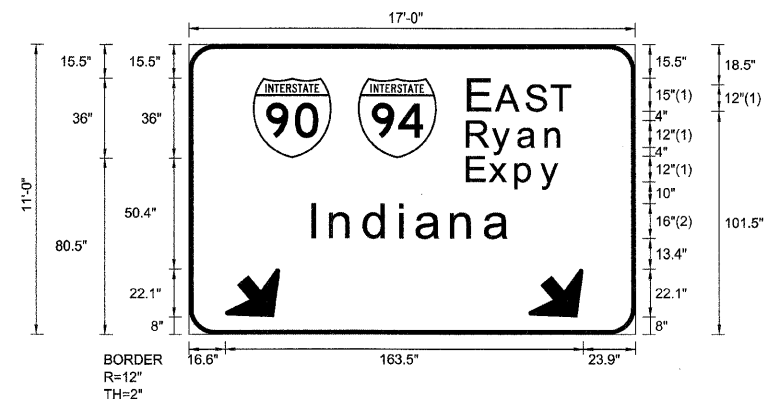

BORDER  
R=12"  
TH=2"

FONT:  
(1) ClearviewHwy-5-W  
(2) ClearviewHwy-5-W-R

Panel Style: sign\_default.ssi  
Dimensions are in inches.tenths

Letter locations are panel edge to lower left corner

SIGN NUMBER	name
WIDTH x HGHT.	17'-0" x 11'-0"
BORDER WIDTH	2"
CORNER RADIUS	12"
MOUNTING	Overhead
BACKGROUND	TYPE: Reflective COLOR: Green
LEGEND/BORDER	TYPE: Reflective COLOR: WhiteWhite

SYMBOL	ROT	X	Y	WID	HT
M1_1	0	29.3	80.5	36	36
M1_1	0	77.3	80.5	36	36
ARDOWN	40	16.6	8	32	22
ARDOWN	40	155.2	8	32	22

LETTER POSITIONS (X)

							LENGTH	SERIESIZE
E	A	S	T				128.3	ClearviewHwy-5-W
							46.5	15,12
R	y	a	n				127.7	ClearviewHwy-5-W
							44.3	129.8
E	x	p	y				127.7	ClearviewHwy-5-W
							42.9	129.8
I	n	d	i	a	n	a	56.6	ClearviewHwy-5-W-R
							90.8	1613

FILE NAME =	DESIGNED - SEW	REVISED -
\$FILEL\$	DRAWN - SEW	REVISED -
USER NAME = \$USER\$	CHECKED - SEW	REVISED -
PLOT DATE = \$DATE\$	DATE - 12/2009	REVISED -



STATE OF ILLINOIS  
DEPARTMENT OF TRANSPORTATION

SIGNING DETAILS

SCALE: N.T.S. SHEET NO. 32 OF 79 SHEETS STA. TO STA.

F.A.I. RTE.	SECTION	COUNTY	TOTAL SHEETS	SHEET NO.
290	(2828B,D, ETC., 3031,1)RS-6	COOK	300	245
FED. ROAD DIST. NO.			ILLINOIS FED. AID PROJECT	
			CONTRACT NO. 60653	