


SIGN DETAIL  
1:75

EB-TR-134  
STA. 1210+50

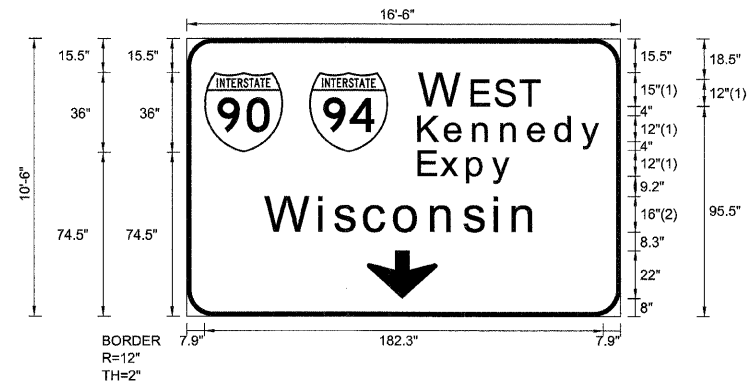

BORDER  
R=12"  
TH=2"

FONT:  
(1) ClearviewHwy-5-W  
(2) ClearviewHwy-5-W-R

Panel Style: sign\_default.ssi  
Dimensions are in inches.tenths

Letter locations are panel edge to lower left corner

SIGN NUMBER	name
WIDTH x HGHT.	16'-6" x 10'-6"
BORDER WIDTH	2"
CORNER RADIUS	12"
MOUNTING	Overhead
BACKGROUND	TYPE: Reflective COLOR: Green
LEGEND/BORDER	TYPE: Reflective COLOR: White/White

SYMBOL	ROT	X	Y	WID	HT
M1_1	0	7.9	74.5	36	36
M1_1	0	55.9	74.5	36	36
ARDOWN	0	82.3	8	32	22

LETTER POSITIONS (X)

										LENGTH	SERIESSIZE
W	E	S	T								ClearviewHwy-5-W
106.9	130.6	141.3	152.7							54.5	15.12
K	e	n	n	e	d	y					ClearviewHwy-5-W
106.3	118.5	131.4	144.2	156.6	169	180.8				83.8	129.8
E	x	p	y								ClearviewHwy-5-W
106.3	116.4	128.6	139.9							42.9	129.8
W	i	s	c	o	n	s	i	n			ClearviewHwy-5-W-R
36.2	60.7	67.7	81.4	95.3	112.1	126.8	140.8	149.3		124.1	16/13

FILE NAME =	DESIGNED - SEW	REVISED -
*FILEL*	DRAWN - SEW	REVISED -
USER NAME = *USER*	CHECKED - SEW	REVISED -
PLOT DATE = *DATE*	DATE - 12/2009	REVISED -



STATE OF ILLINOIS  
DEPARTMENT OF TRANSPORTATION

SIGNING DETAILS

SCALE: N.T.S. SHEET NO. 33 OF 79 SHEETS STA. TO STA.

F.A.I. RTE.	SECTION	COUNTY	TOTAL SHEETS	SHEET NO.
290	(2828B,D, ETC., 3031,1)RS-6	COOK	300	246
FED. ROAD DIST. NO.		ILLINOIS FED. AID PROJECT	CONTRACT NO. 60G53	