


SIGN DETAIL

1:75

EB-TR-135
STA. 1210+50

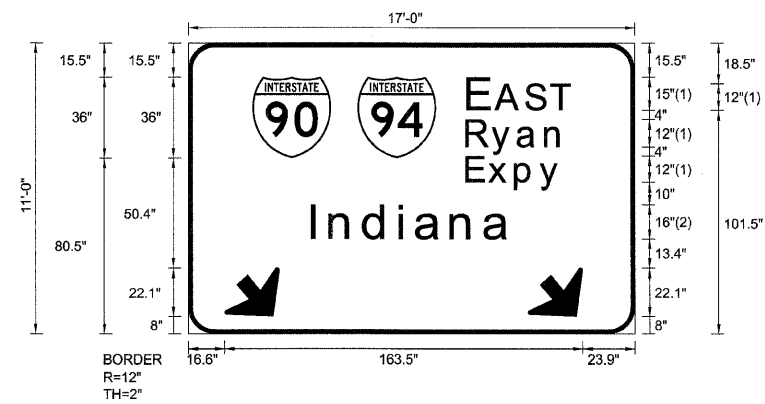

BORDER
R=12"
TH=2"

FONT:
(1) ClearviewHwy-5-W
(2) ClearviewHwy-5-W-R

Panel Style: sign_default.ssi
Dimensions are in inches.tenths

Letter locations are paneledge to lower left corner

SIGN NUMBER	name
WIDTH x HGHT.	17'-0" x 11'-0"
BORDER WIDTH	2"
CORNER RADIUS	12"
MOUNTING	Overhead
BACKGROUND	TYPE: Reflective
	COLOR: Green
LEGEND/BORDER	TYPE: Reflective
	COLOR: WhiteWhite

SYMBOL	ROT	X	Y	WID	HT
M1_1	0	29.3	80.5	36	36
M1_1	0	77.3	80.5	36	36
ARDOWN	40	16.6	8	32	22
ARDOWN	40	155.2	8	32	22

LETTER POSITIONS (X)

							LENGTH	SERIESSIZE
E	A	S	T				46.5	ClearviewHwy-5-W 15,12
128.3	141	154.7	166.1					
R	y	a	n				44.3	ClearviewHwy-5-W 129.8
127.7	139.2	151	163.7					
E	x	p	y				42.9	ClearviewHwy-5-W 129.8
127.7	137.7	149.9	161.2					
I	n	d	i	a	n	a	90.8	ClearviewHwy-5-W-R 1613
56.6	65	80.5	96.9	104.4	120.4	135.6		

FILE NAME =	DESIGNED - SEW	REVISED -
FILEL	DRAWN - SEW	REVISED -
USER NAME = *USER*	CHECKED - SEW	REVISED -
PLOT DATE = *DATE*	DATE - 12/2009	REVISED -



STATE OF ILLINOIS
DEPARTMENT OF TRANSPORTATION

SIGNING DETAILS

SCALE: N.T.S. SHEET NO. 34 OF 79 SHEETS STA. TO STA.

F.A.I. RTE.	SECTION	COUNTY	TOTAL SHEETS	SHEET NO.
290	(2828B,D, ETC., 3031,1RS-6	COOK	300	247
FED. ROAD DIST. NO. [ILLINOIS] FED. AID PROJECT			CONTRACT NO. 60653	