


SIGN DETAIL
1:75

WB-TR-104
STA. 895+10

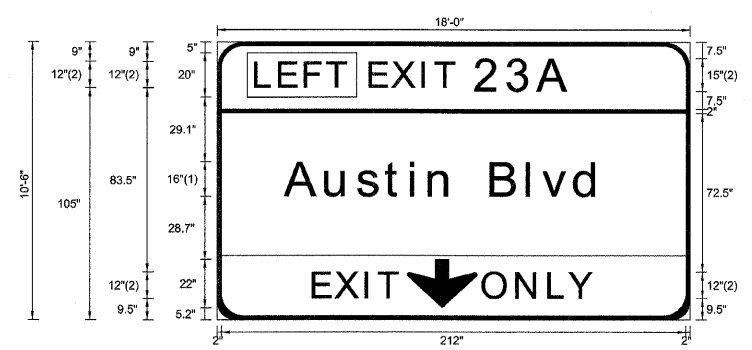

FONT:
(1) ClearviewHwy-5-W-R
(2) ClearviewHwy-5-W

Panel Style: sign_default.ssi
Dimensions are in inches, tenths

Letter locations are panel edge to lower left corner

SIGN NUMBER	name
WIDTH x HGHT.	18'-0" x 10'-6"
BORDER WIDTH	2"
CORNER RADIUS	12"
MOUNTING	Overhead
BACKGROUND	TYPE: Reflective
	COLOR: Green
LEGEND/BORDER	TYPE: Reflective
	COLOR: White,Black&White

SYMBOL	ROT	X	Y	WID	HT
ARROWDOWN	0	86.8	5.2	32	22

LETTER POSITIONS (X)

												LENGTH	SERIESIZE
L	E	F	T									41.2	ClearviewHwy-5-W 12
18	28.8	40.5	50.6									91	ClearviewHwy-5-W 12,15
E	X	I	T	2	3	A						143.9	ClearviewHwy-5-W-R 1613
70.1	80.4	94.1	100	118.6	133	147.1						38.5	ClearviewHwy-5-W 12
A	u	s	t	i	n	B	l	v	d			49.8	ClearviewHwy-5-W 12
31.4	49.9	64.4	77.2	88.7	97.1	108.2	125.4	142	149	163.7			
E	X	I	T										
44.3	54.5	68.2	74.1										
O	N	L	Y										
121.9	137.3	151.9	161.2										

FILE NAME =	DESIGNED - SEW	REVISED -
\$FILEL\$	DRAWN - SEW	REVISED -
USER NAME = \$USER\$	CHECKED - SEW	REVISED -
PLOT DATE = \$DATE\$	DATE - 12/2009	REVISED -



STATE OF ILLINOIS
DEPARTMENT OF TRANSPORTATION

SIGNING DETAILS

SCALE: N.T.S. SHEET NO. 37 OF 79 SHEETS STA. TO STA.

F.A.I. RTE.	SECTION	COUNTY	TOTAL SHEETS	SHEET NO.
290	(28285,D, ETC., 3031.1)RS-6	COOK	300	250
FED. ROAD DIST. NO.		ILLINOIS FED. AID PROJECT		
		CONTRACT NO. 60G53		