


SIGN DETAIL

1:75

WB-BM-117
STA. 1013+75

SIGN NUMBER	name
WIDTH x HGHT.	16'-6" x 8'-6"
BORDER WIDTH	2"
CORNER RADIUS	12"
MOUNTING	Overhead
BACKGROUND	TYPE: Reflective COLOR: Green
LEGEND/BORDER	TYPE: Reflective COLOR: White/White

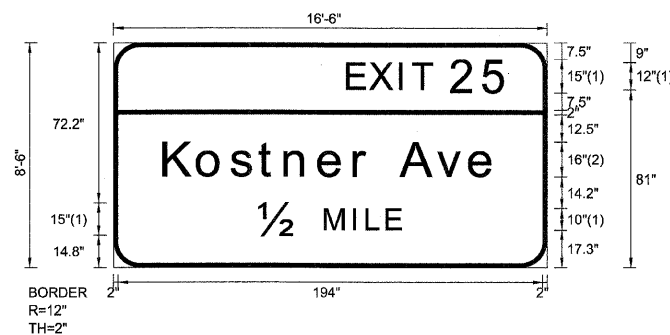

FONT:
(1) ClearviewHwy-5-W
(2) ClearviewHwy-5-W-R

Panel Style: sign_default.ssi
Dimensions are in inches, tenths

Letter locations are panel edge to lower left corner

SYMBOL	ROT	X	Y	WID	HT

LETTER POSITIONS (X)

														LENGTH	SERIES SIZE
E	X	I	T	2	5									72.7	ClearviewHwy-5-W 12,15
107.3	117.6	131.2	137.2	154.8	169.7										
K	o	s	t	n	e	r		A	v	e				151.3	ClearviewHwy-5-W-R 16,13
23.4	38.6	54	66.7	78.6	94.1	110.3	117.6	131.6	148.2	162.9					
12	M	I	L	E										64.8	ClearviewHwy-5-W 15,10
66.6	97	110.1	116	125.1											

FILE NAME =	DESIGNED - SEW	REVISED -
#FILEL#	DRAWN - SEW	REVISED -
USER NAME = #USER#	CHECKED - SEW	REVISED -
PLOT DATE = #DATE#	DATE - 12/2009	REVISED -



STATE OF ILLINOIS
DEPARTMENT OF TRANSPORTATION

SIGNING DETAILS

F.A.I. RTE.	SECTION	COUNTY	TOTAL SHEETS	SHEET NO.
290	(282BB,D, ETC., 3031.1)RS-6	COOK	300	260
FED. ROAD DIST. NO.				ILLINOIS FED. AID PROJECT

SCALE: N.T.S. SHEET NO. 47 OF 79 SHEETS STA. TO STA.

CONTRACT NO. 60C53