


SIGN DETAIL
1:75

WB-BM-125
STA. 1078+70

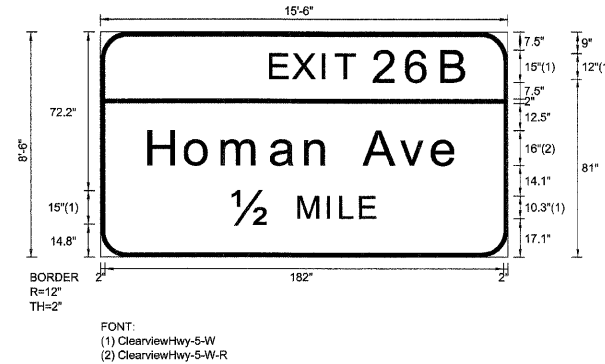

SIGN NUMBER	name
WIDTH x HGHT.	15'-6" x 8'-6"
BORDER WIDTH	2"
CORNER RADIUS	12"
MOUNTING	Overhead
BACKGROUND	TYPE: Reflective
	COLOR: Green
LEGEND/BORDER	TYPE: Reflective
	COLOR: WhiteWhite

Panel Style: sign_default.ssi
Dimensions are in inches.tenths

Letter locations are panel edge to lower left corner

SYMBOL	ROT	X	Y	WID	HT

LETTER POSITIONS (X)

																					LENGTH	SERIESSIZE	
E	X	I	T	2	6	B																	
78	88.3	101.9	107.9	125.5	140.6	156.6															90	12,15	
H	o	m	a	n		A	v	e															
22.3	39.2	56	78.2	94.1	105.2	120.6	137.2	151.9													141.3	1613	
12	M	I	L	E																			
60.6	90.9	104.1	109.9	118.9																	64.9	15,10.3	

FILE NAME =	DESIGNED - SEW	REVISED -
FILEL	DRAWN - SEW	REVISED -
USER NAME = *USER*	CHECKED - SEW	REVISED -
PLOT DATE = *DATE*	DATE - 12/2009	REVISED -



STATE OF ILLINOIS
DEPARTMENT OF TRANSPORTATION

SIGNING DETAILS

SCALE: N.T.S.	SHEET NO. 53 OF 79 SHEETS	STA. _____ TO STA. _____
---------------	---------------------------	--------------------------

F.A.I. RTE.	SECTION	COUNTY	TOTAL SHEETS	SHEET NO.
290	(2828B,D, ETC., 3031.1)RS-6	COOK	300	266
FED. ROAD DIST. NO. _____			ILLINOIS FED. AID PROJECT	
CONTRACT NO. 60G53				