


SIGN DETAIL
1:75

WB-BM-132
STA. 1118+70

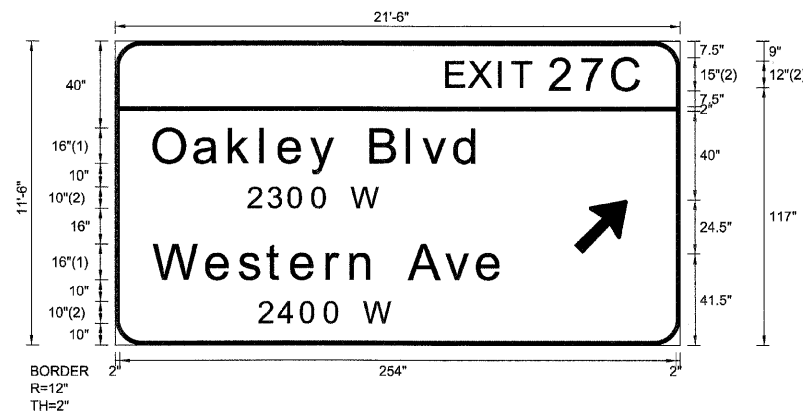

SIGN NUMBER	name
WIDTH x HGHT.	21'-6" x 11'-6"
BORDER WIDTH	2"
CORNER RADIUS	12"
MOUNTING	Overhead
BACKGROUND	TYPE: Reflective COLOR: Green
LEGEND/BORDER	TYPE: Reflective COLOR: White/White

SYMBOL	ROT	X	Y	WID	HT
ARMED	45	209.5	41.5	20	31.5

Panel Style: sign_default.ssi
Dimensions are in inches.tenths

FONT:
(1) ClearviewHwy-5-W-R
(2) ClearviewHwy-5-W

Letter locations are panel edge to lower left corner

LETTER POSITIONS (X)

															LENGTH	SERIESSIZE		
E	X	I	T	2	7	C											88.3	ClearviewHwy-5-W 12,15
151.8	162	175.7	181.6	199.2	213.4	227.8											149.1	ClearviewHwy-5-W-R 1613
O	a	k	l	e	y		B	l	v	d							60.4	ClearviewHwy-5-W-R 10
18	36.5	52.5	66.9	75.2	89.5	101.9	117.2	133.8	140.8	155.5							159.6	ClearviewHwy-5-W-R 1613
2	3	0	0		W												61.1	ClearviewHwy-5-W-R 10
60.9	69.9	79.5	90.4	98.5	108.1													
W	e	s	t	e	r	n		A	v	e								
18	42.2	56.9	69.7	80.9	97.1	108.1	119.1	134.6	151.2	165.9								
2	4	0	0		W													
65.8	74.9	85.1	96	104.1	113.7													

FILE NAME =	DESIGNED - SEW	REVISED -
\$FILEL\$	DRAWN - SEW	REVISED -
USER NAME = \$USER\$	CHECKED - SEW	REVISED -
PLOT DATE = \$DATE\$	DATE - 12/2009	REVISED -



STATE OF ILLINOIS
DEPARTMENT OF TRANSPORTATION

SIGNING DETAILS

SCALE: N.T.S. SHEET NO. 57 OF 79 SHEETS STA. TO STA.

F.A.I. RTE.	SECTION	COUNTY	TOTAL SHEETS	SHEET NO.
290	(2828B,D, ETC., 3031,1)RS-6	COOK	300	270
FED. ROAD DIST. NO. [ILLINOIS] FED. AID PROJECT			CONTRACT NO. 60653	