


SIGN DETAIL
1:75

WB-BM-140
STA. 1172+00

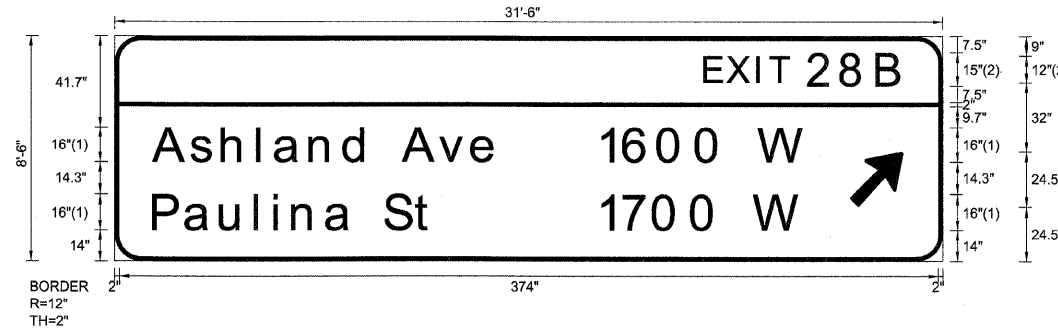

FONT:
(1) ClearviewHwy-5-W-R
(2) ClearviewHwy-5-W

Panel Style: sign_default.ssi
Dimensions are in inches tenths

Letter locations are panel edge to lower left corner

SIGN NUMBER	name
WIDTH x HIGHT.	31'-6" x 8'-6"
BORDER WIDTH	2"
CORNER RADIUS	12"
MOUNTING	Overhead
BACKGROUND	TYPE: Reflective
	COLOR: Green
LEGEND/BORDER	TYPE: Reflective
	COLOR: White/White

SYMBOL	ROT	X	Y	WID	HT
ARMED	45	335.5	24.5	20	31.5

LETTER POSITIONS (X)

													LENGTH	SERIES/SIZE
E	X	I	T	2	8	B							90.3	ClearviewHwy-5-W 12,15
269.8	280	293.7	299.6	317.2	332.3	348.6								
A	s	h	l	a	n	d	A	v	e				157	ClearviewHwy-5-W-R 1613
18	35.1	49.4	65.6	73.5	89.4	105	116.5	132	148.6	163.3				
1	6	0	0		W								94.5	ClearviewHwy-5-W-R 16
220.8	232.8	248.5	266	279	294.3									
P	a	u	l	i	n	a	S	t					127.5	ClearviewHwy-5-W-R 1613
18	32.6	48.6	64.5	73.1	81.6	96.8	108.6	123.6	137.7					
1	7	0	0		W								92.5	ClearviewHwy-5-W-R 16
220.8	231.9	246.5	263.9	276.9	292.2									

FILE NAME =	DESIGNED - SEW	REVISED -
FILEL	DRAWN - SEW	REVISED -
USER NAME = *USER*	CHECKED - SEW	REVISED -
PLOT DATE = *DATE*	DATE - 12/2009	REVISED -



STATE OF ILLINOIS
DEPARTMENT OF TRANSPORTATION

SIGNING DETAILS

SCALE: N.T.S. SHEET NO. 63 OF 79 SHEETS STA. TO STA.

F.A.I. RTE.	SECTION	COUNTY	TOTAL SHEETS	SHEET NO.
290	(2828B,D, ETC., 3031)RS-6	COOK	300	276
FED. ROAD DIST. NO. ILLINOIS FED. AID PROJECT			CONTRACT NO. 60G53	