
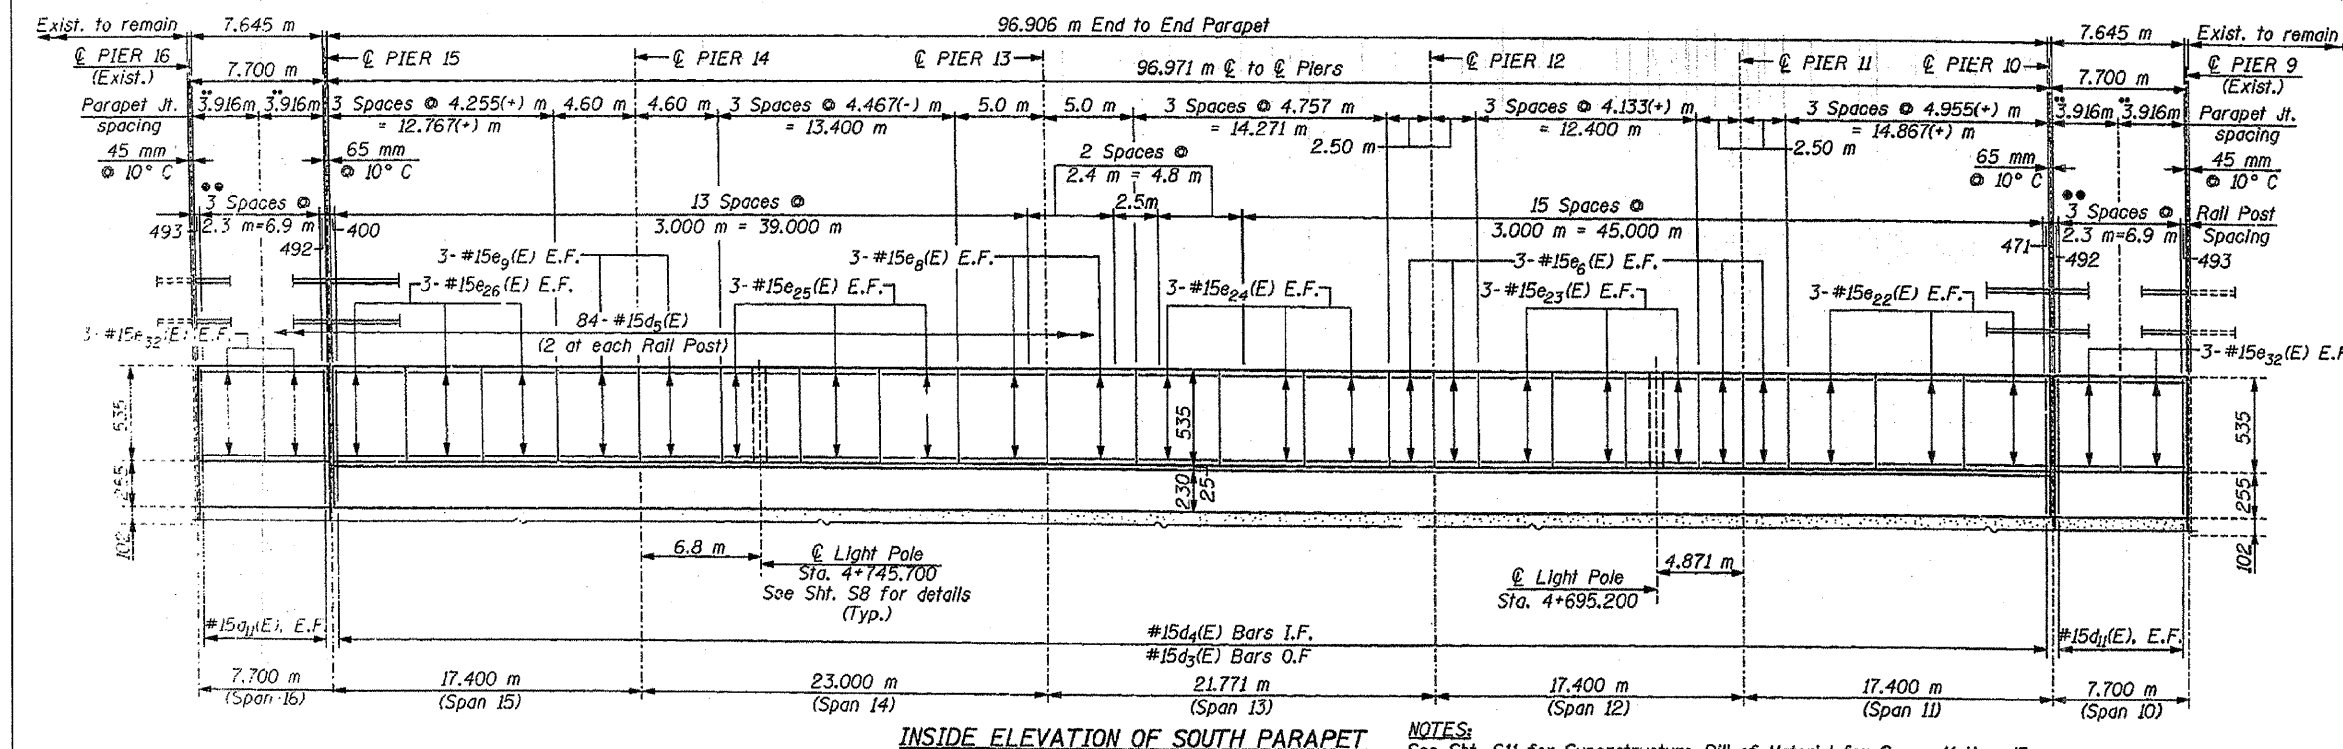


F.A.U. RTE.	SECTION	COUNTY	TOTAL SHEETS NO.	SHEET NO.
3578	15VB-1-R	COOK	243	184
STA. 4+665.229		TO STA. 4+777.600		
FED. ROAD DIST. NO. 7		ILLINOIS FED. AID PROJECT		

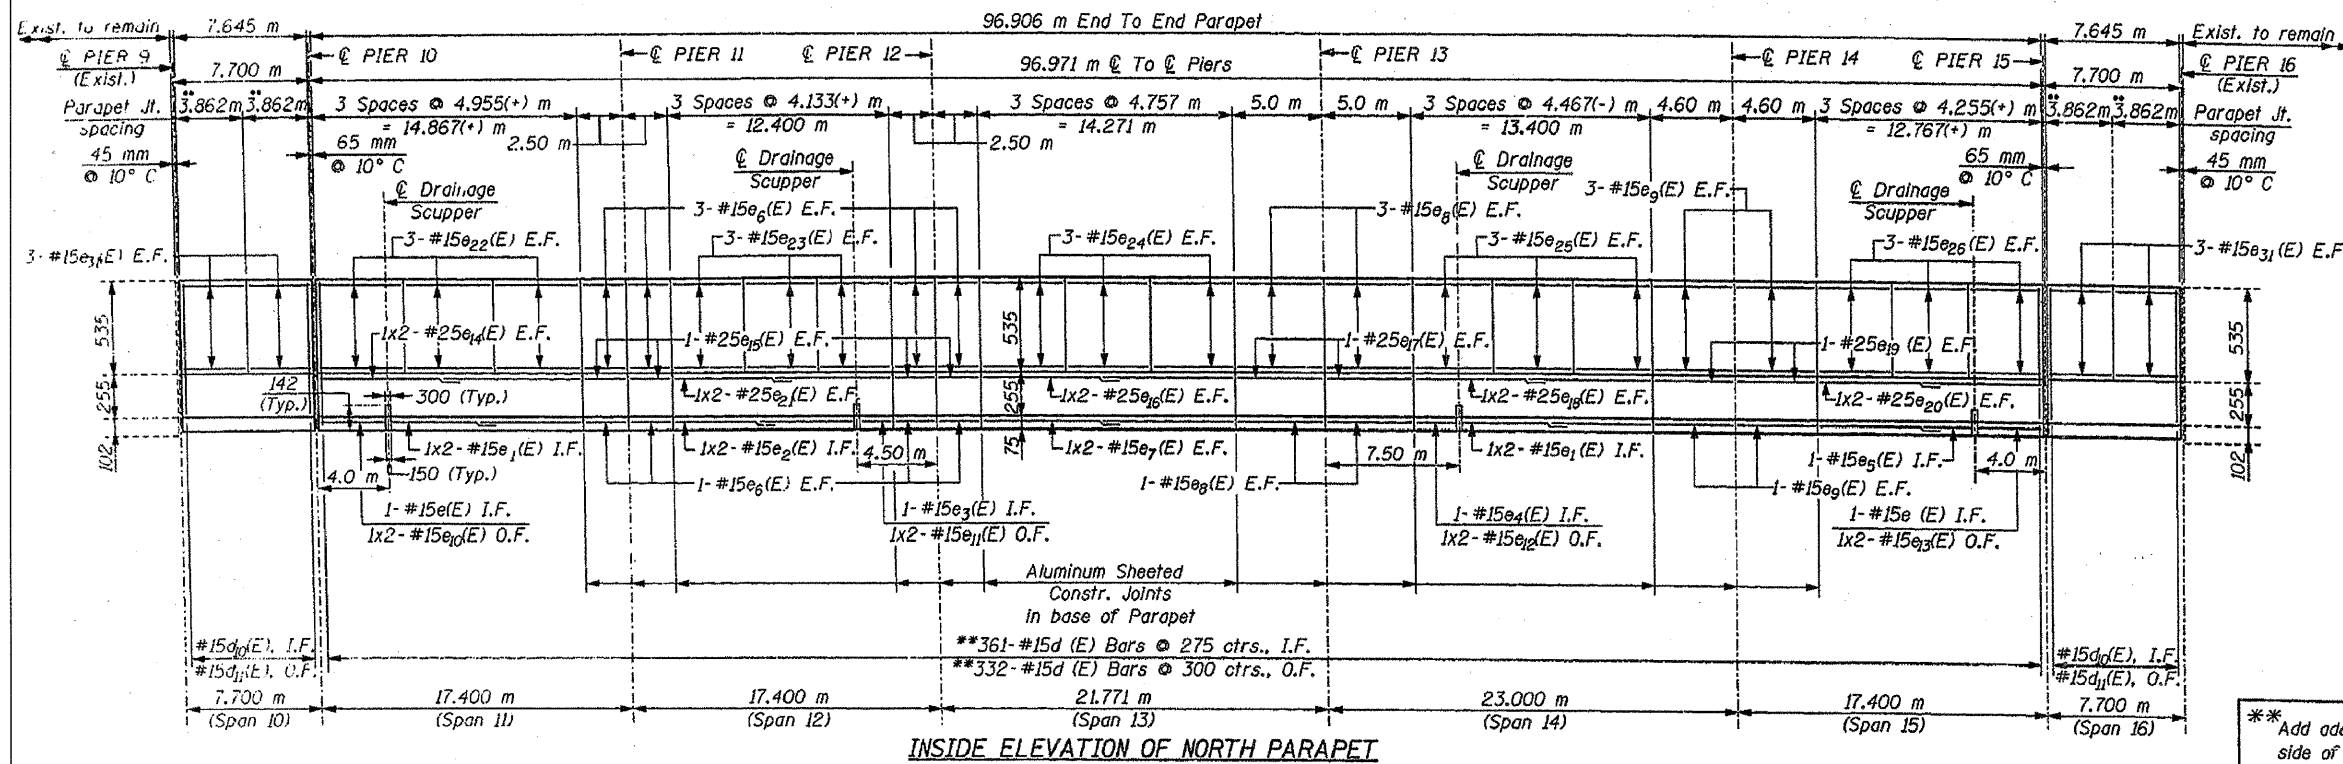

NOTES:
 See Sht. S11 for Superstructure Bill of Material for Spans 11 thru 15 and Sht. S9 for Superstructure Bill of Material for Span 10 and 16.
 Reinforcement Bars designated (E) shall be Epoxy Coated.
 Bars indicated thus 1x2-#15 ect., indicates 1 line of bars with 2 lengths per line.
 See Sht. S11 for Section thru Parapet, Section thru Sidewalk and Parapet Joint Details.
 For Scupper Details See Sht. S11.
 All dimensions are in millimeters (mm) except as noted.
 See Lighting Plans for details of embedded conduit.
 See Sht. S12 for details of Roll Post for Type L Aluminum Railing.

REVISIONS	
NAME	DATE

ILLINOIS DEPARTMENT OF TRANSPORTATION

PARAPET ELEVATIONS

SOUTHWEST HIGHWAY OVER
 B. & O.C.T. RAILROAD AND MELVINA DITCH
 F.A.U. ROUTE 3578 SEC. 15VB-1-R
 COOK COUNTY STATION 4+716.471
 STRUCTURE NO. 016-0463

SCALE: DRAWN BY: F. MUNIR
 DATE: 6/17/09 CHECKED BY: B. SHAH

CHRISTIAN - ROGE & ASSOC.
 CHICAGO ILLINOIS

FOR INFORMATION ONLY