


NORTH PARK AVE

RAVINE DR


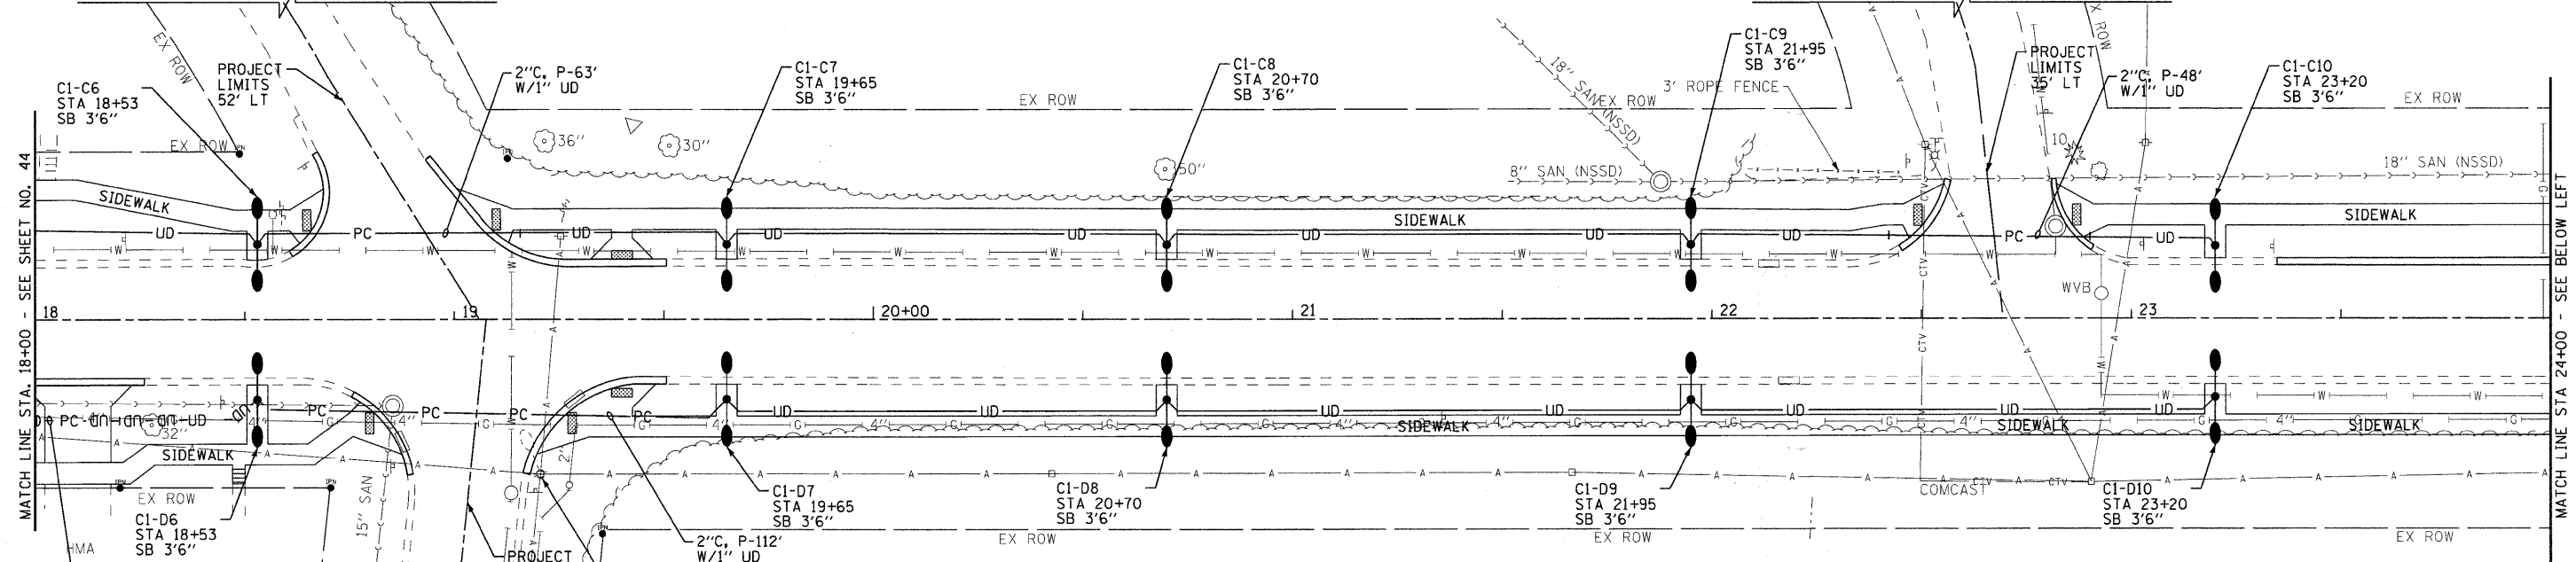


LANDON AVE

7TH STREET

LEGEND

- EXISTING COM ED POWER POLE
- SERVICE PEDESTAL
- 1" UNIT DUCT 3*6 & 1*8 GROUND
- 2" CONDUIT, PUSHED LENGTH AS SHOWN WITH 1" UNIT DUCT OR AS NOTED
- 2" CONDUIT, TRENCHED LENGTH AS SHOWN WITH 3*2
- PROPOSED STREET LIGHT, 150W PMH, COBRAHEAD
- EXISTING STREET LIGHT
- PROPOSED LIGHTING CONTROLLER
- PROPOSED STREET LIGHT, 50W MH, DUAL DECORATIVE FIXTURE
- SB SETBACK FROM BACK OF CURB

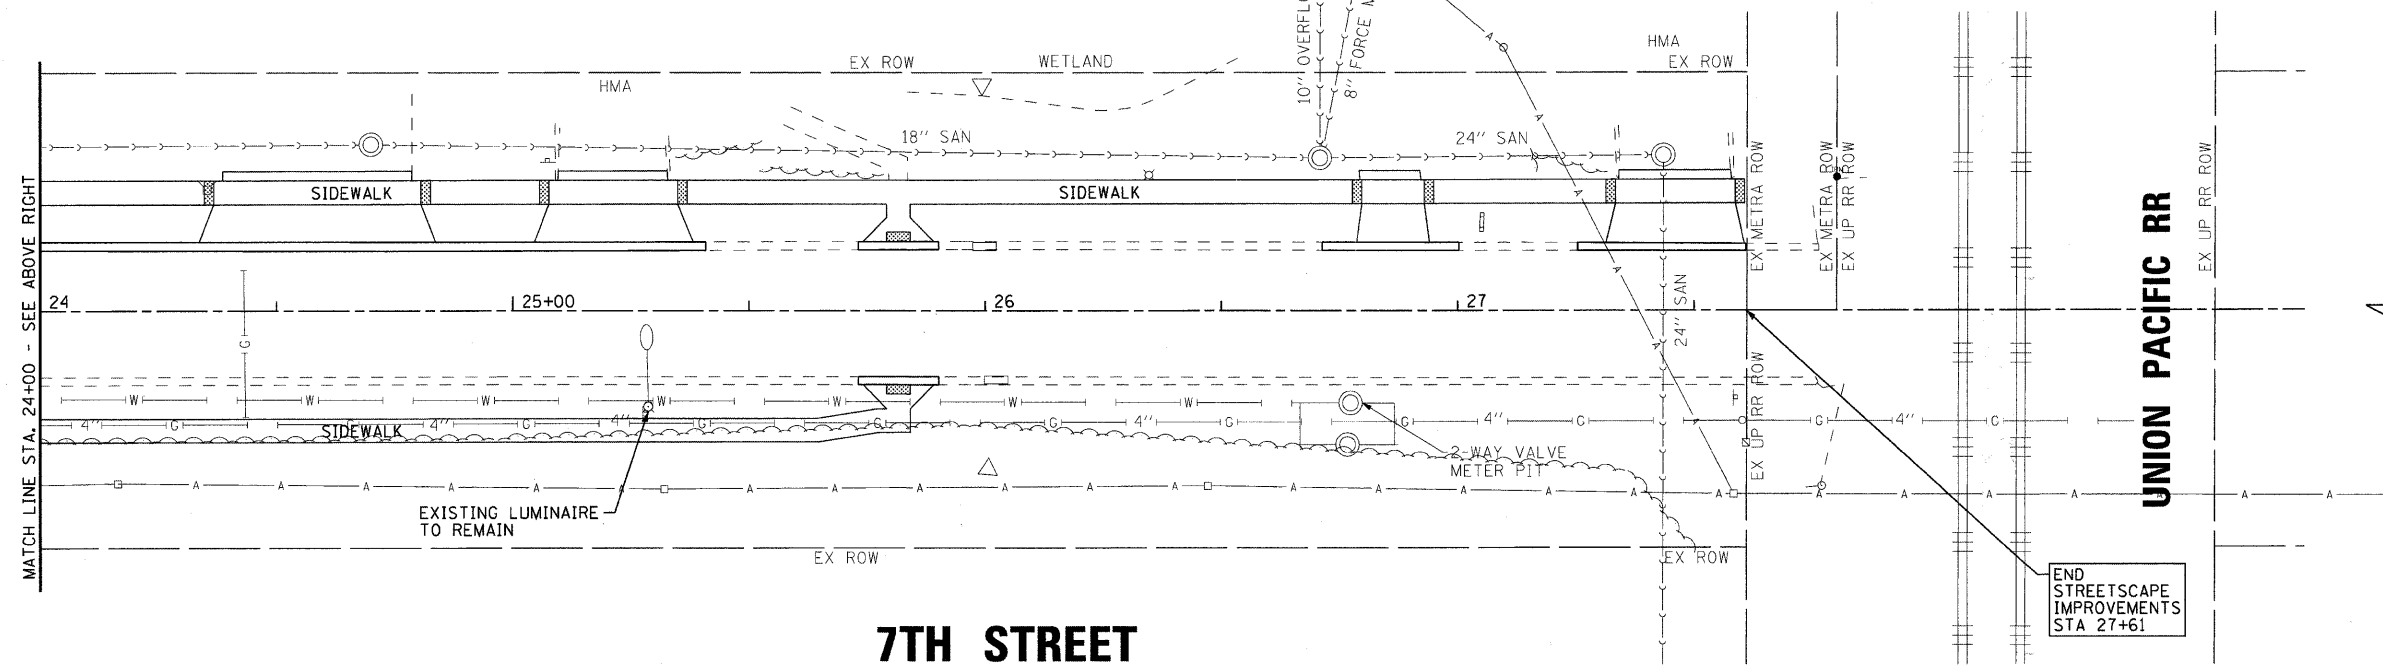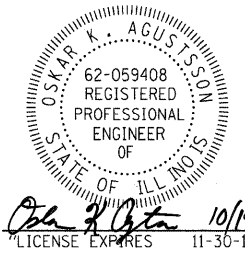

7TH STREET

NOTE:
ASSEMBLE DUAL DECORATIVE LIGHT UNITS SUCH THAT ELECTRICAL RECEPTACLE FACES EAST WHEN UNIT IS INSTALLED ALONG ROADWAY.

COPYRIGHT © 2009 BY BAXTER & WOODMAN, INC.
 ALL RIGHTS RESERVED.
 LICENSE NO. 184-000217 EXPIRES 12/31/2011
 I:\win\060807\060807.dgn\sheet 15\060807-lighting-2.sht
 3:53:27 PM



DESIGNED - OKA	REVISED - IDOT REVIEW 2/19/09
DRAWN - CJC	REVISED - IDOT REVIEW 4/22/09
CHECKED - JTB	REVISED -
DATE - 8-1-08	FILE - 060807-lighting-2.sht

VILLAGE OF WINTHROP HARBOR, ILLINOIS
ILLINOIS ROUTE 137 (SHERIDAN ROAD) AND 7th STREET
STREETSCAPE IMPROVEMENTS

STREET LIGHTING PLAN
7TH STREET

SCALE: 1" = 20' STA. 18+00 TO STA. 28+00

F.A.P. RTE.	SECTION	COUNTY	TOTAL SHEETS	SHEET NO.
•	06-00036-00-LS	LAKE	70	45
FED. ROAD DIST. NO. 1			CONTRACT NO. 63167	
JOB NO. C-91-197-10 ILLINOIS FED. AID PROJECT ARA-0001810				

• F.A.P. 352 ILLINOIS ROUTE 137 (SHERIDAN ROAD)