

| | | |
|------|-----------|------|
| PLAN | SURVEYED | DATE |
| | PLOTTED | |
| | CHECKED | |
| | BY | |
| | NO. | |
| | FILE NAME | |


| | | |
|---------|-----------|------|
| PROFILE | SURVEYED | DATE |
| | PLOTTED | |
| | CHECKED | |
| | BY | |
| | NO. | |
| | FILE NAME | |

10-14-2009 16:18:28 BONDHJ02
 C:\IC-WORKSPACE\BONDHJ02\N\F-0844.D TRANS. 87.2282-28868-001\CIVIL\CAD\99 ALL CONTRACTS\CONV\SHEETS CONTRACT 83\DRN\11-4600.DGN

NOTES
 1 POTENTIAL EXISTING UTILITY CONFLICTS TO BE RELOCATED BY OTHERS.


BY OTHERS

MATCH LINE STA. 54+00
 SEE SHEET 56

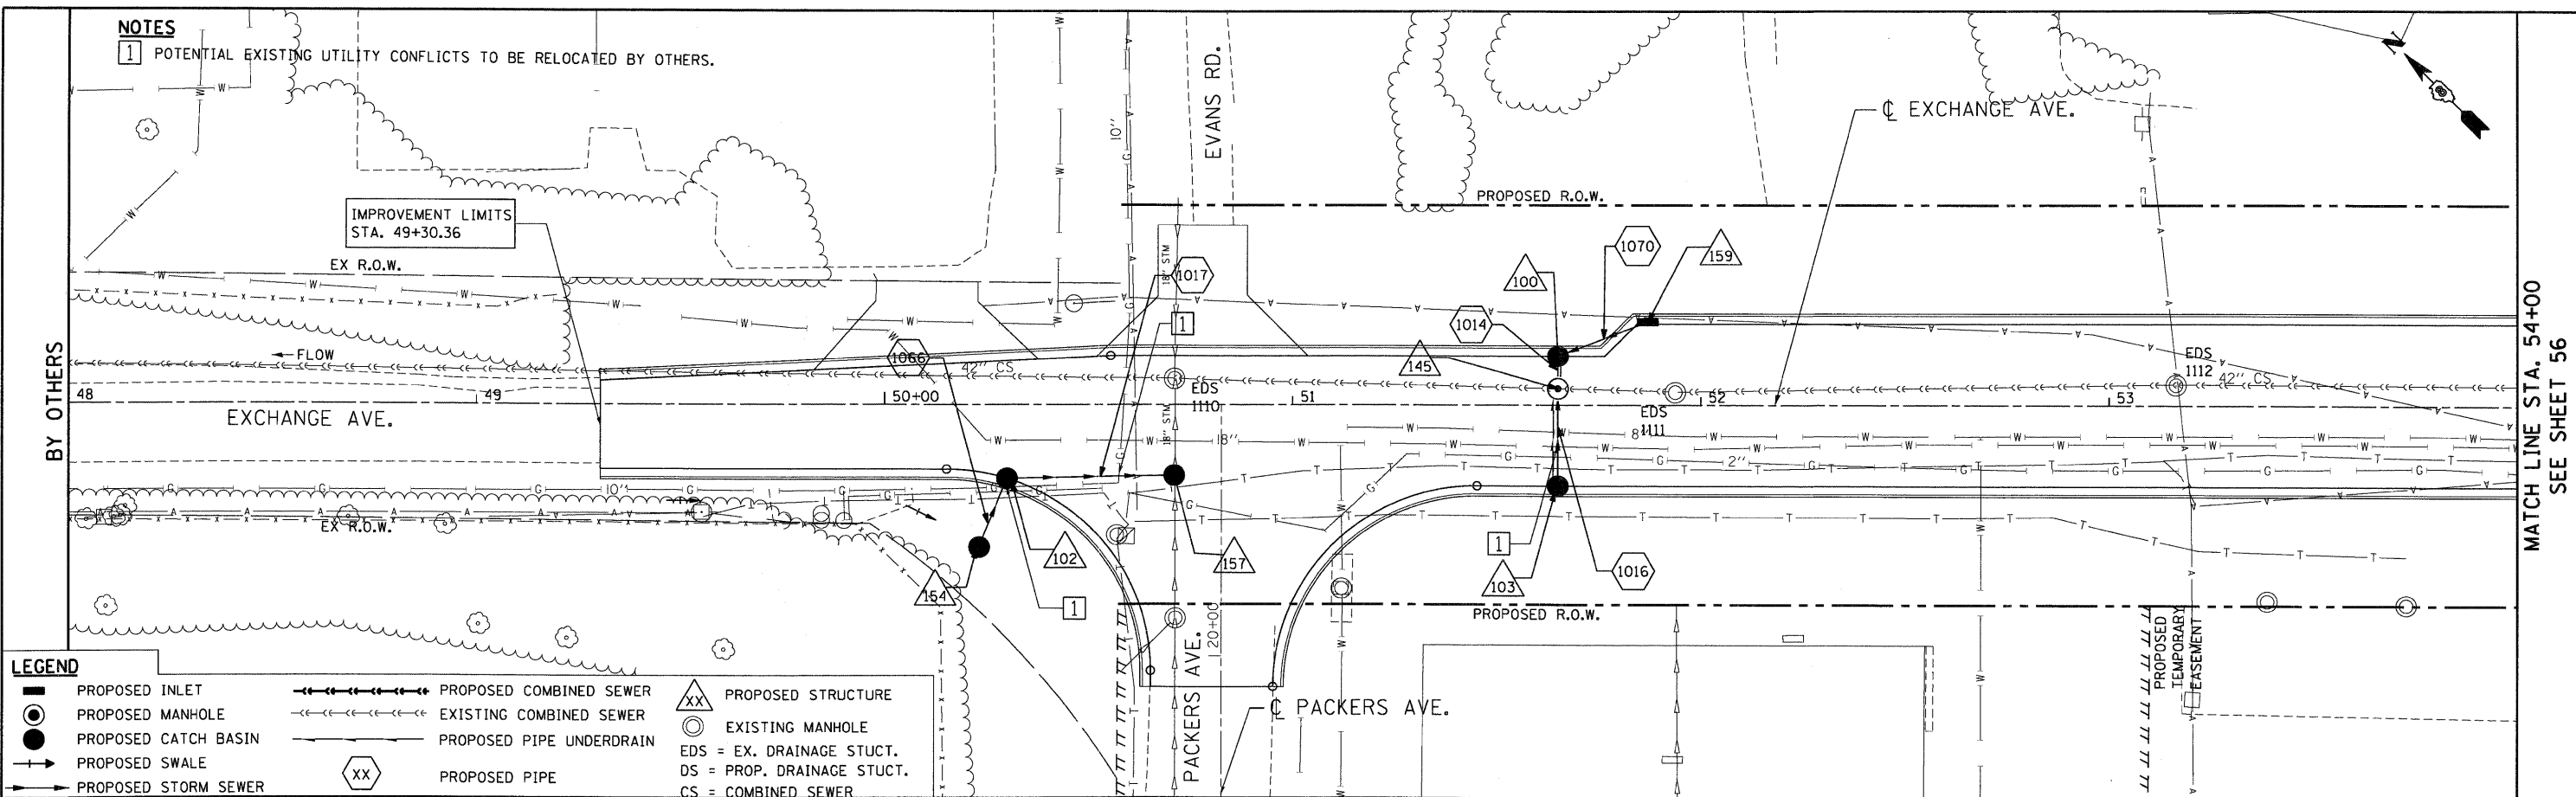

LEGEND

| | | | | | |
|-----------|----------------------|-----------|--------------------------|-----|-------------------------|
| ■ | PROPOSED INLET | —+—+—+—+— | PROPOSED COMBINED SEWER | XX | PROPOSED STRUCTURE |
| ○ | PROPOSED MANHOLE | - - - - - | EXISTING COMBINED SEWER | ○ | EXISTING MANHOLE |
| ● | PROPOSED CATCH BASIN | —+—+—+—+— | PROPOSED PIPE UNDERDRAIN | EDS | = EX. DRAINAGE STUCT. |
| + | PROPOSED SWALE | —+—+—+—+— | PROPOSED PIPE | DS | = PROP. DRAINAGE STUCT. |
| —+—+—+—+— | PROPOSED STORM SEWER | XX | PROPOSED PIPE | CS | = COMBINED SEWER |

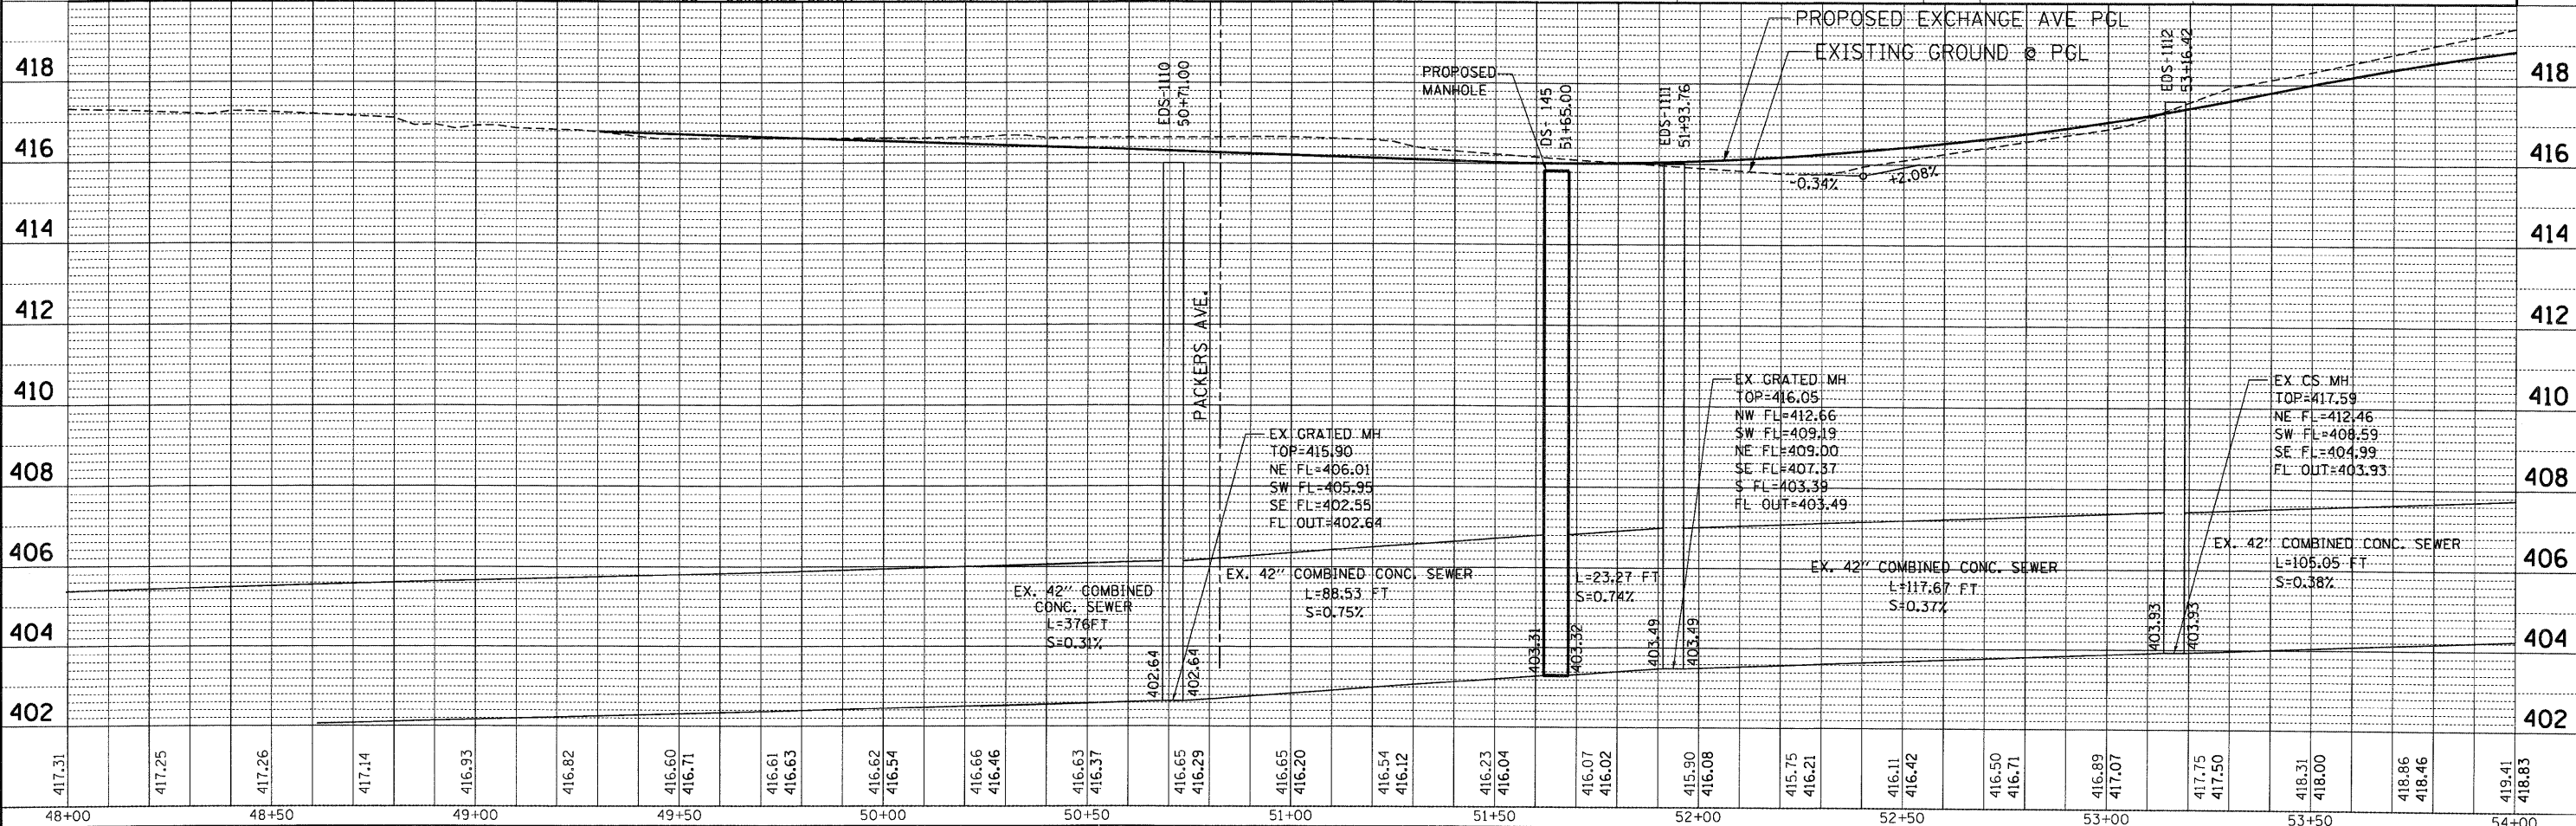

| | | | | | | | | | | |
|-------------|----------------------|-----------------|-----------|--|--|----------------------------------|---------------------------|------------------|------------------|--------------|
| FILE NAME = | USER NAME = #USER# | DESIGNED - MCG | REVISED - | STATE OF ILLINOIS DEPARTMENT OF TRANSPORTATION I-70 CONNECTION | PROPOSED DRAINAGE PLAN & PROFILE EXCHANGE AVENUE STA. 48 + 00.00 TO STA. 54 + 00.00 | F.A.P. RTE. 9153 | SECTION 82-1K | COUNTY ST. CLAIR | TOTAL SHEETS 107 | SHEET NO. 55 |
| #FILE# | PLOT SCALE = #SCALE# | DRAWN - MCG | REVISED - | | | FED. ROAD DIST. NO. | ILLINOIS FED. AID PROJECT | | | |
| | PLOT DATE = #DATE# | CHECKED - TKL | REVISED - | | | CONTRACT NO. 76C40 | | | | |
| | | DATE - 10/09/09 | REVISED - | | | SCALE: HORIZ. 1"=20' VERT. 1"=2' | | | | |