

STATE OF ILLINOIS
DEPARTMENT OF TRANSPORTATION
DIVISION OF HIGHWAYS

PLANS FOR PROPOSED FEDERAL AID HIGHWAY

F. A. U. NO.	SECTION	COUNTY	TOTAL SHEETS	SHEET NO.
0384 0393	09-00054-00-LT	GRUNDY	11	1
STA. 23+48 (RIDGE)		TO STA. 35+88 (MCEVILLY)		
FED. ROAD DIST. NO. 1	ILLINOIS	FED. AID PROJECT ARA-003 (341)		

CONTRACT #87438

INDEX OF SHEETS


1. COVER SHEET
2. SUMMARY OF QUANTITIES
- 3.-5. STREET LIGHTING PLANS
6. SINGLE LINE DIAGRAM
- 7.-11. DETAIL DRAWINGS

STATE STANDARDS


- | | |
|-----------|--|
| 000001-05 | STANDARD SYMBOLS, ABBREVIATIONS AND PATTERNS |
| 701501-05 | URBAN LANE CLOSURE, 2L, 2W, UNDIVIDED |
| 701606-06 | URBAN LANE CLOSURE, MULTILANE, 2W, WITH MOUNTABLE MEDIAN |
| 701701-06 | URBAN LANE CLOSURE, MULTILANE INTERSECTION |
| 701801-04 | LANE CLOSURE, MULTILANE 1W OR 2W CROSSWALK OR SIDEWALK CLOSURE |
| 701901-01 | TRAFFIC CONTROL DEVICES |

FAU 0384 (RIDGE ROAD)
FAU 0393 (MCEVILLY ROAD)
STREET LIGHTING
SECTION NO.: 09-00054-00-LT
PROJECT NO.: ARA-003 (341)
VILLAGE of MINOOKA
GRUNDY COUNTY
JOB NO.: C-93-016-10

	RIDGE ROAD	MCEVILLY ROAD
2007 ADT -	13,700	8,200
2030 ADT -	30,000	14,000
POSTED SPEED LIMIT -	40 MPH	35 MPH
DESIGN PERIOD -	20 YEARS	20 YEARS
DESIGN SPEED -	45 MPH	40 MPH
FUNCTIONAL CLASSIFICATION -	URBAN MINOR ARTERIAL	URBAN MINOR ARTERIAL
I.E.S. ROADWAY CLASSIFICATION -	MAJOR	COLLECTOR
I.E.S. PEDESTRIAN AREA CLASSIFICATION -	LOW	MEDIUM

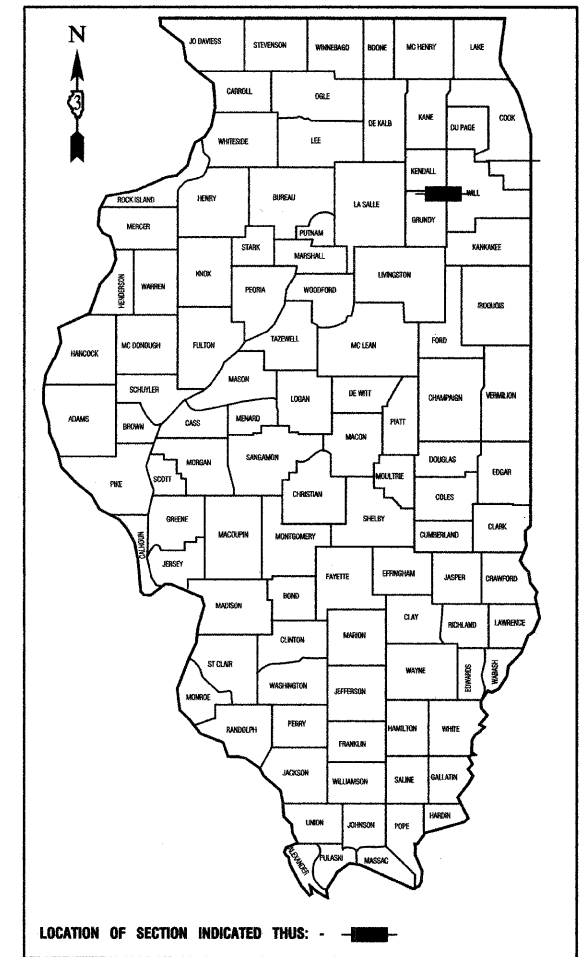


SCALES
 PLAN - 1"=50'
 PROFILE HORIZ. - 1"=50'
 PROFILE VERT. - 1"=5'
 CROSS SECTIONS - 1"=10'

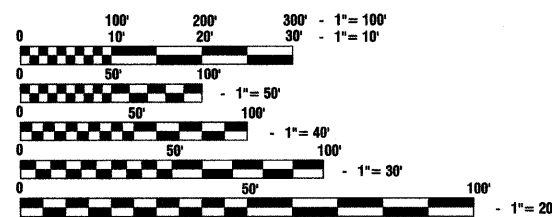

FULL SIZE PLANS HAVE BEEN PREPARED USING STANDARD ENGINEERING SCALES, REDUCED SIZED PLANS WILL NOT CONFORM TO STANDARD SCALES, IN MAKING MEASUREMENTS ON REDUCED PLANS, THE ABOVE SCALES MAY BE USED.

J. U. L. I. E.
JOINT UTILITY LOCATION INFORMATION FOR EXCAVATION
1-800-892-0123 or 811

CONTRACT NO. 87438

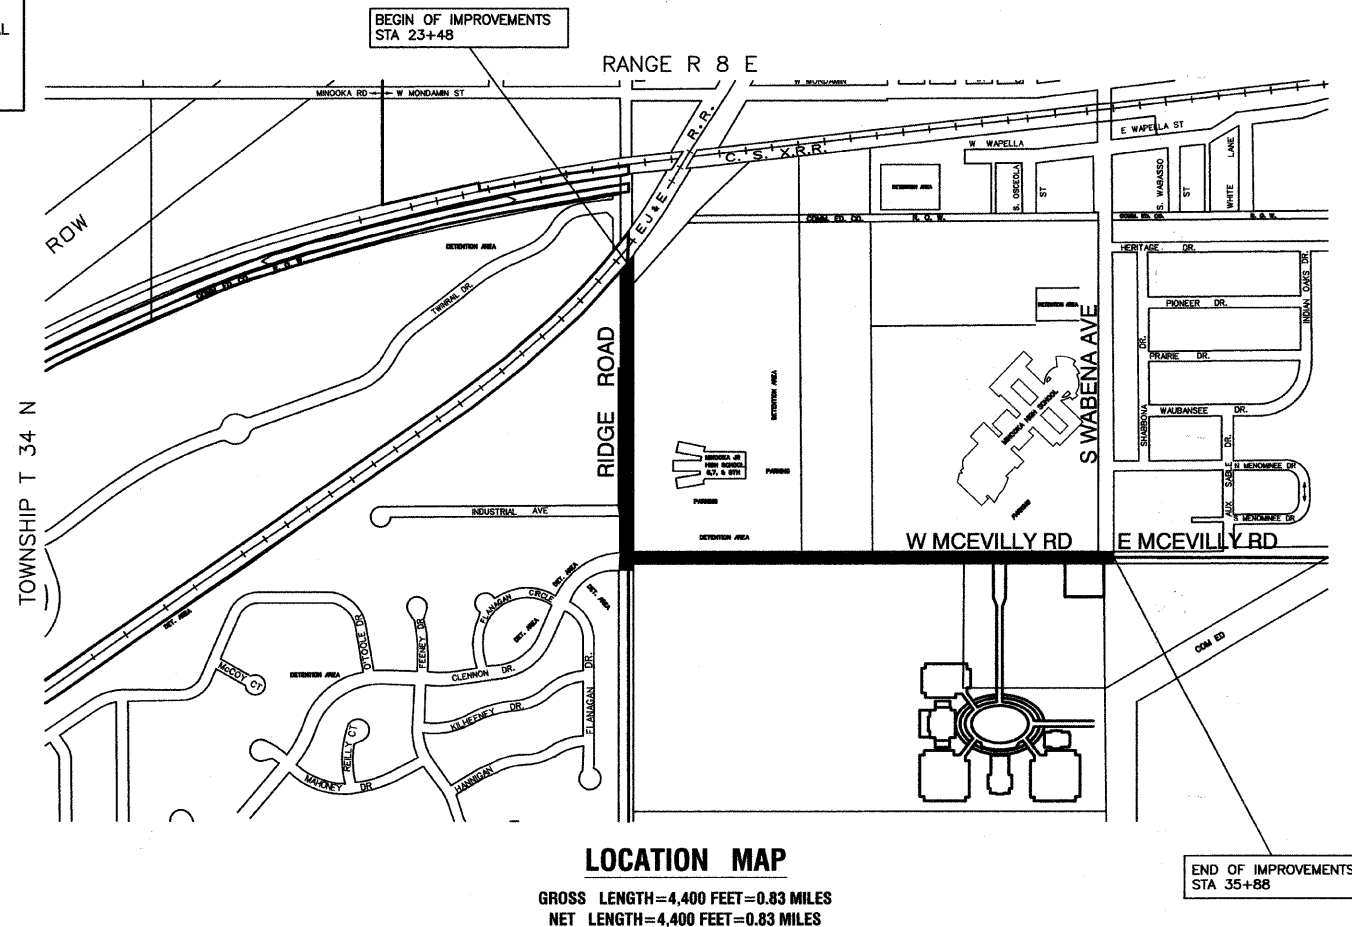

STATE OF ILLINOIS DEPARTMENT OF TRANSPORTATION
DIVISION OF HIGHWAYS

Approved: 10/21/09
Petrus J. Brennan
President, Village of Minooka

Passed: 10-28-09
Kenneth B. Jany
District 3 Engineer of Local Roads & Streets

Released for Bid Based on Limited Review: 10-28-09
Harvey F. Ryan
Deputy Director of Highways, Regional Engineer

PRINTED BY THE AUTHORITY OF
THE STATE OF ILLINOIS

PREPARED BY OR UNDER THE
DIRECT SUPERVISION OF:

S.P.V.
10/21/09



LICENSE EXPIRES: 11/30/11

CONSULTANTS: ROBINSON ENGINEERING, LTD. 708-331-6700