


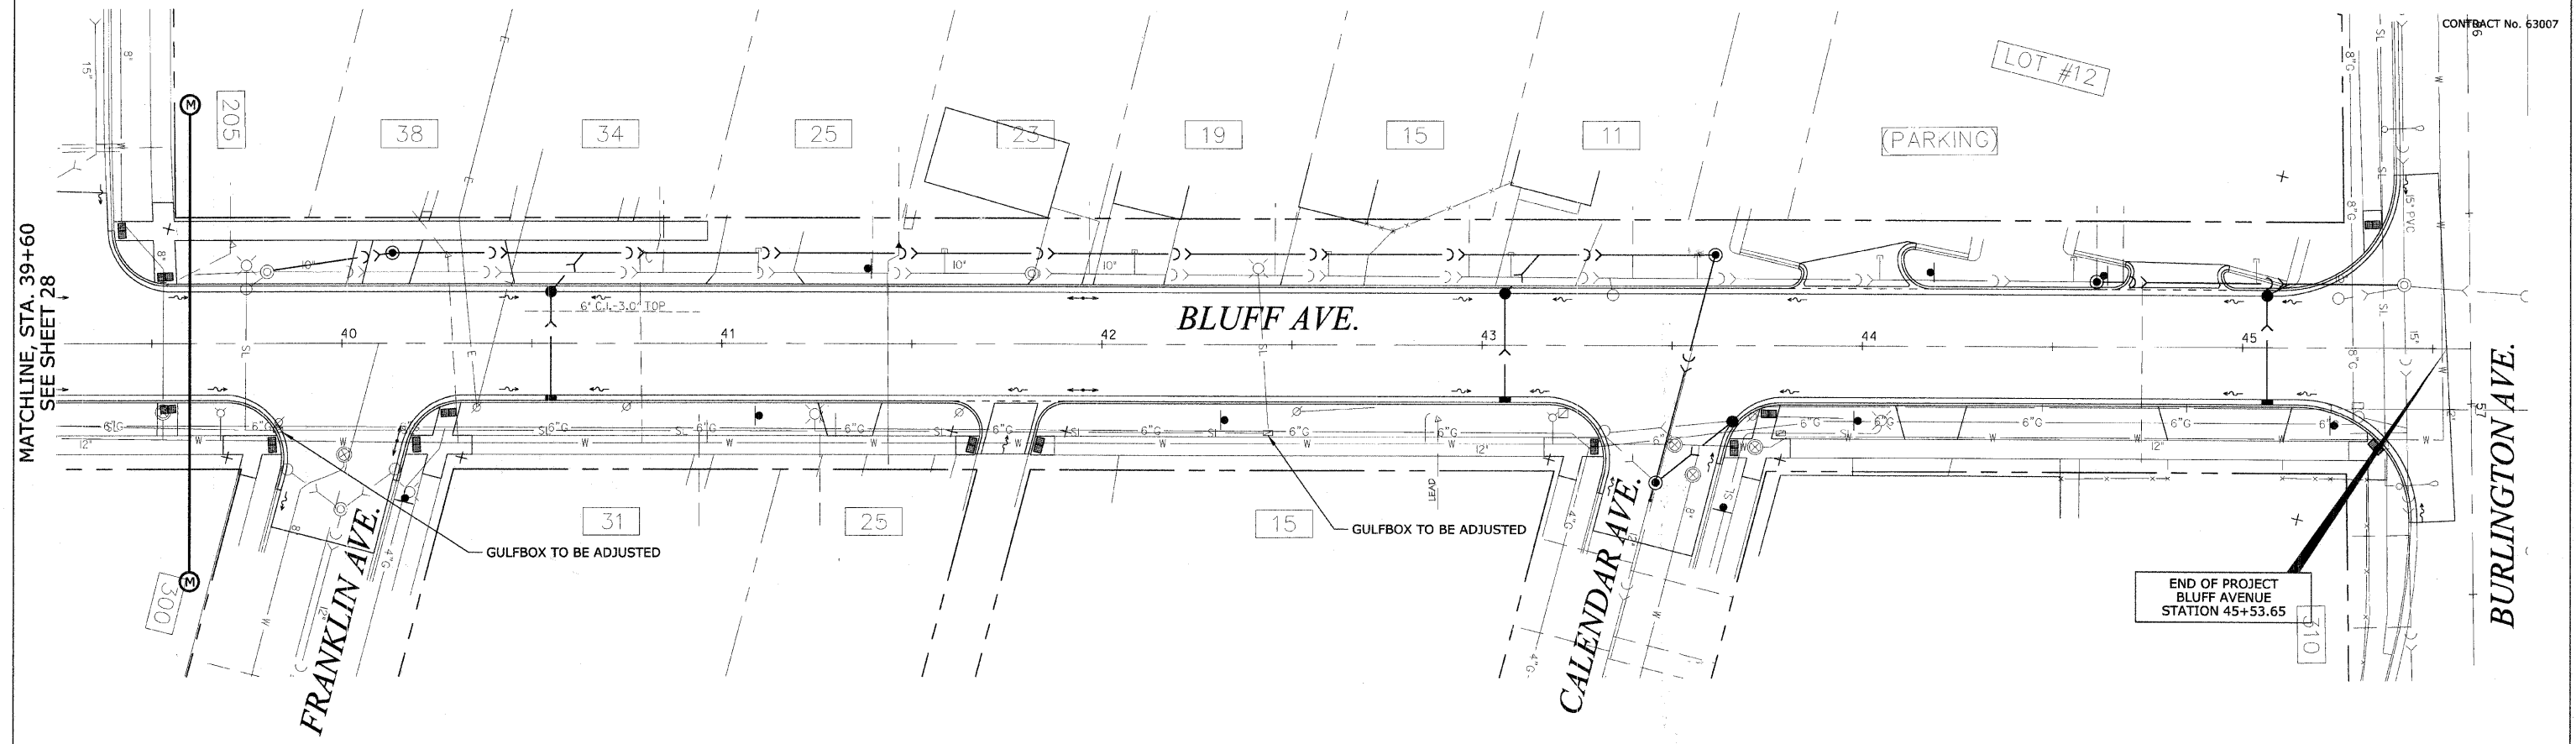

PLAN	DESIGNED	DATE
NOTE BOOK	ALIGNED	
NO.	CHECKED	
	FILE NAME	
	FILE NO.	

PROFILE	DESIGNED	DATE
NOTE BOOK	ALIGNED	
NO.	CHECKED	
	FILE NAME	
	FILE NO.	



REVISIONS		NAME	DATE
NO.	DESCRIPTION		

ILLINOIS DEPARTMENT OF TRANSPORTATION  
**BLUFF AVENUE IMPROVEMENTS**  
**STAGE 1**  
**ELECTRICAL/STREETLIGHTING PLAN**

SCALE: 1" = 20' H (Full Size)  
 1" = 44' H (Tabloid)

DATE 07/18/2008

DRAWN BY H&A  
 CHECKED BY PFH