


DATE	
BY	
PLANNING	
DESIGN	
CHECKS	
NO. OF WAY CHECKS	
NO. FILE NAME	


DATE	
BY	
PROFILE	
DESIGN	
CHECKS	
NO. OF WAY CHECKS	
NO. FILE NAME	

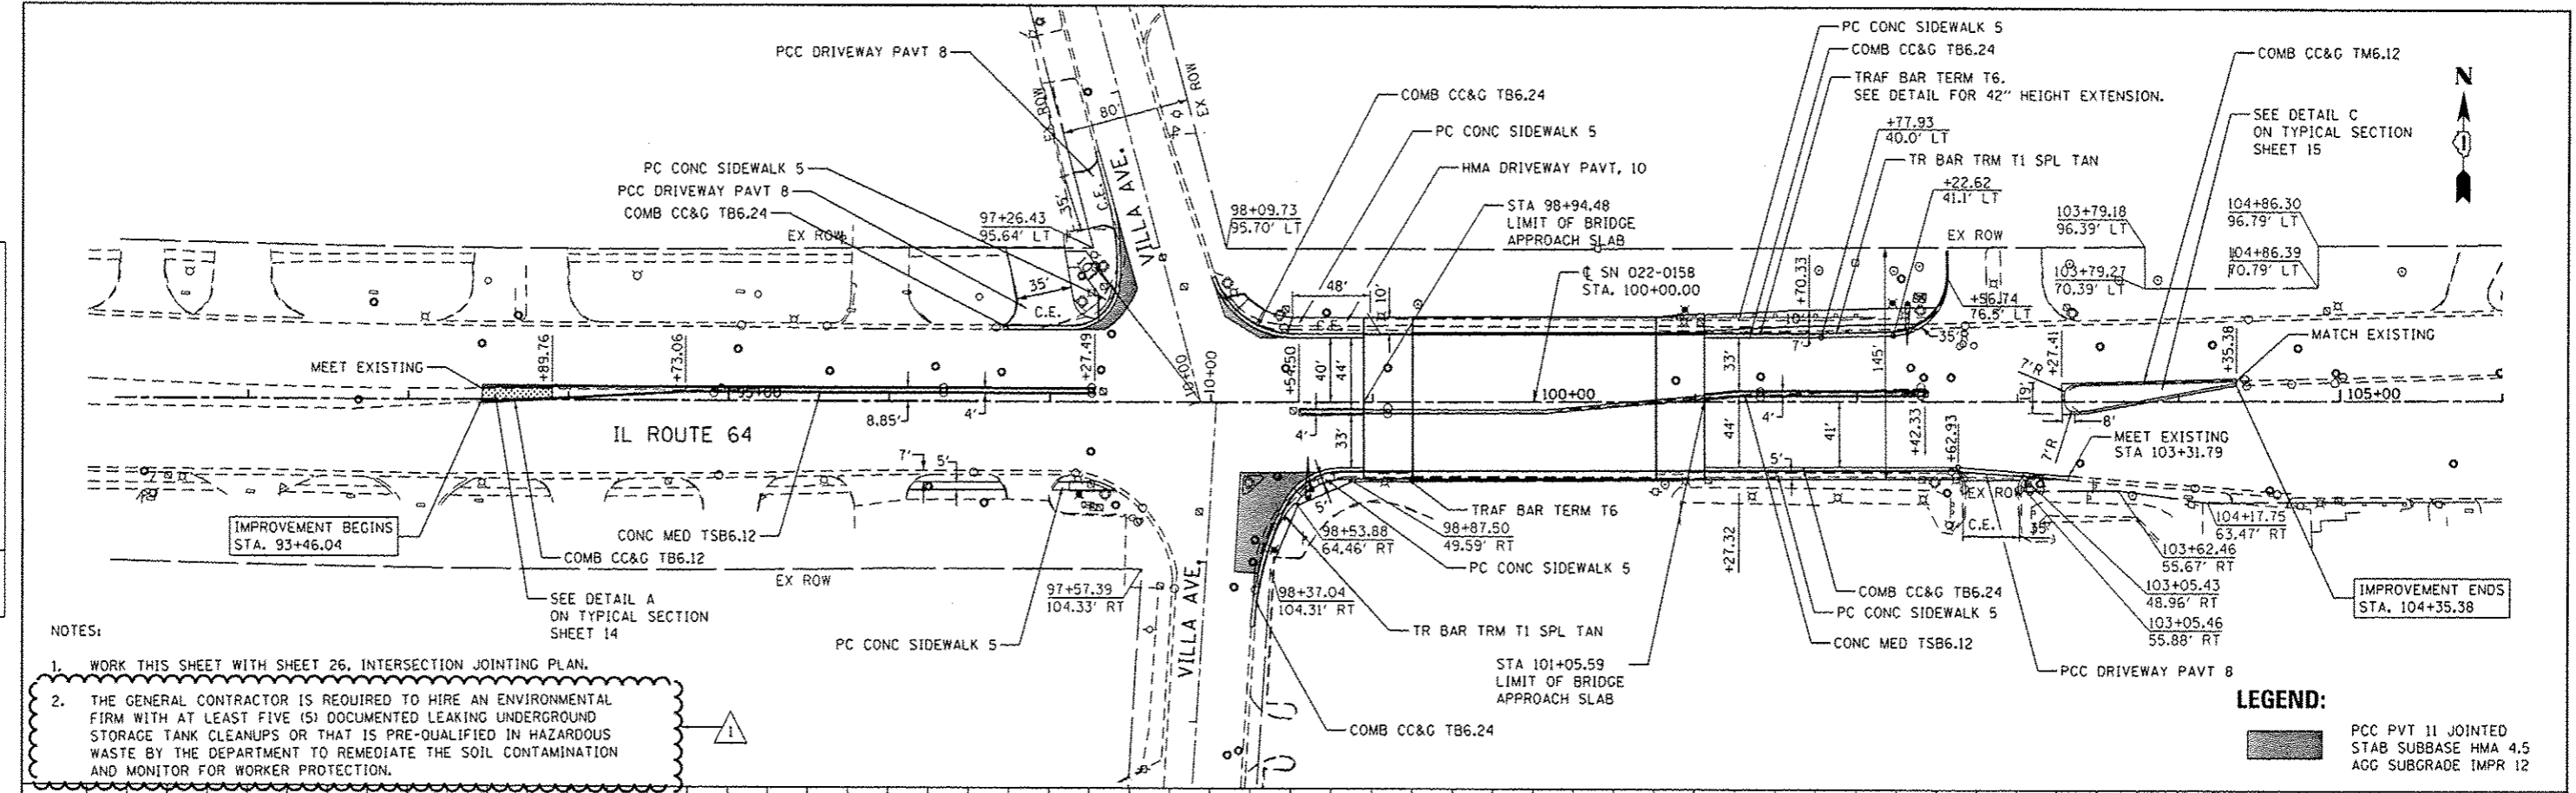

- NOTES:
- WORK THIS SHEET WITH SHEET 26, INTERSECTION JOINTING PLAN.
  - THE GENERAL CONTRACTOR IS REQUIRED TO HIRE AN ENVIRONMENTAL FIRM WITH AT LEAST FIVE (5) DOCUMENTED LEAKING UNDERGROUND STORAGE TANK CLEANUPS OR THAT IS PRE-QUALIFIED IN HAZARDOUS WASTE BY THE DEPARTMENT TO REMEDIATE THE SOIL CONTAMINATION AND MONITOR FOR WORKER PROTECTION.

**LEGEND:**  

 PCC PVT 11 JOINTED STAB SUBBASE HMA 4.5 AGG SUBGRADE IMPR 12

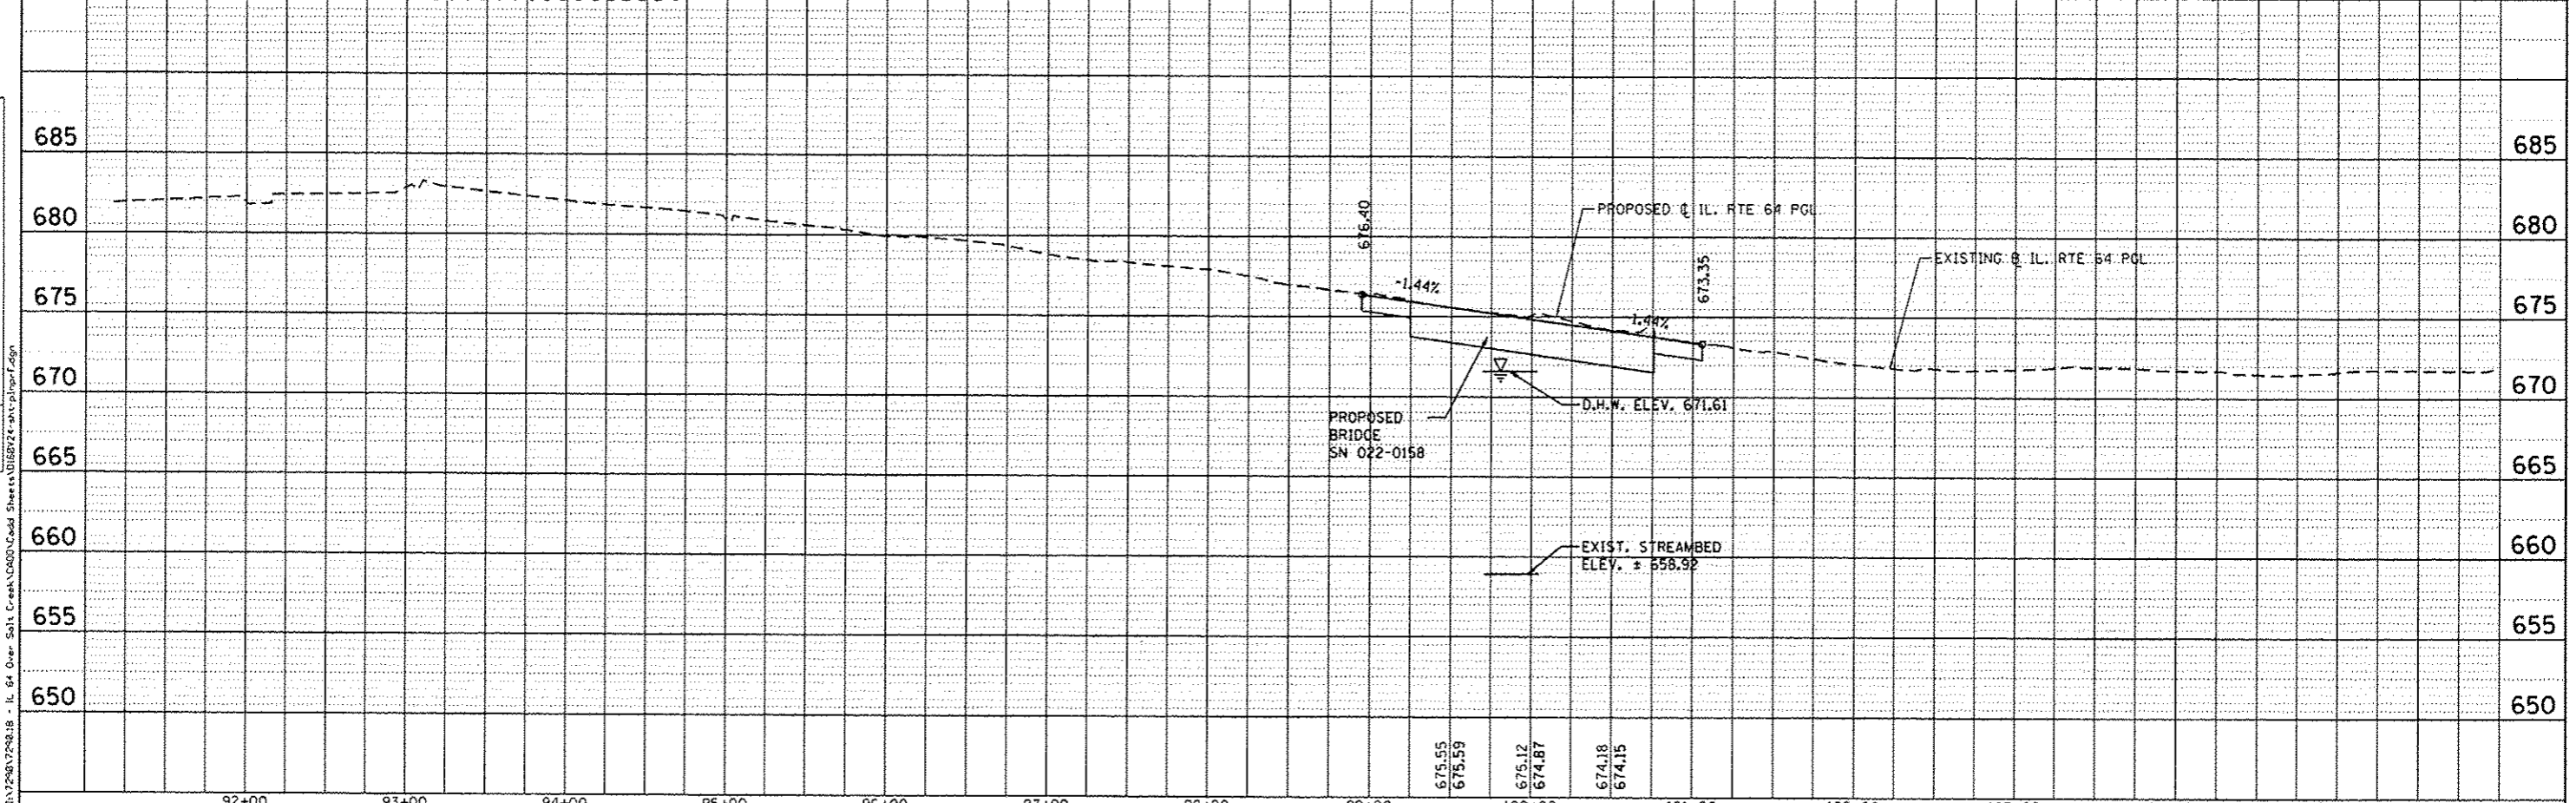

92+00	93+00	94+00	95+00	96+00	97+00	98+00	99+00	100+00	101+00	102+00	103+00	104+00	105+00	106+00
<b>COLLINS ENGINEERS</b> 1111 N. Dear St. Suite 200 Chicago, IL 60610 Phone: (773) 784-1300 Fax: (773) 784-1302 www.collinseng.com ILLINOIS PROFESSIONAL DESIGN FIRM LICENSE NO. 081-089990		USER NAME: rjgall DESIGNED: - DRAWN: - CHECKED: - DATE: -	DESIGNED: - DRAWN: - CHECKED: - DATE: -	REVISED: 12/20/2013 R.A.G. REVISED: - REVISED: - REVISED: -	<b>STATE OF ILLINOIS</b> <b>DEPARTMENT OF TRANSPORTATION</b>			<b>ILLINOIS ROUTE 64 (NORTH AVE) OVER SALT CREEK</b> <b>PLAN AND PROFILE</b>			F.A.P. RTE. 307 SECTION 1318-BR COUNTY DuPAGE TOTAL SHEET NO. 111 SHEETS 20 CONTRACT NO. 60V24	SCALE: SHEET OF SHEETS STA. TO STA. ILLINOIS FED. AID PROJECT		