


UIC
CUPPA HALL
BUILDING NO. 641

3-4" OEMC (CITY) CONDUITS ATS
TO BE REMOVED
NOTE 1


EXISTING CDOT
STREET LIGHTING
CONTROLLER NO. 15

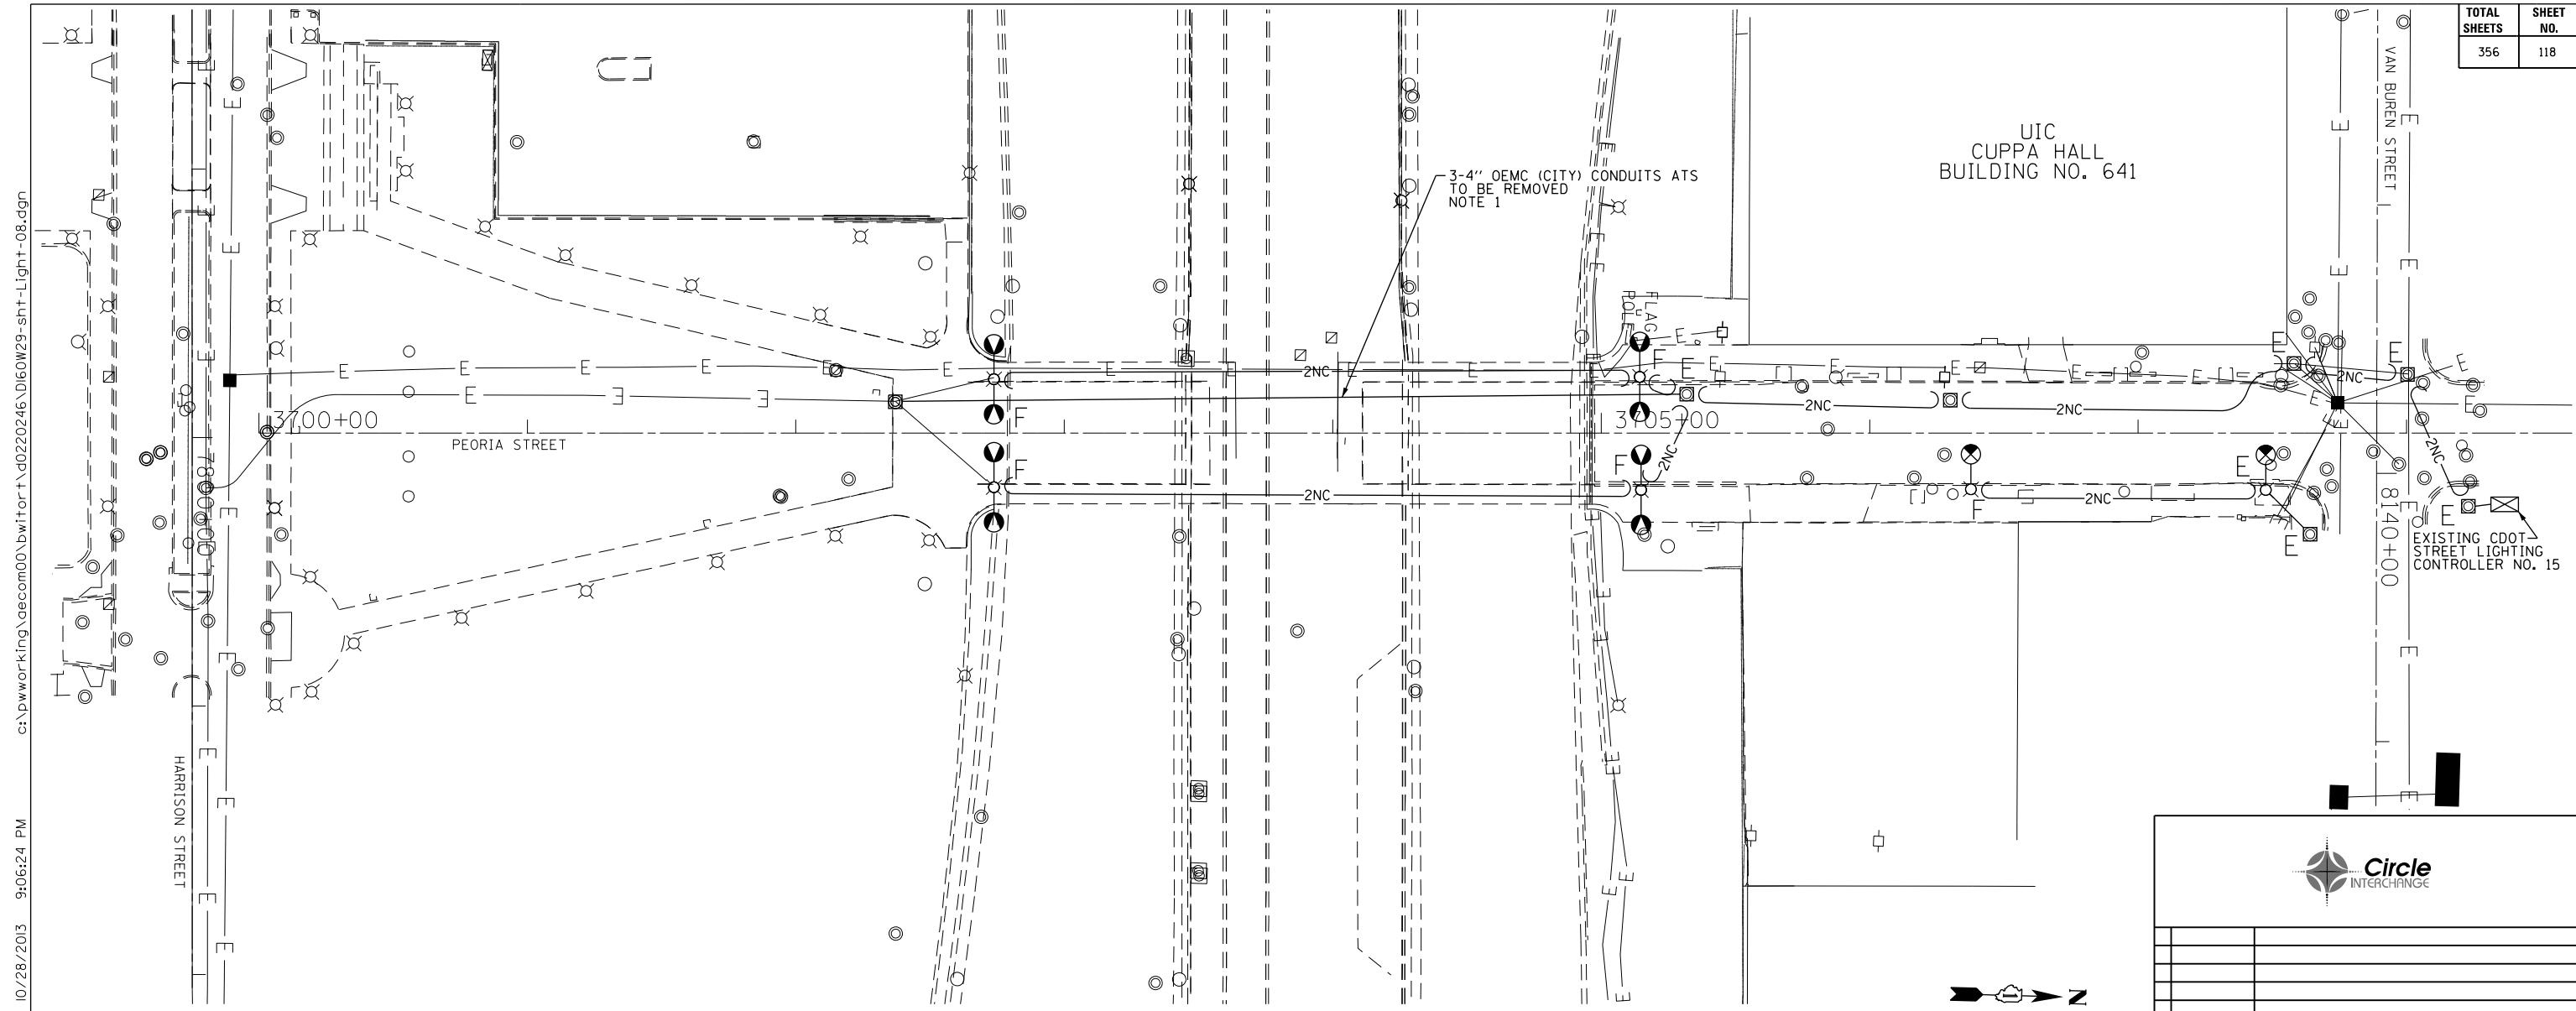

"E" EXISTING TO REMAIN
"F" REMOVE AND SALVAGE EXISTING STEEL POLE, LUMINAIRE(S),
MAST ARM(S) AND BALLAST HOUSING. BREAKDOWN CONCRETE
FOUNDATION COMPLETE.

NOTES:

1. THE EXISTING CDOT CONDUITS ATTACHED TO THE UNDERSIDE OF THE BRIDGE STRUCTURE MAY CONTAIN ASBESTOS MATERIALS. THE CONDUITS SHALL BE REMOVED AND DISPOSED OF PROPERLY PRIOR TO THE BRIDGE DEMOLITION. CONDUITS TESTED AND CONFIRMED TO CONTAIN ASBESTOS MUST BE REMOVED IN ACCORDANCE WITH THE SPECIAL PROVISION "REMOVAL OF ASBESTOS CEMENT CONDUIT". ASBESTOS CONDUIT REMOVAL SHALL BE PAID FOR UNDER THE "REMOVAL OF ASBESTOS CEMENT CONDUIT" PAY ITEM.

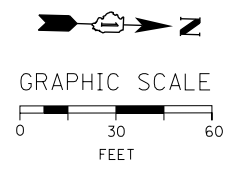

DATE	REVISION
CITY OF CHICAGO	
DEPARTMENT OF TRANSPORTATION DIVISION OF ENGINEERING	
CONSULTANT: AECOM <small>303 EAST WACKER DRIVE, SUITE 1400 CHICAGO, IL 60601-5276 PHONE: (312) 373-7700 FAX: (312) 373-6800</small>	
WORK ORDER NO. _____	DATE _____
COST ALLOCATION ACCOUNT _____	
APPROPRIATION ACCOUNT _____	MATERIAL _____ LABOR _____
PEORIA STREET LIGHTING REMOVAL PLAN	
CITY OF CHICAGO DEPT. OF TRANSPORTATION DIVISION OF ELECTRICAL OPERATIONS	
DRAFTSMAN: CAM	CHIEF DRAFTSMAN: ENGINEER: WDS
SUPERVISING ENGINEER: JPC	ELEC. DESIGN ENGR.
ENGINEER OF ELECTRICITY:	
GEN'L SUPT. OF ELECTRICITY:	
DEPUTY COMMISSIONER:	
SIZE: 22" 34"	SCALE: 1" = 30'
DATE: 05/14/13	DATE:
C.D.O.T. PROJECT NO.:	DWG. NO.:

FOR CONDUIT AND FOUNDATION PLANS
SEE DRAWING NO. E-06.
FOR LIGHTING CABLE AND EQUIPMENT
INSTALLATION PLANS SEE DRAWING NO. E-07.

E-08