


**NOTES:**

1. EXISTING LIGHTING FIXTURES MOUNTED DOWN CENTER OF CANOPY TO BE REMOVED WITHIN NEW ELEVATOR ENCROACHMENT. PROVIDE NEW CONDUIT AND CABLE TO MAINTAIN EXISTING LIGHTING.

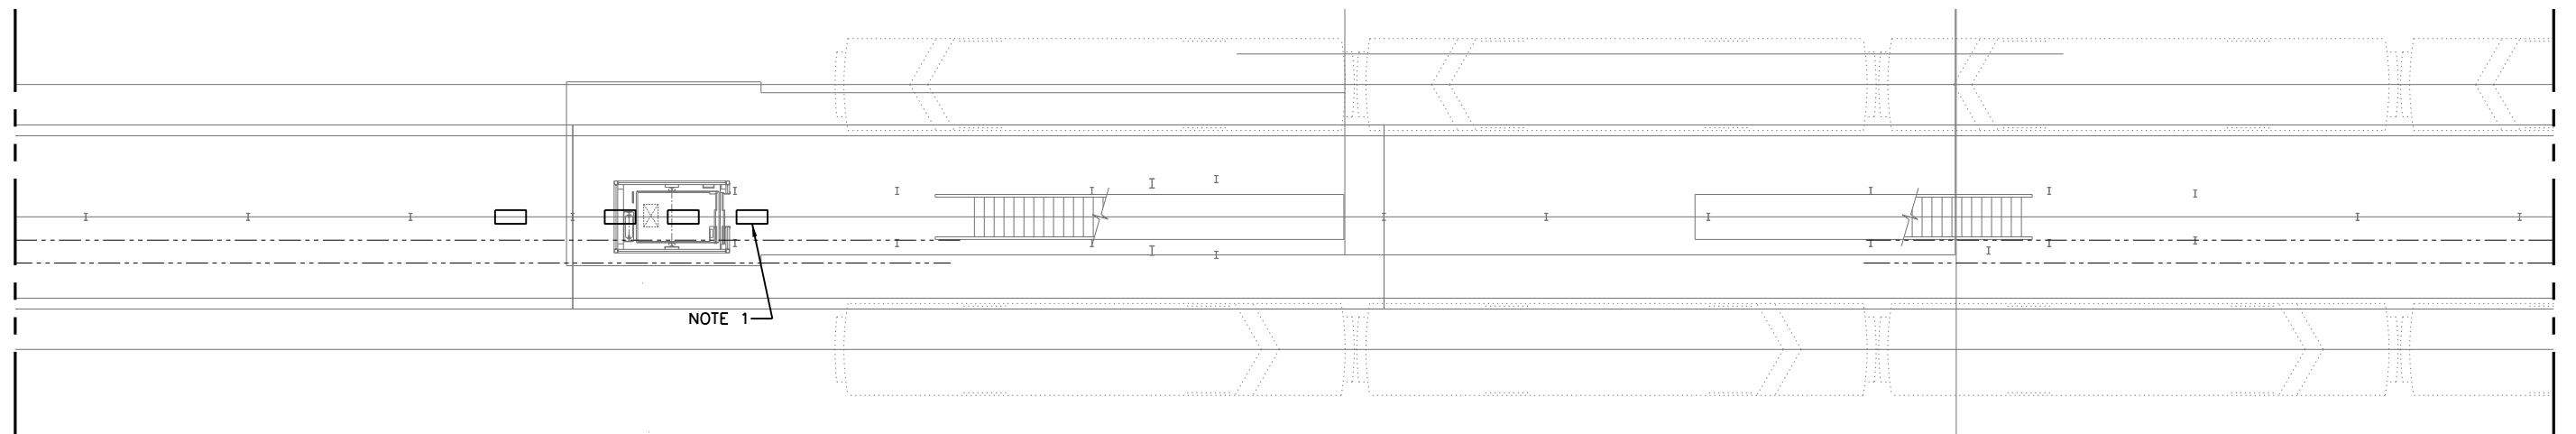

**1** PLATFORM PLAN  
SCALE: 1/8" = 1'-0"



**AAA ENGINEERING**  
WBE/DBE CERTIFIED  
3940 West Touhy Avenue, Suite 210, Niles, IL 60714  
Phone: 847-647-9999 • Fax: 847-647-4719

**TranSystems**

USER NAME = habit	DESIGNED -	REVISED
	CHECKED -	REVISED
PLOT SCALE = 16:0 1/4" / in.	DRAWN -	REVISED
PLOT DATE = 10/28/2013	CHECKED -	REVISED

**STATE OF ILLINOIS**  
**DEPARTMENT OF TRANSPORTATION**

**PEORIA STREET STATION**  
**ELECTRICAL PLATFORM LEVEL POWER PLAN**

SHEET NO. 80 OF 117 SHEETS

PRELIMINARY NOT FOR CONSTRUCTION

MUN	SECTION	COUNTY	TOTAL SHEETS	SHEET NO.
2090	2013-011R	COOK	356	271
CONTRACT NO.			60W29	
ILLINOIS FED. AID PROJECT				

8/3/21 PM 271-60W29.dgn