 



NOTES:



1. REFER TO BRIDGE PLANS FOR NEW CONDUIT LOCATIONS AND ROUTING ON BRIDGE TO SOURCE.
2. PROVIDE TEMPORARY ELECTRICAL SERVICE WHILE BRIDGE IS BEING REBUILT.
3. NEW COMED ELECTRICAL SERVICE ATTACHED TO STRUCTURE. SEE SINGLE LINE DIAGRAM ON SHEET 276 .
4. PROVIDE TEMPORARY POWER AS NEEDED FOR CONSTRUCTION.

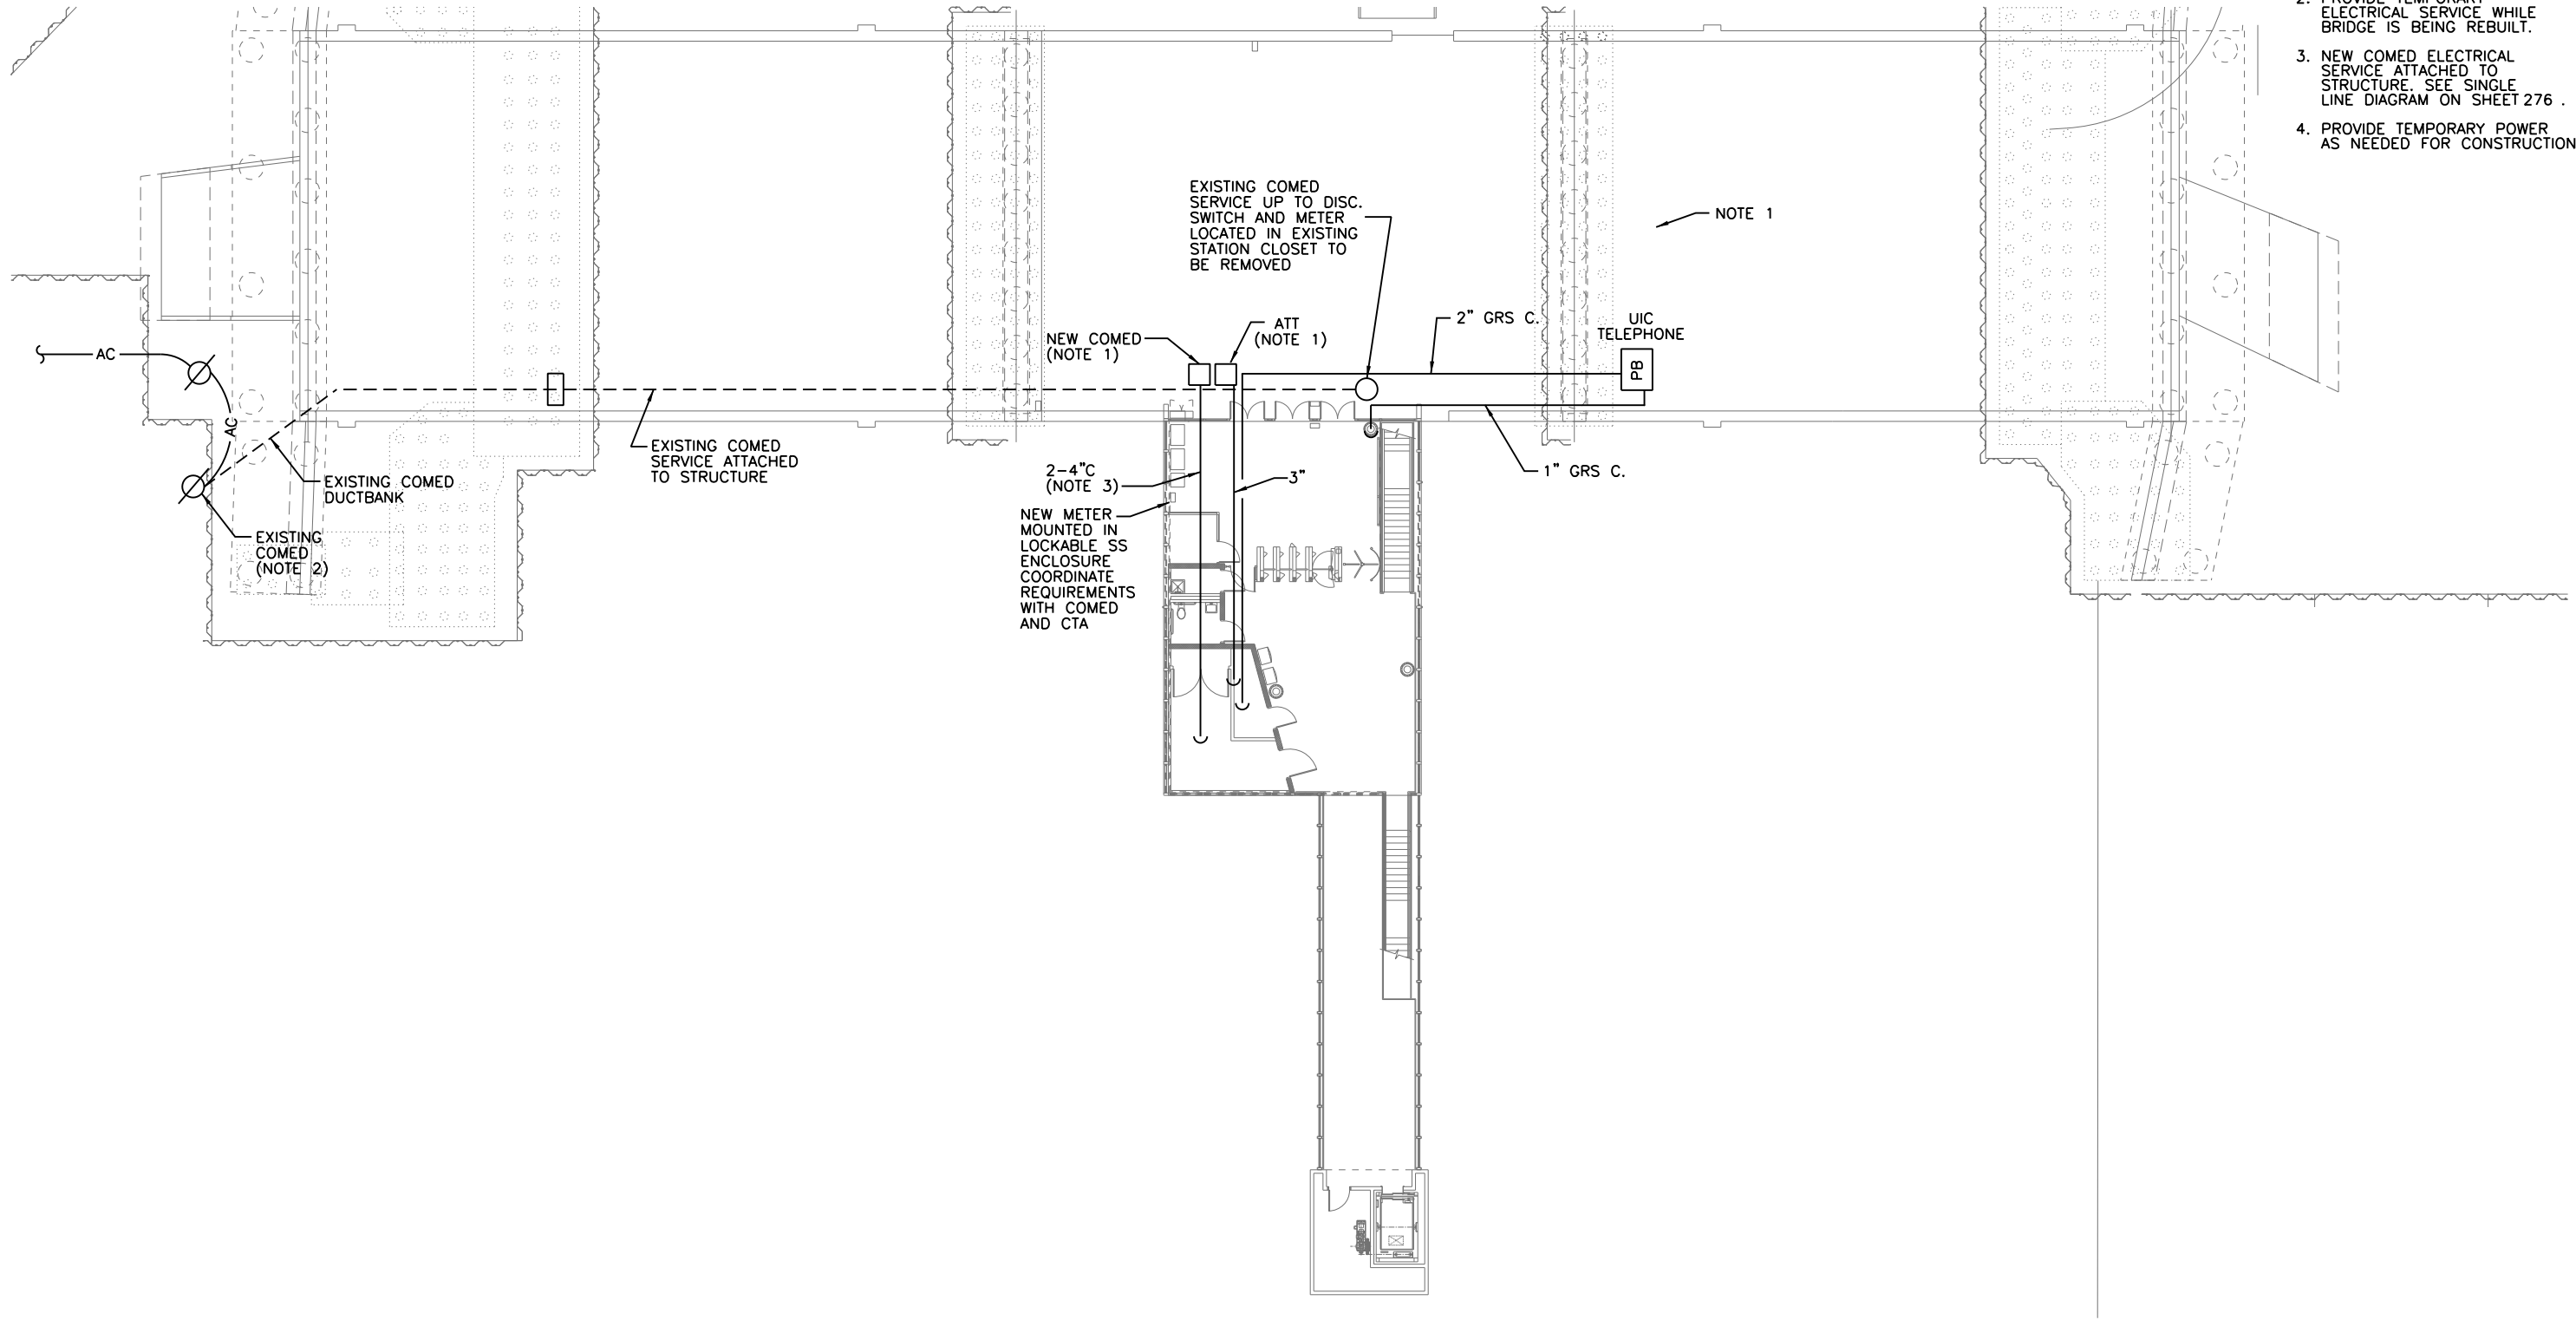

1 ELECTRICAL BRIDGE PLAN
SCALE: 1" = 1'-0"

AAA ENGINEERING
WBE/DBE CERTIFIED
5940 West Touhy Avenue, Suite 210, Niles, IL 60714
Phone: 847-647-9999 • Fax: 847-647-4719



USER NAME = habit	DESIGNED -	REVISED
	CHECKED -	REVISED
PLOT SCALE = 24:0 '1" / 1in.	DRAWN -	REVISED
PLOT DATE = 10/28/2013	CHECKED -	REVISED

**STATE OF ILLINOIS
DEPARTMENT OF TRANSPORTATION**

**PEORIA STREET STATION
ELECTRICAL BRIDGE DEMOLITION PLAN**

SHEET NO. 84 OF 117 SHEETS

PRELIMINARY NOT FOR CONSTRUCTION

MUN	SECTION	COUNTY	TOTAL SHEETS	SHEET NO.
2090	2013-011R	COOK	356	275
CONTRACT NO.			60W29	

ILLINOIS FED. AID PROJECT

7:58:22 PM 2/75-60W29.dgn