

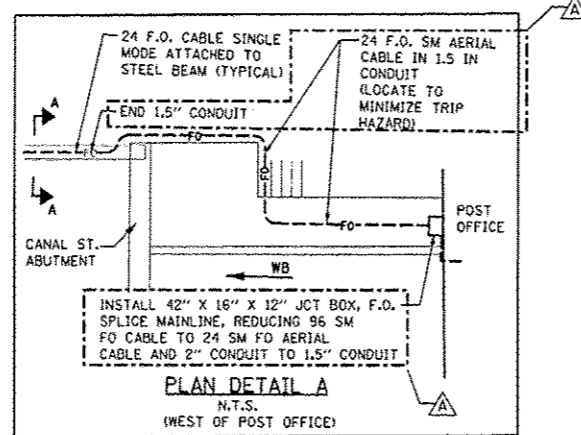
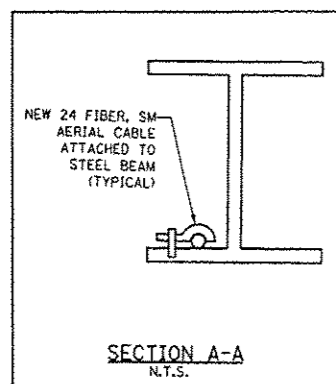


NOTES:


1. FOR GENERAL AND ELECTRICAL NOTES, SEE DWG'S 2, 3 & 4.
2. FOR ELECTRICAL SYMBOLS AND ABBREVIATIONS, SEE DWG. 5
3. FOR PANEL SCHEDULES, SEE DWG 22.
4. FOR EQUIPMENT DESCRIPTIONS SEE ELECTRICAL SPECIFICATIONS.
5. NO CONDUIT FOR AERIAL F.O. CABLE FROM DES PLAINES ST. AND TO CANAL ST.

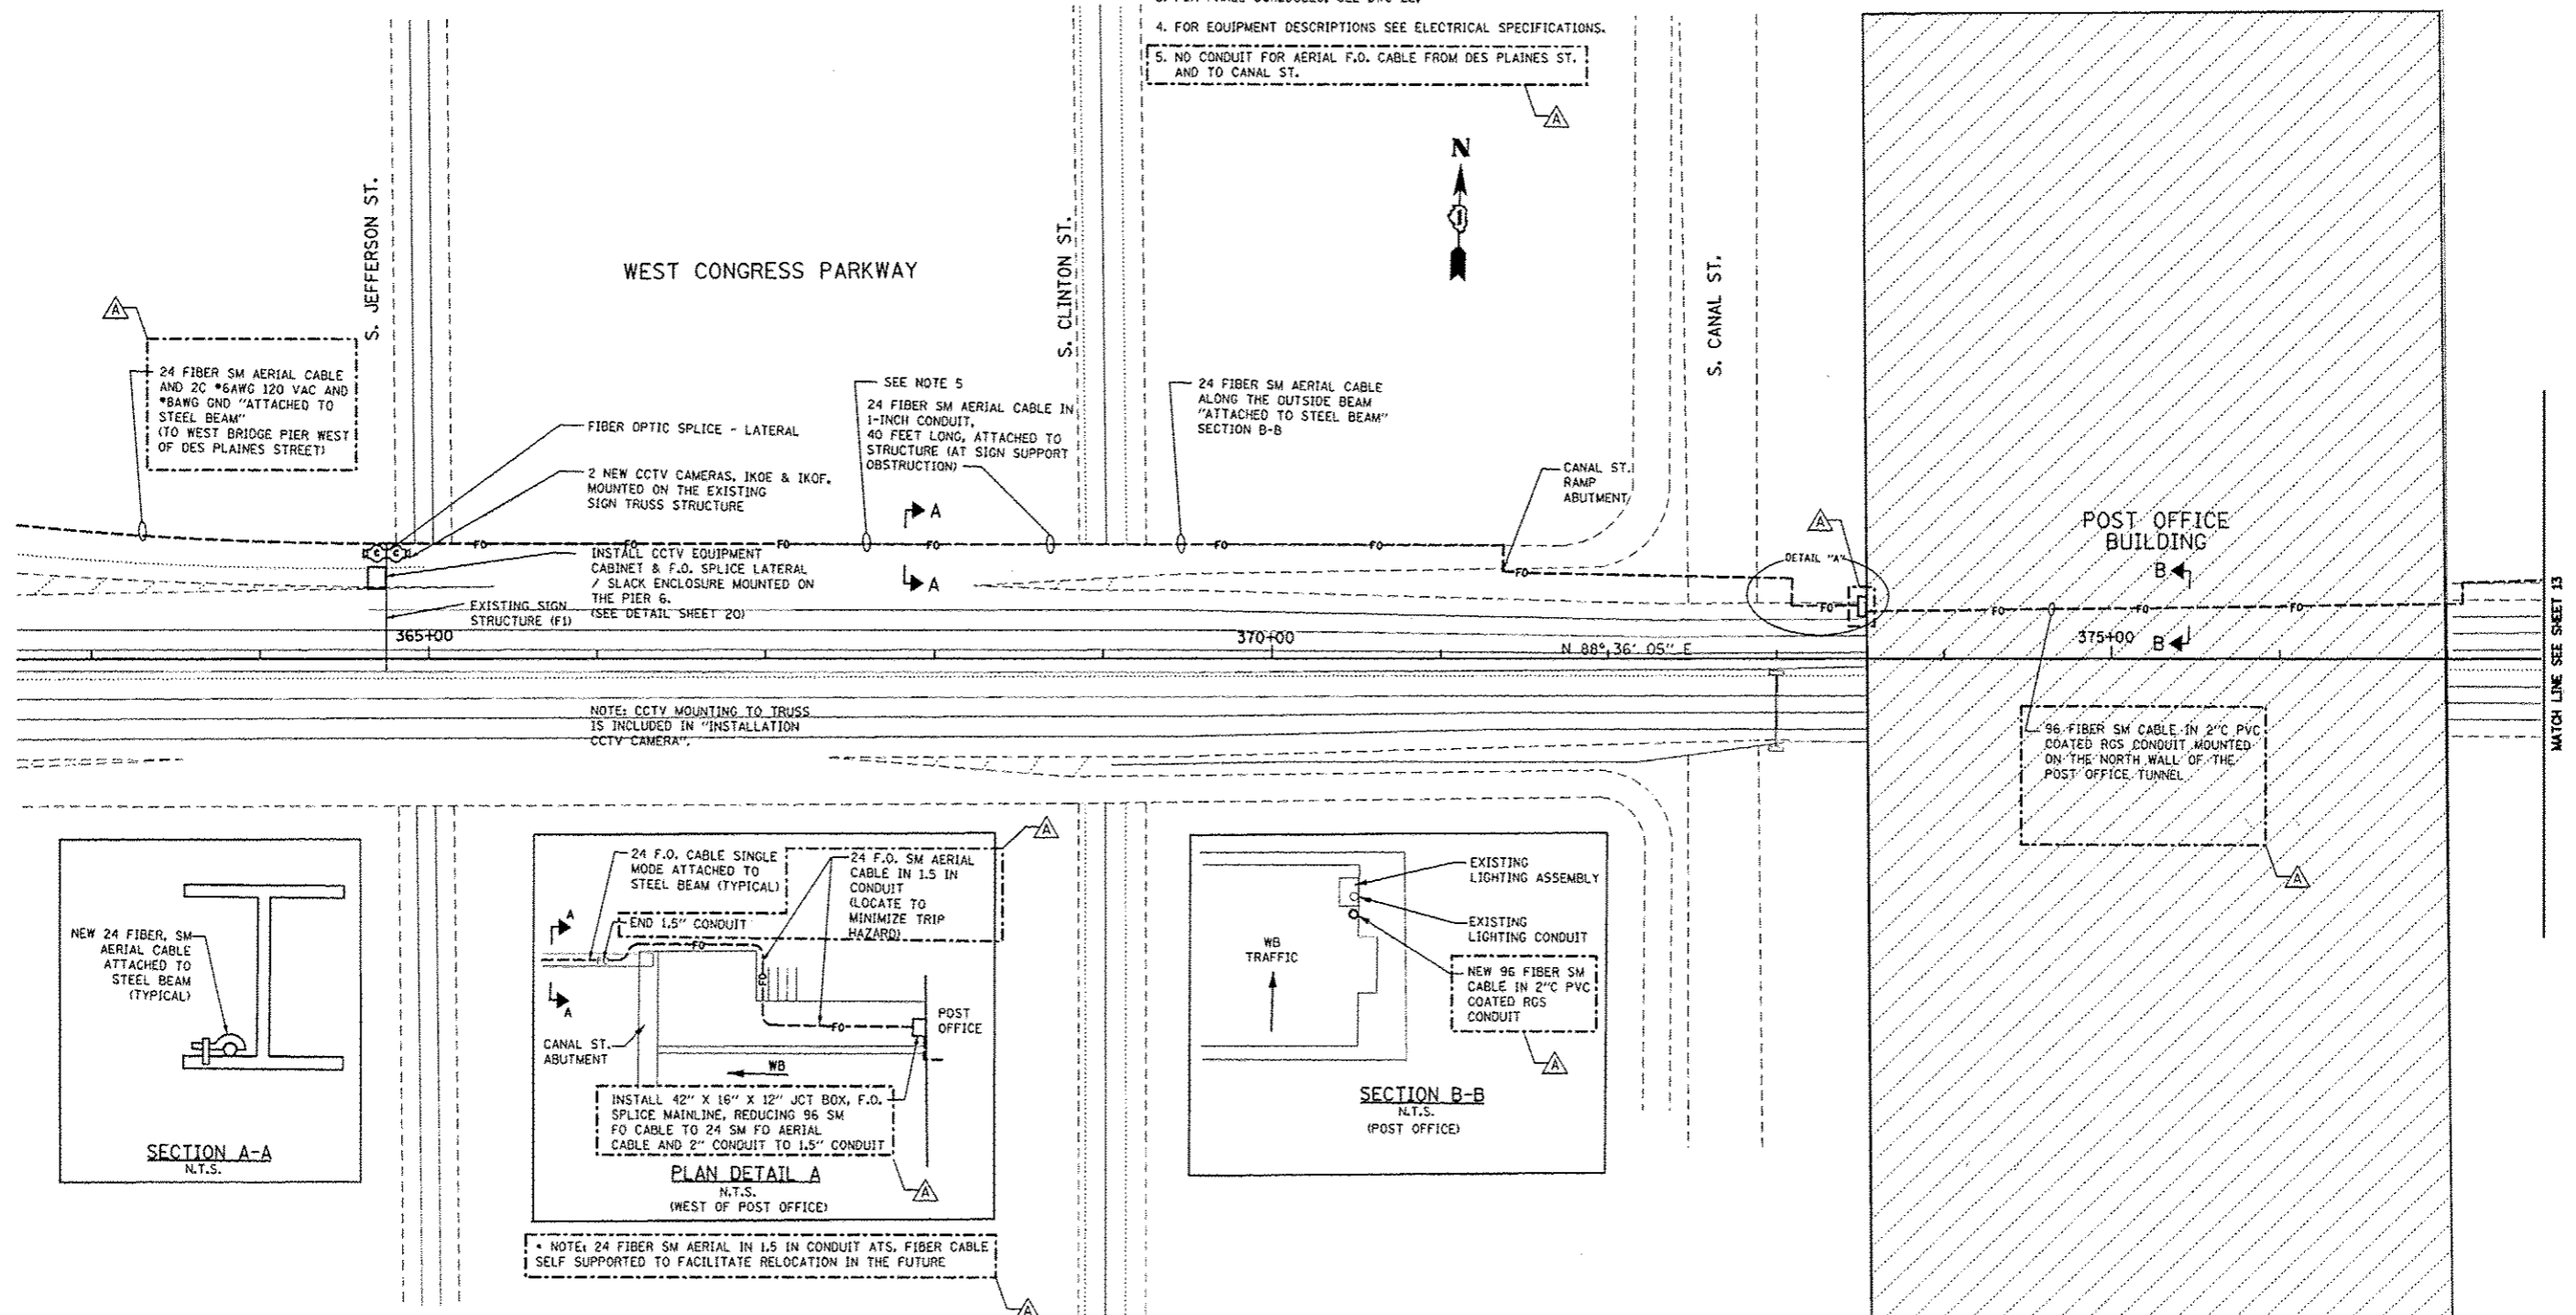

NOTE: 24 FIBER SM AERIAL IN 1.5 IN CONDUIT AT S, FIBER CABLE SELF SUPPORTED TO FACILITATE RELOCATION IN THE FUTURE

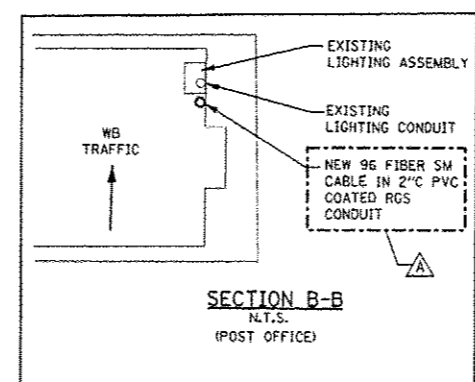

96 FIBER SM CABLE IN 2" PVC COATED RGS CONDUIT MOUNTED ON THE NORTH WALL OF THE POST OFFICE TUNNEL

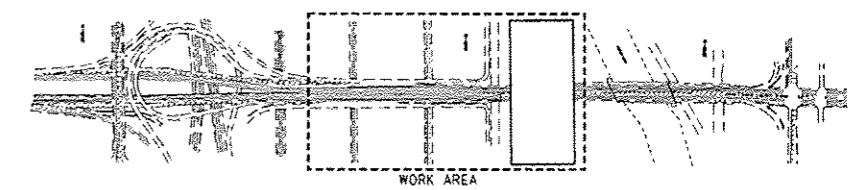

T:\168434\CCTVFiles from NY09-17-2013\168434-CCTV-E07-12-FO-Plan-2013-Rev10-17-2013.dgn 19-DEC-2013 18:15

PARSONS BRINCKERHOFF
230 West Monroe Street
Chicago, IL 60606

USER NAME: ppatld	DESIGNED: D. DRAKULICH	REVISED: 12/20/2013 D.C.P.
FILE NAME:	DRAWN: E. MALUSEL	REVISED:
PLOT SCALE: NONE	CHECKED: S. STERN	REVISED:
PLOT DATE: 10/16/2013	DATE: 10/16/2013	REVISED:

**STATE OF ILLINOIS
DEPARTMENT OF TRANSPORTATION**

**CCTV SYSTEM, I-90/94 TO CONGRESS PARKWAY
CCTV FIBER OPTIC PLAN SHEET 1 OF 2**

SCALE: AS SHOWN SHEET NO. OF SHEETS STA. 353+46.00 TO STA. 382+50.00

F.A.P. RTE. 389	SECTION 2013-026-1	COUNTY COOK	TOTAL SHEETS 37	SHEET NO. 12
CONTRACT NO. 60W49			ILLINOIS FED. AID PROJECT	