

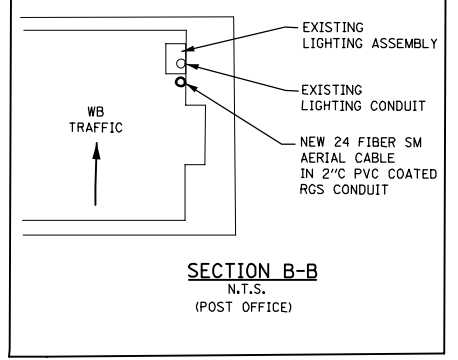
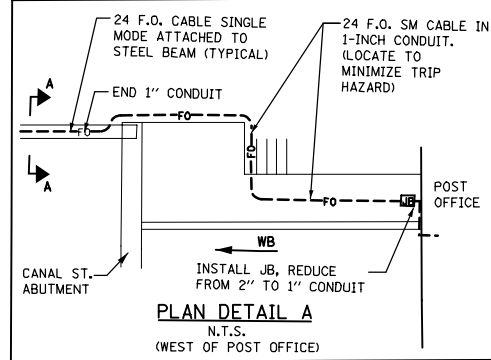
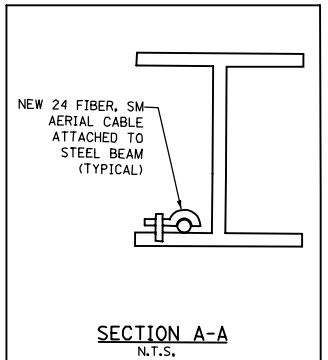


NOTES:

1. FOR GENERAL AND ELECTRICAL NOTES, SEE DWG'S 2, 3 & 4.
2. FOR ELECTRICAL SYMBOLS AND ABBREVIATIONS, SEE DWG. 5
3. FOR PANEL SCHEDULES, SEE DWG 22.
4. FOR EQUIPMENT DESCRIPTIONS SEE ELECTRICAL SPECIFICATIONS.
5. NO CONDUIT FOR AERIAL F.O. CABLE BETWEEN DES PLAINES ST. AND POST OFFICE.

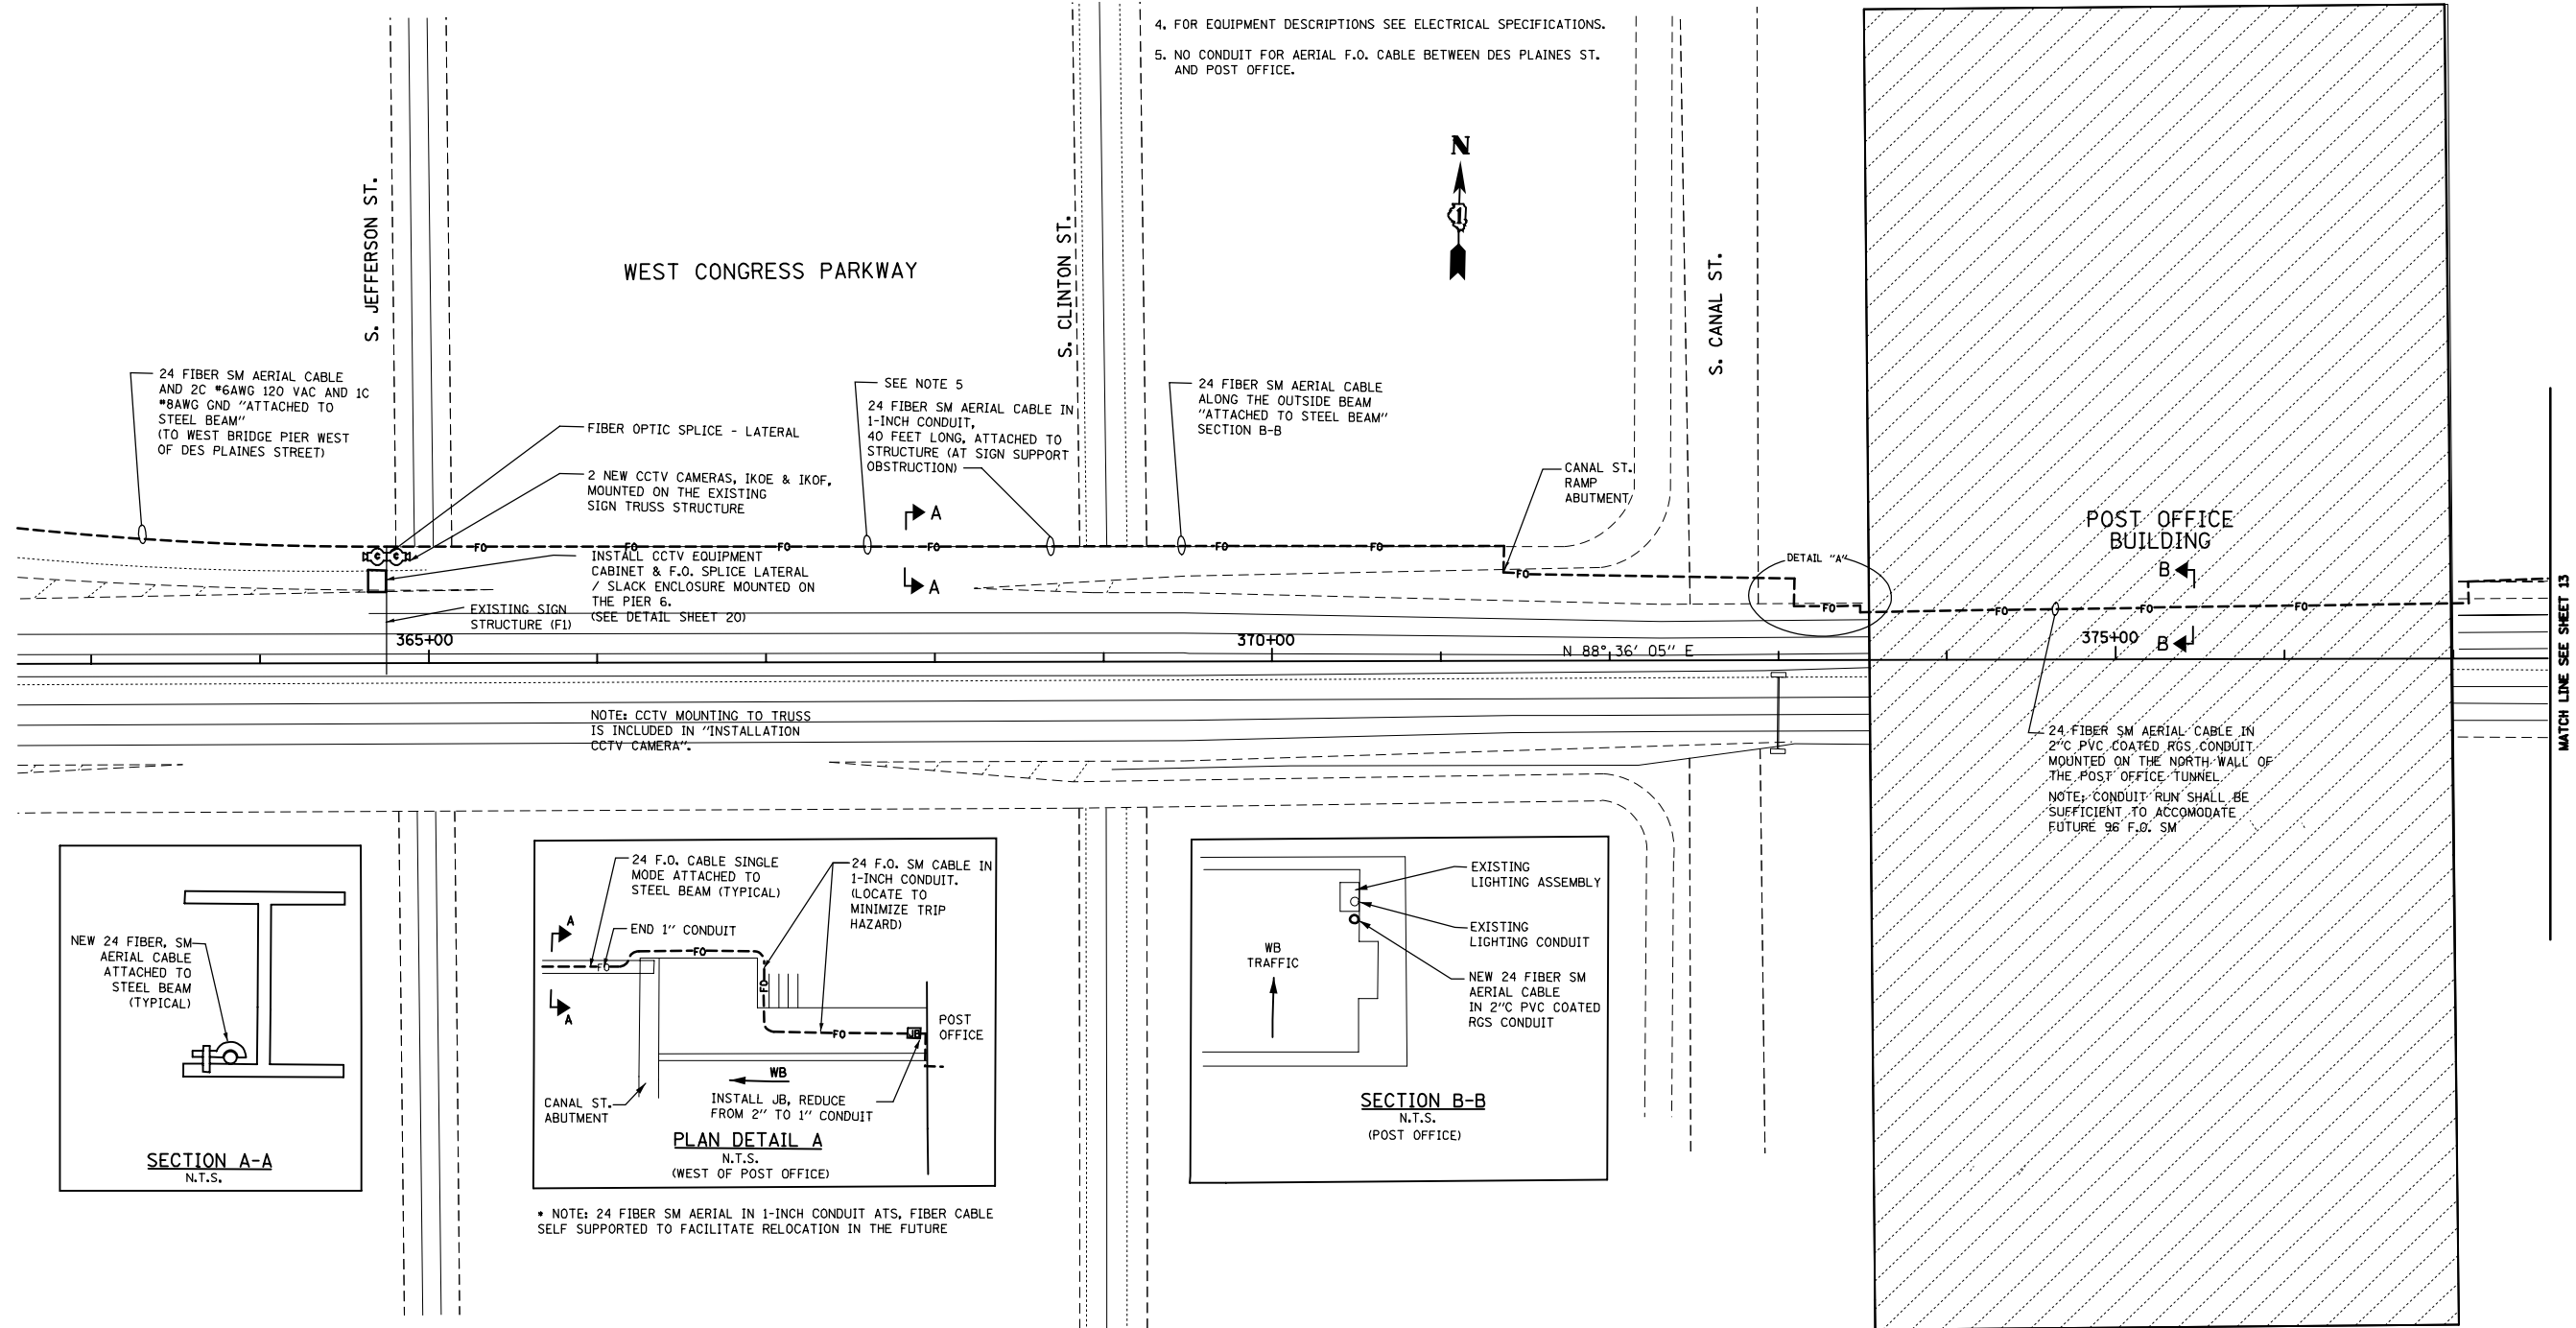

* NOTE: 24 FIBER SM AERIAL IN 1-INCH CONDUIT AT S, FIBER CABLE SELF SUPPORTED TO FACILITATE RELOCATION IN THE FUTURE

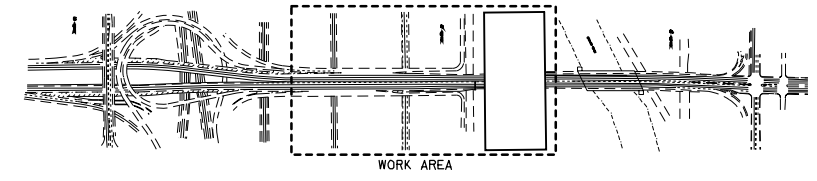

T:\16843A\CCTV\Files from NY\16843A-17-2013\16843A-CCTV-E07-12_FO-Plan-2of3_rev10-17-2013.dgn 28-OCT-2013 13:46

PARSONS BRINCKERHOFF
230 West Monroe Street
Suite 900
Chicago, IL 60609

USER NAME = pated	DESIGNED - D. DRAKULICH	REVISED -
FILE NAME	DRAWN - E. MALUSEL	REVISED -
PLOT SCALE = NONE	CHECKED - S. STERN	REVISED -
PLOT DATE = 10/18/2013	DATE - 10/18/2013	REVISED -

**STATE OF ILLINOIS
DEPARTMENT OF TRANSPORTATION**

**CCTV SYSTEM, I-90/94 TO CONGRESS PARKWAY
CCTV FIBER OPTIC PLAN SHEET 1 OF 2**
SCALE: AS SHOWN SHEET NO. OF SHEETS STA. 353+46.00 TO STA. 382+50.00

F.A.P. RTE.	SECTION	COUNTY	TOTAL SHEETS	SHEET NO.
389	2013-026-I	COOK	37	12
CONTRACT NO. 60W49			FED. ROAD DIST. NO. 1 (ILLINOIS) FED. AID PROJECT	