


F.A.I. RTE.	SECTION	COUNTY	TOTAL SHEETS	SHEET NO.
80	(50-5) HBK-2	LASALLE	331	29
STA. 413+00.00 TO STA. 421+15.21				
FED. ROAD DIST. NO.		ILLINOIS FED. AID PROJECT		

- NOTES:
- SEE LIGHTING PLANS FOR THE LOCATIONS OF TEMPORARY AND PROPOSED LIGHTING
 - SEE TYPICAL SECTIONS FOR PAVEMENT STRUCTURE.
 - SEE ROADWAY AND INTERSECTION DETAILS FOR MORE GEOMETRIC DETAIL.
 - SEE PAVEMENT JOINT AND ELEVATION PLAN FOR JOINTING AND ELEVATION DETAILS.
 - SEE DRAINAGE & UTILITY PLANS FOR REMOVAL OF STORM SEWER PIPE, STRUCTURES, AND RELATED WORK.
 - SEE TYP-05 FOR PCC PAVEMENT ADJACENT TO EXISTING I-80 PAVEMENT.

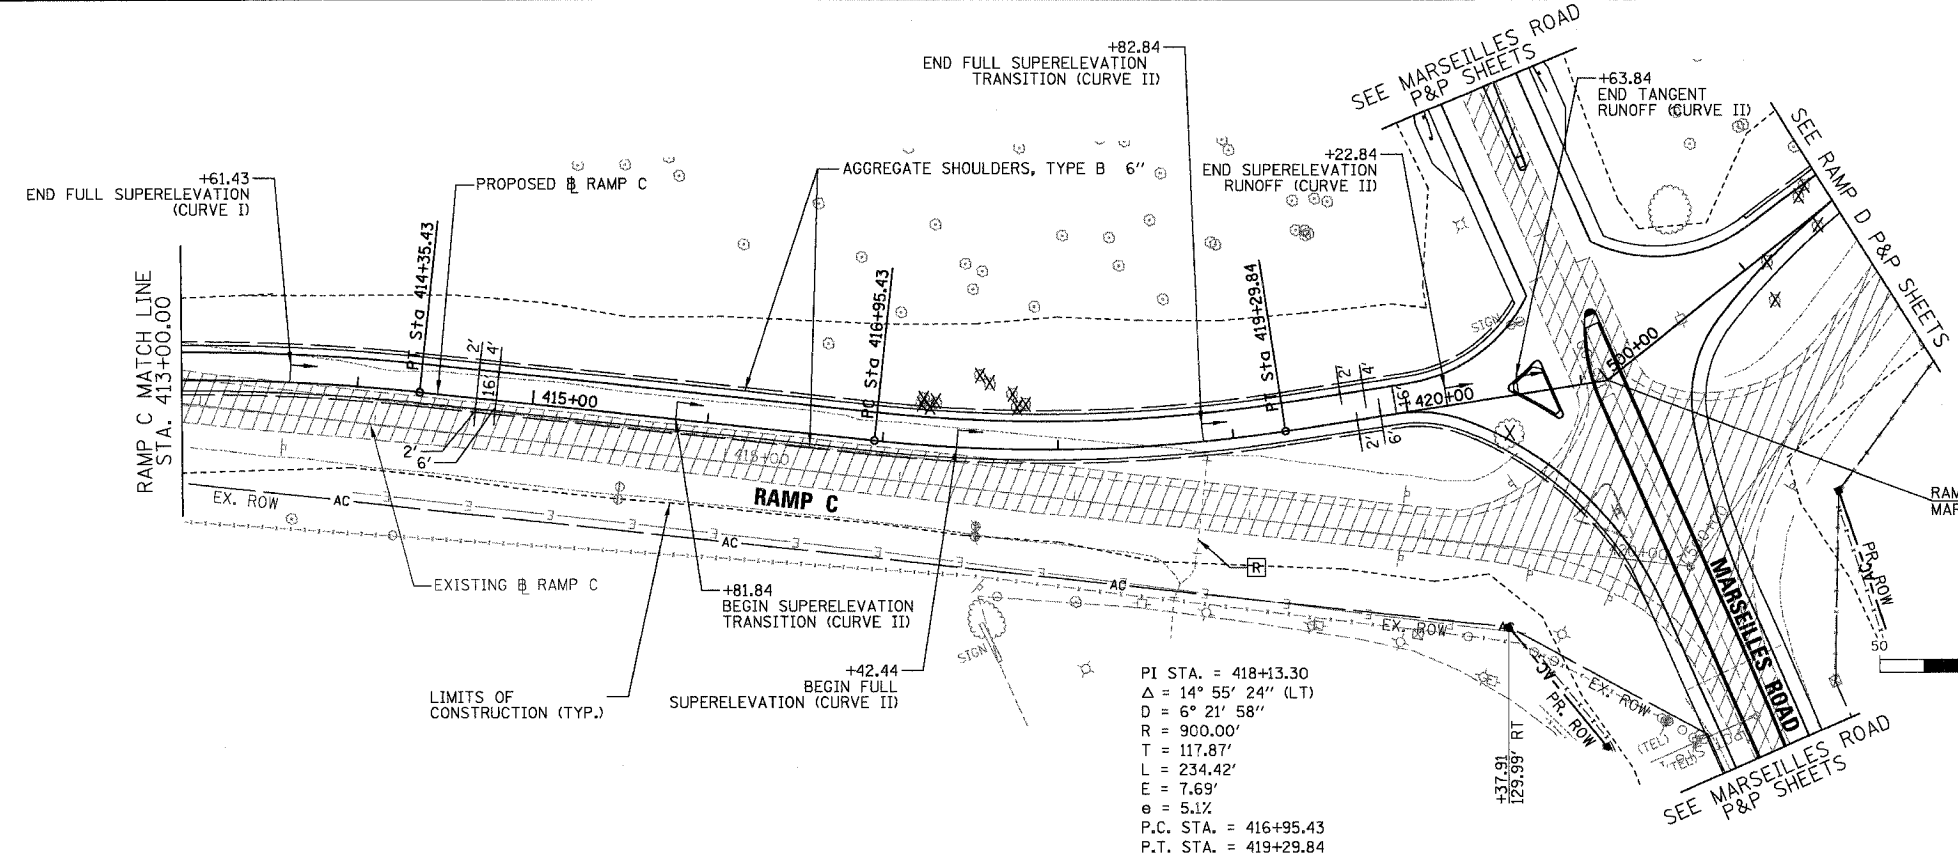


PI STA. = 418+13.30
 $\Delta = 14^\circ 55' 24''$ (LT)
 $D = 6^\circ 21' 58''$
 $R = 900.00'$
 $T = 117.87'$
 $L = 234.42'$
 $E = 7.69'$
 $e = 5.1\%$
 P.C. STA. = 416+95.43
 P.T. STA. = 419+29.84

- LEGEND
- R REMOVAL ITEMS
 - PAVEMENT & SHOULDER REMOVAL
 - DRIVEWAY PAVEMENT REMOVAL
 - TREE REMOVAL
 - PROPOSED A/C FENCE

DATE	BY	NO.

DATE	BY	NO.

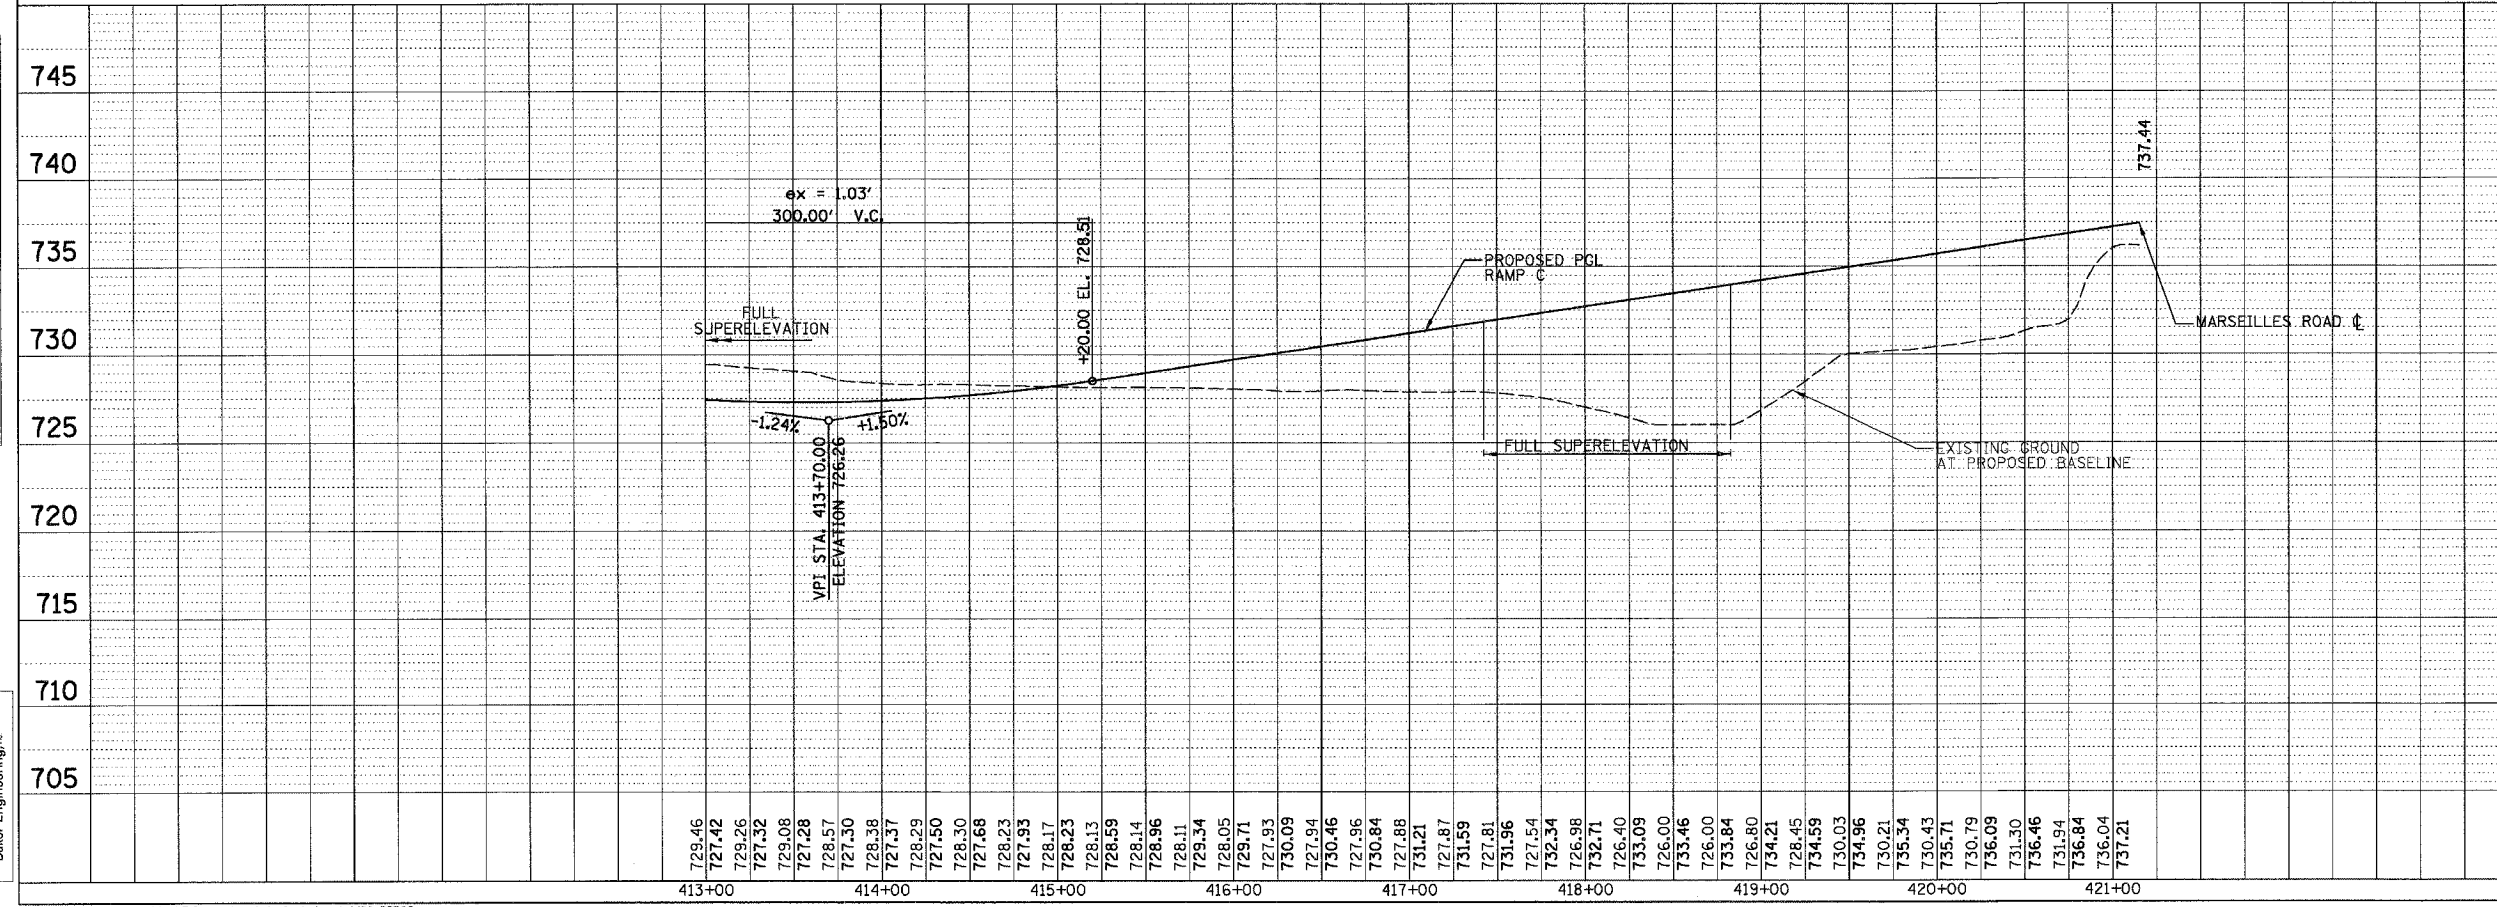

ILLINOIS DEPARTMENT OF TRANSPORTATION
 PLAN & PROFILE
 MARSEILLES ROAD RAMP C
 STA. 413+00.00 TO STA. 421+15.21

SCALE: HORIZ 1"=50'
 VERT 1"=5'

DATE: 11/02/07

DRAWN BY: KM
 CHECKED BY: SE

