
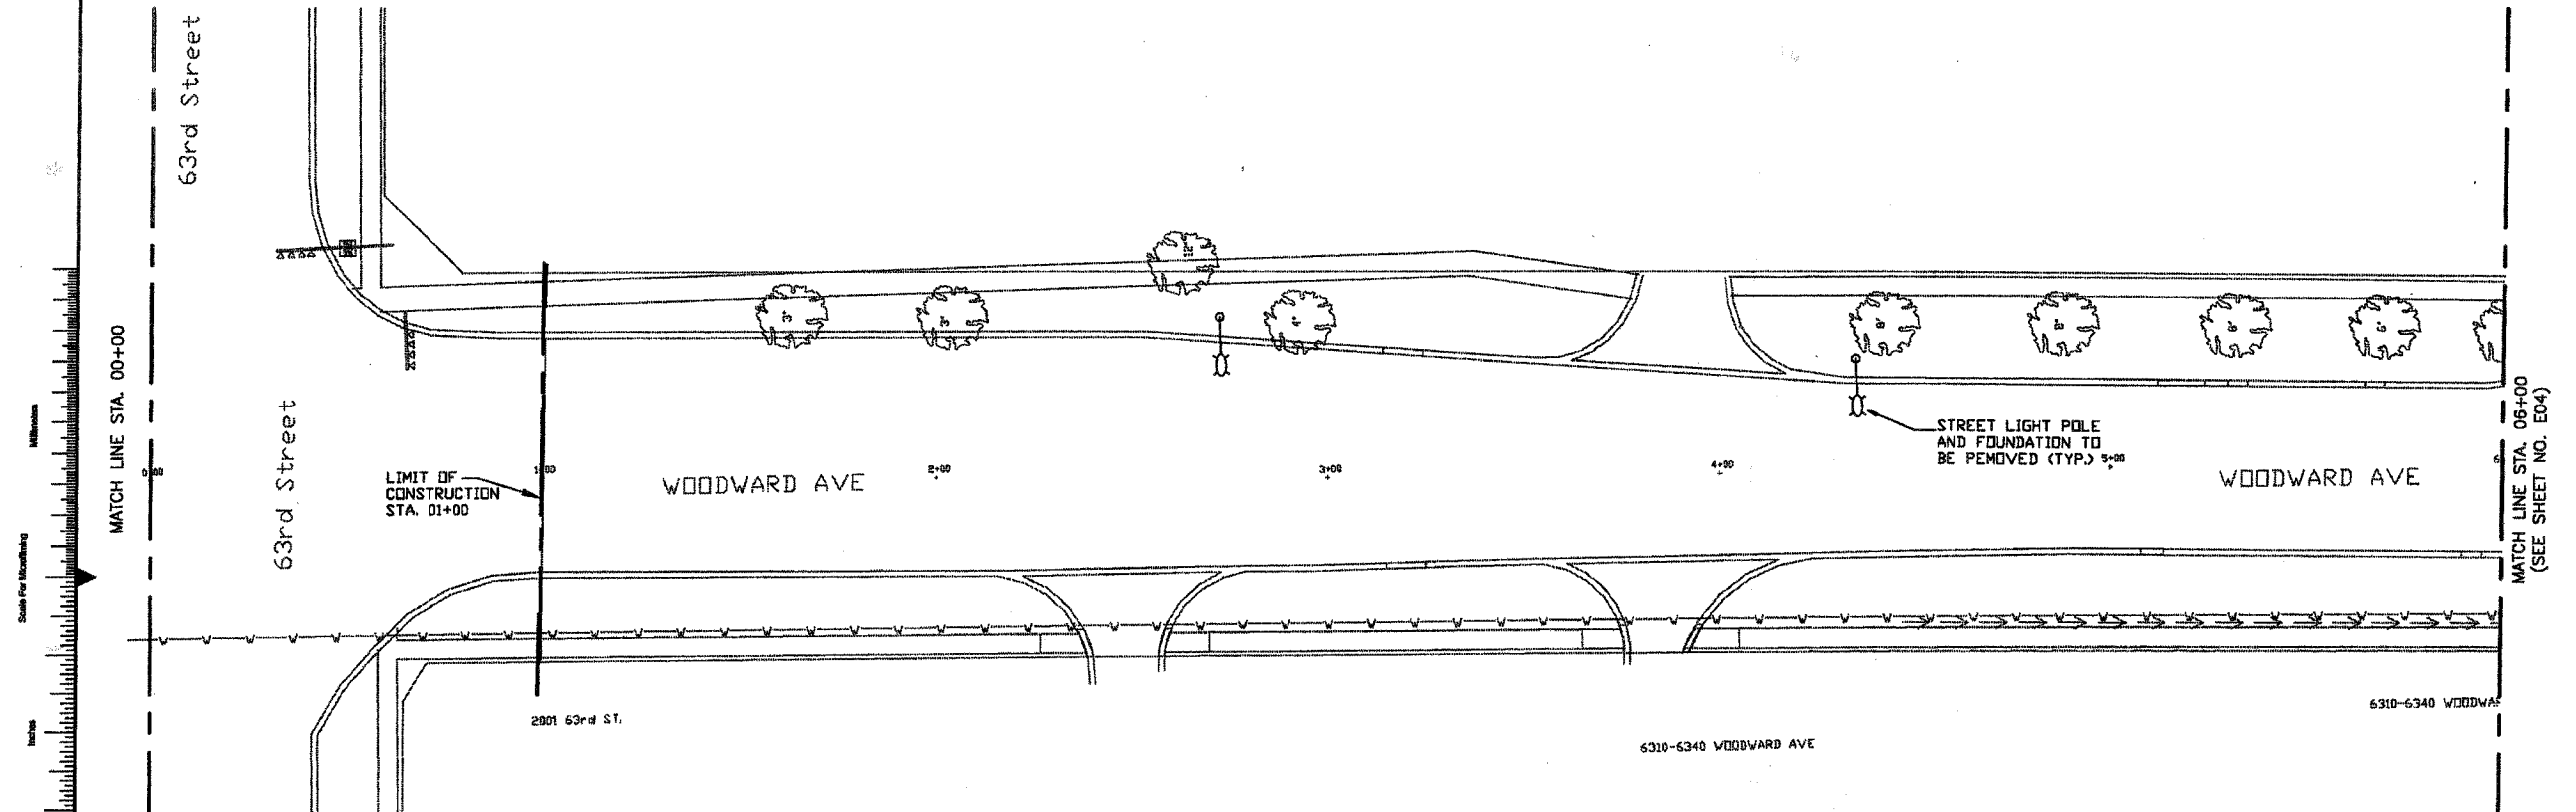


1 2 3 4 5 6 7 8 9 10 11 12 13 14

F.A.P. RTE.	SECTION	COUNTY	TOTAL SHEETS	SHEET NO.
2983	02-0082-00-WR	DU PAGE	49	29
FEDERAL RD. DIST. NO. 1	ILLINOIS	FEDERAL AID PROJECT		
CONTRACT	8593C			

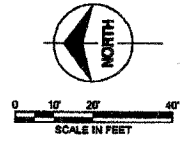

**PARTIAL WOODWARD AVENUE LIGHTING LAYOUT - EXISTING**  
SCALE AS NOTED

COPYRIGHT © 2007 BURNS AND MCDONNELL ENGINEERING COMPANY, INC.



*David E. Mertz*

date 04 / 10 / 2007	detailed BMH
designed FO	checked DEM
VILLAGE OF DOWNERS GROVE WOODWARD AVENUE LIGHTING LAYOUT STATION 00+00 TO STATION 06+00	
project 45190	contract
drawing <b>E03</b>	rev. <b>0</b>
sheet of sheets	
file I:\DOWNERS...45190\CAD\ E03	