
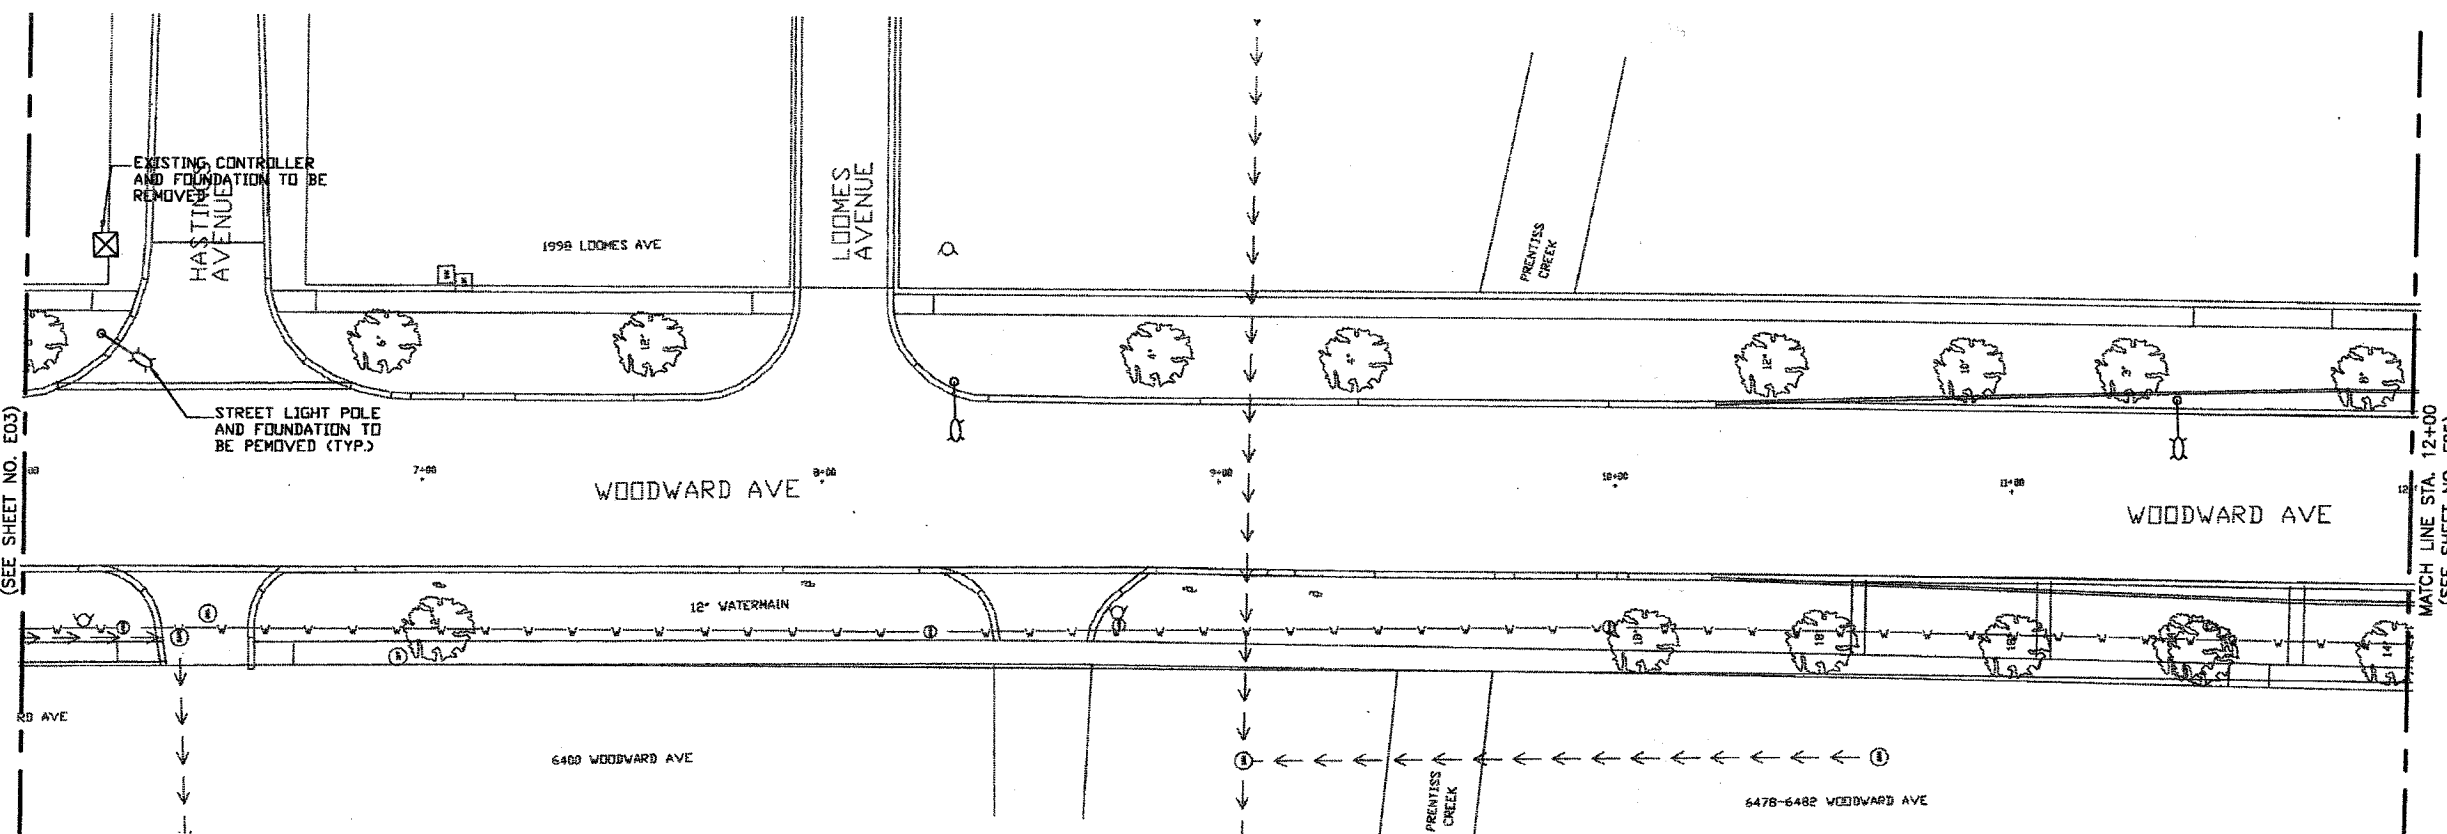


1 2 3 4 5 6 7 8 9 10 11 12 13 14

F.A.P. RTE	SECTION	COUNTY	TOTAL SHEETS	SHEET NO.
2583	02-0002-00-WR	DU PAGE	49	307
FEDERAL RD. DIST. NO. 1		ILLINOIS	FEDERAL AID PROJECT	
CONTRACT: B 3336				

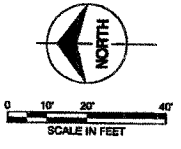

**PARTIAL WOODWARD AVENUE LIGHTING LAYOUT - EXISTING**  
SCALE AS NOTED

COPYRIGHT © 2007 BURNS AND MCDONNELL ENGINEERING COMPANY, INC.



*David E. Mertz*

<b>Burns &amp; McDonnell</b>	
date 04 / 10 / 2007	detailed BMH
designed FO	checked DEM
<b>Village of Downers Grove</b> FOUNDED IN 1837	
VILLAGE OF DOWNERS GROVE WOODWARD AVENUE LIGHTING LAYOUT STATION 06+00 TO STATION 12+00	
project 45190	contract
drawing <b>E04</b>	rev. <b>- 0</b>
sheet of sheets	
file I:\DOWNERS...V5190\CAD\ E04	