
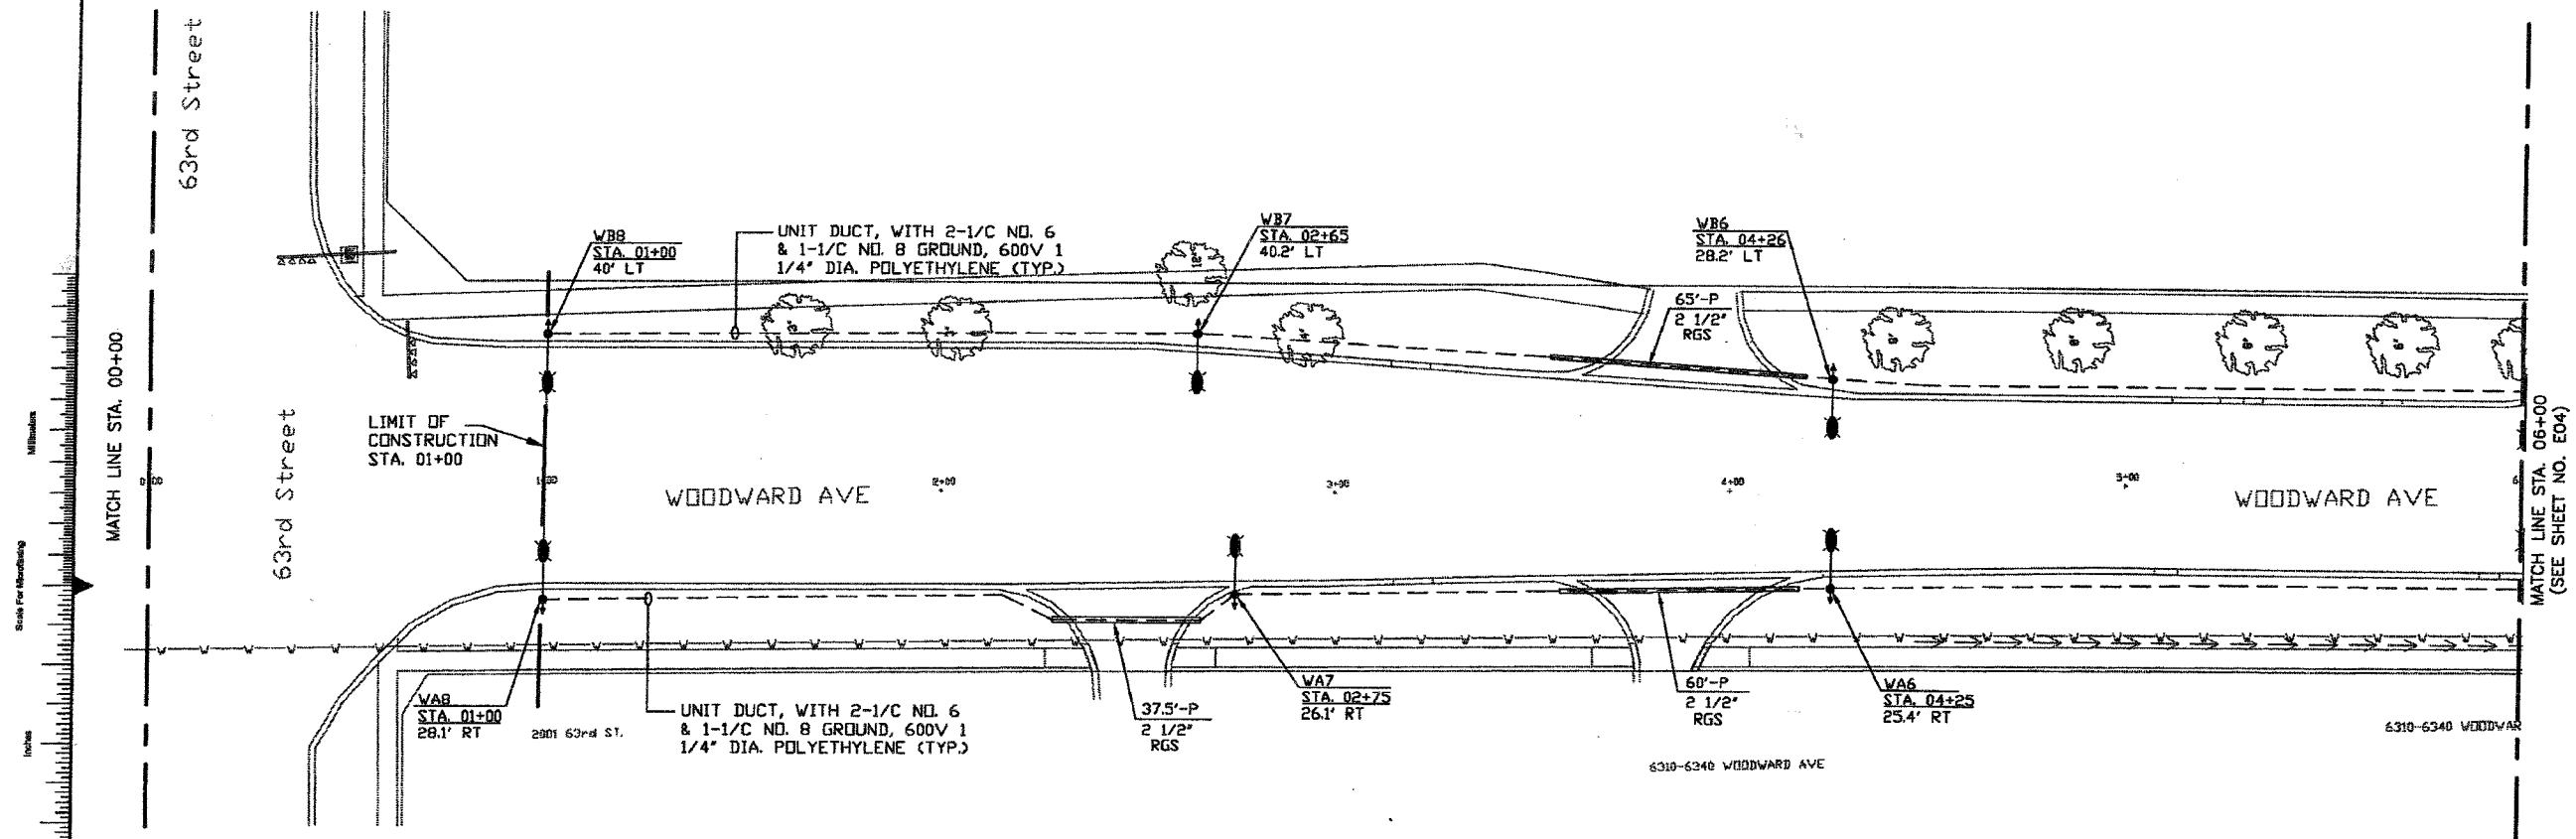


1 2 3 4 5 6 7 8 9 10 11 12 13 14

F.A.P. RTE.	SECTION	COUNTY	TOTAL SHEETS	SHEET NO.
2983	02-00092-00-WR	DU PAGE	49	34
FEDERAL RD. DIST. NO. 1   ILLINOIS   FEDERAL AID PROJECT				
CONTRACT: 8 5736				

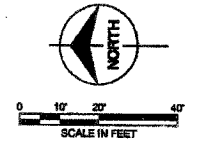

**PARTIAL WOODWARD AVENUE LIGHTING LAYOUT - PROPOSED PLAN**  
SCALE AS NOTED

Scale For Mounting  
Millimeter  
Inches

COPYRIGHT © 2007 BURNS AND MCDONNELL ENGINEERING COMPANY, INC.



*David E. Mertz*

date 04 / 10 / 2007	detailed BMH
designed FO	checked DEM
VILLAGE OF DOWNERS GROVE WOODWARD AVENUE LIGHTING LAYOUT STATION 00+00 TO STATION 06+00	
project 45190	contract
drawing <b>E08</b>	rev. <b>0</b>
sheet of sheets	
file: \DOWNERS...M5190\CAD\ E08	