
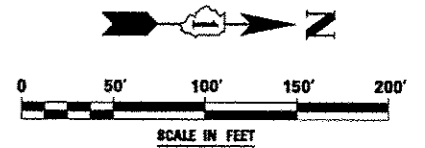


NOTES:

1. ALL LIGHTING POLES AND WIRING SHALL BE INSTALLED AND POWERED UNDER CONTRACT 60I31.
2. FOR SYMBOL LIST AND GENERAL ELECTRICAL NOTES, SEE SHEET LT-01.
3. NOT USED.
4. UNIT DUCT, 600V, 3-1C NO. 4, 1/C NO.6 GROUND, (XLP-TYPE USE), 1 1/4" DIA. POLYETHYLENE.
5. LIGHTING/WIRING SHALL BE INSTALLED UNDER CONTRACT 60R31.
6. POLE SETBACK SHALL BE MEASURED FROM THE **BACK** OF CURB TO THE CENTER OF THE POLE.
7. INSTALL AND CAP CONDUIT ELBOW IN FOUNDATION FOR FUTURE CONNECTION TO THE INTERSECTION LIGHTING.

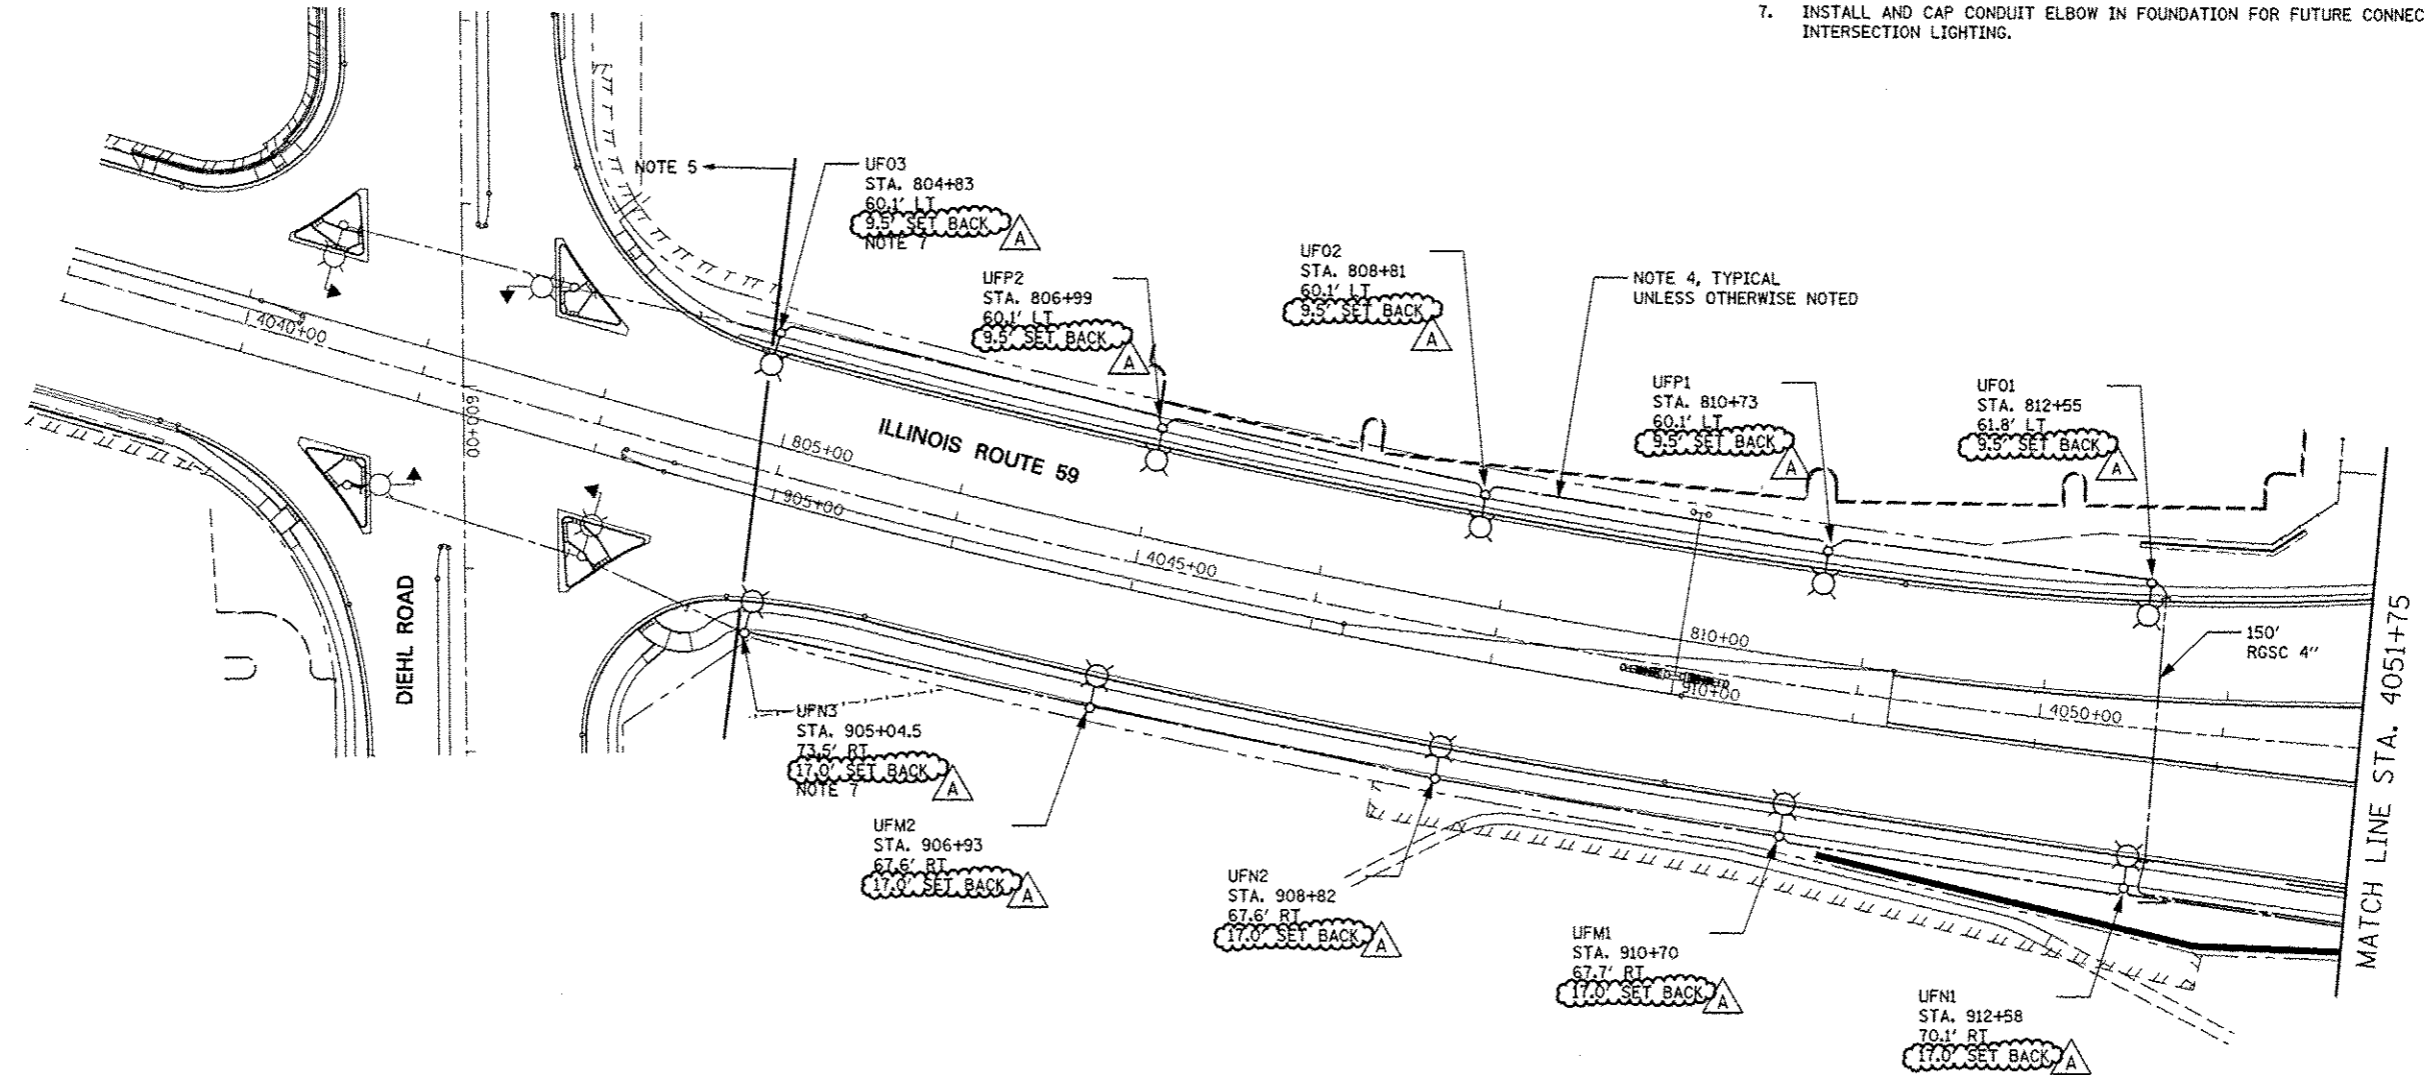

FILE NAME :	USER NAME : *USER*	DESIGNED MCP	REVISED ADDENDUM A 12/17/2012	STATE OF ILLINOIS DEPARTMENT OF TRANSPORTATION	IDOT LIGHTING PLAN - ILLINOIS ROUTE 59			F.A.P. RTE.	SECTION	COUNTY	TOTAL SHEETS	SHEET NO.
*FILE#		DRAWN MLB	REVISED -		338	(112 & 113) WRS-5	DUPAGE	963	558			
		CHECKED MCP	REVISED -		SCALE: AS SHOWN SHEET NO. 1 OF 2 SHEETS STA. 4039+00 TO STA. 4051+75			LT-03		CONTRACT NO. 60I31		
		DATE 10/15/2012	REVISED -		ILLINOIS FED. AID PROJECT							