
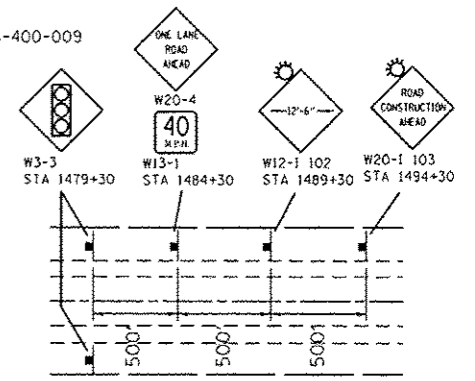


**SYMBOL LEGEND**

- WORK AREA
- SIGN
- TYPE III BARRICADE
- TRAFFIC SIGNAL
- IMPACT ATTENUATOR
- DRUM WITH STEADY BURNING BI-DIRECTIONAL LIGHT
- TEMPORARY CONCRETE BARRIER
- CRYSTAL, BI-DIRECTIONAL BARRIER WALL/GUARDRAIL MARKER
- DOUBLE VERTICAL PANEL, W/ STEADY BURNING BI-DIRECTIONAL LIGHT
- TEMPORARY PAVEMENT

NOTE:  
TRAFFIC CONTROL SHALL BE ERECTED AS SHOWN AND ACCORDING TO "TRAFFIC CONTROL AND PROTECTION, STANDARD 701321".  
SEE TEMPORARY TRAFFIC SIGNAL AND LIGHTING PLAN FOR STAGE 1.

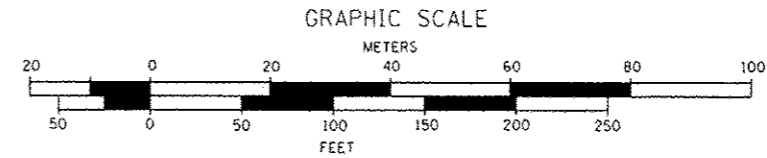

<b>ROBERT E. HAMILTON</b> CONSULTING ENGINEERS, INC. Engineers - Surveyors - Planners Joliet, Illinois (815) 730-3444	USER NAME: rmann	DESIGNED: JTS	REVISED: 10-8-2012	<b>STATE OF ILLINOIS</b> <b>DEPARTMENT OF TRANSPORTATION</b>	<b>IL ROUTE 77 OVER VIRGIL DITCH #2</b> <b>SUGGESTED STAGE OF CONSTRUCTION &amp; TRAFFIC CONTROL - STAGE 1</b>			F.A.P. RTE.: 326	SECTION: 106X-B	COUNTY: KANE	TOTAL SHEETS: 87	SHEET NO.: 16
	PLOT SCALE: 1/8" = 100'	CHECKED: JAR	REVISED:		SCALE: 1" = 50'	SHEET NO. OF SHEETS:	STA. TO STA.:	FED. ROAD DIST. NO.:	ILLINOIS FED. AID PROJECT:	CONTRACT NO. 60N13		
	PLOT DATE: 12/5/2012	DATE: 8-23-2011	REVISED:									

Rev. sheet 1-3-13