


SYMBOL LEGEND

- WORK AREA
- SIGN
- TYPE III BARRICADE
- TRAFFIC SIGNAL
- IMPACT ATTENUATOR
- DRUM WITH STEADY BURNING BI-DIRECTIONAL LIGHT
- TEMPORARY CONCRETE BARRIER
- CRYSTAL, BI-DIRECTIONAL BARRIER WALL/GUARDRAIL MARKER
- DOUBLE VERTICAL PANEL, W/ STEADY BURNING BI-DIRECTIONAL LIGHT
- TEMPORARY PAVEMENT

NOTE:
TRAFFIC CONTROL SHALL BE ERECTED AS SHOWN AND ACCORDING TO "TRAFFIC CONTROL AND PROTECTION, STANDARD 701321".
SEE TEMPORARY TRAFFIC SIGNAL AND LIGHTING PLAN FOR STAGE 1.

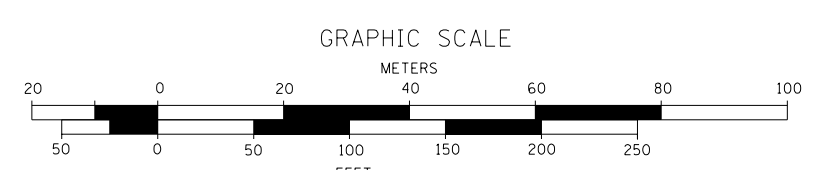

| | | | | | | | | | | | |
|---|-------------------|----------------|---------------------|---|---|-----------------|---|-------------|--------------------|--------------|--|
| FILE NAME = D160N13-sht-staging1.dgn | USER NAME = mmann | DESIGNED - JTS | REVISED - 10-8-2012 | STATE OF ILLINOIS DEPARTMENT OF TRANSPORTATION | IL ROUTE 77 OVER VIRGIL DITCH #2 SUGGESTED STAGE OF CONSTRUCTION & TRAFFIC CONTROL - STAGE 1 | F.A.P. RTE. 326 | SECTION 106X-8 | COUNTY KANE | TOTAL SHEETS 87 | SHEET NO. 16 | |
| PLOT SCALE = 100.0000' / in. | | | | | SCALE: 1"=50' | | SHEET NO. OF SHEETS STA. TO STA. | | CONTRACT NO. 60N13 | | |
| PLOT DATE = 10/24/2012 | | | | | DATE = 8-23-2011 | | FED. ROAD DIST. NO. ILLINOIS FED. AID PROJECT | | | | |