


NOTES


1. QUANTITY OF TRENCH BACKFILL FOR STORM SEWER REMOVAL IS PROVIDED IN SCHEDULE AFTER LENGTH OF PIPE REMOVED. TRENCH BACKFILL QUANTITY BASED ON LENGTH OF PIPE REMOVED. IF EXISTING STORM SEWER IS REMOVED AND REPLACED, TRENCH BACKFILL WILL BE PROVIDED FOR PROPOSED STORM SEWER ONLY
2. SEE PAVEMENT MARKING AND SIGNING PLANS, LIGHTING PLANS, AND TRAFFIC SIGNAL PLANS FOR ADDITIONAL REMOVALS NOT SHOWN ON THIS SHEET.
3. REMOVAL AND DISPOSAL OF EXISTING SHOULDER STABILIZATION UNDER EXISTING GUARDRAIL SHALL NOT BE MEASURED FOR PAYMENT BUT SHALL BE INCLUDED IN THE COST OF SHOULDER REMOVAL.

GUARDRAIL REMOVAL STA 124+00.00 TO STA 138+00.00

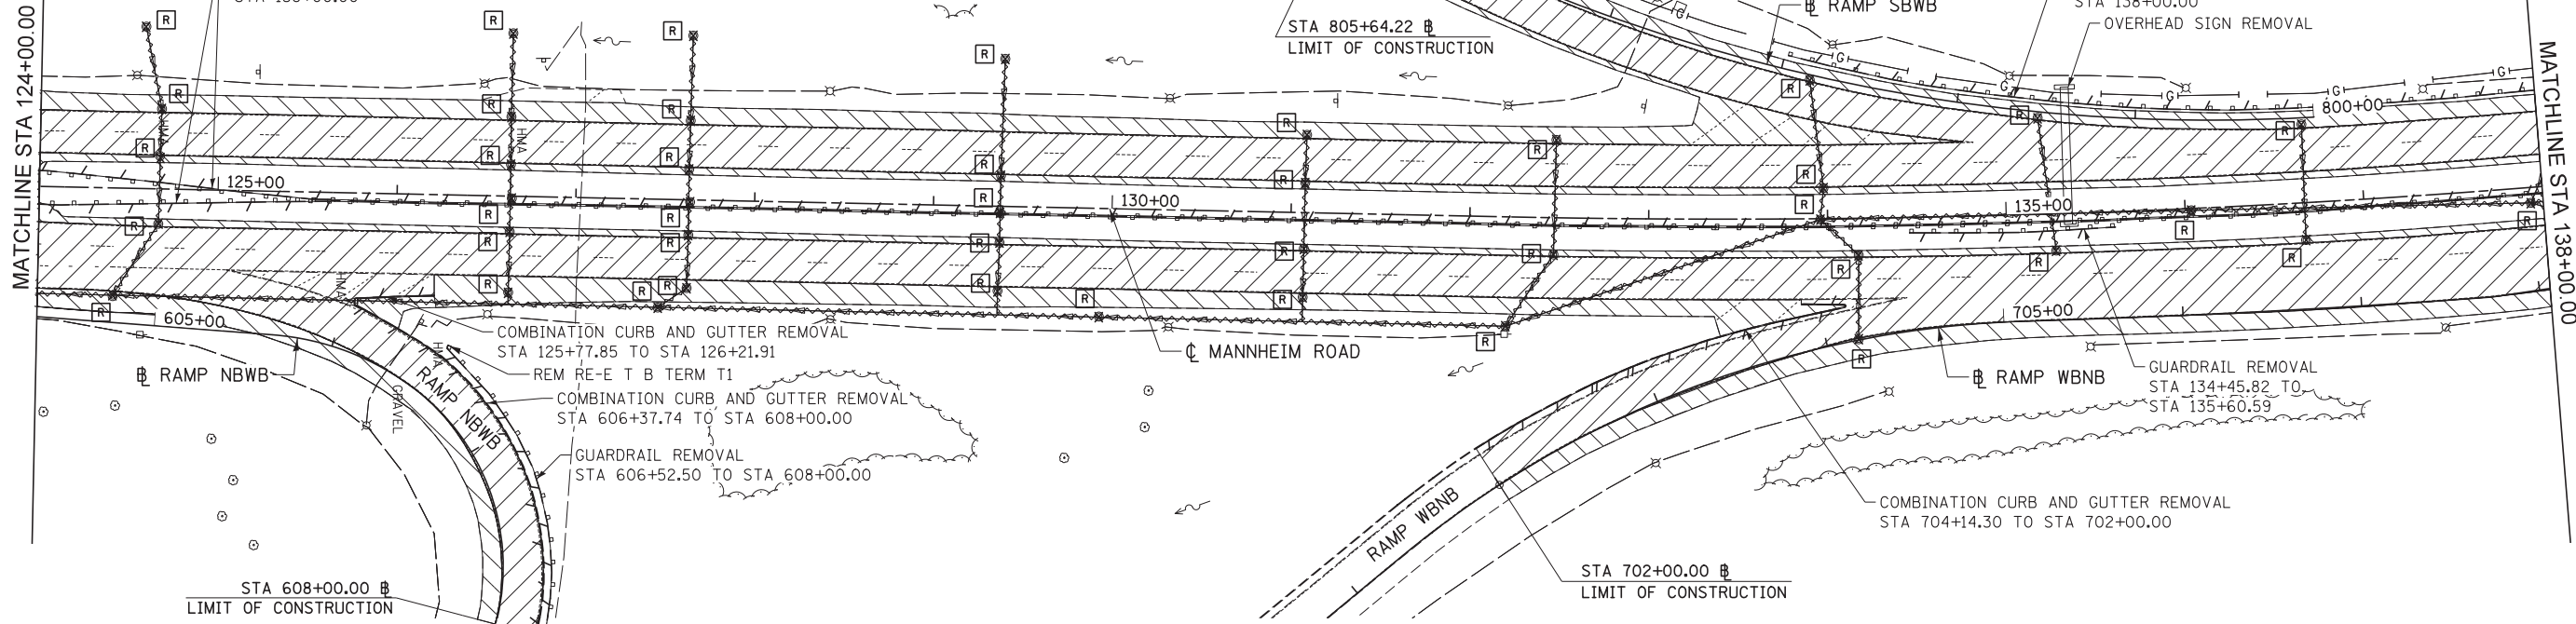

REMOVAL LEGEND

- | | | |
|-------------------------|-------------------------|------------------------------|
| PAVEMENT REMOVAL | CONCRETE MEDIAN REMOVAL | DRAINAGE STR. ADJUSTMENT |
| SHOULDER REMOVAL | PAVED DITCH REMOVAL | DRAINAGE STR. REMOVAL |
| DRIVEWAY REMOVAL | LINEAR ITEM REMOVAL | DRAINAGE STR. RECONSTRUCTION |
| SIDEWALK REMOVAL | ITEM REMOVAL | STORM SEWER REMOVAL |
| HMA SURFACE REMOVAL, 4" | | |

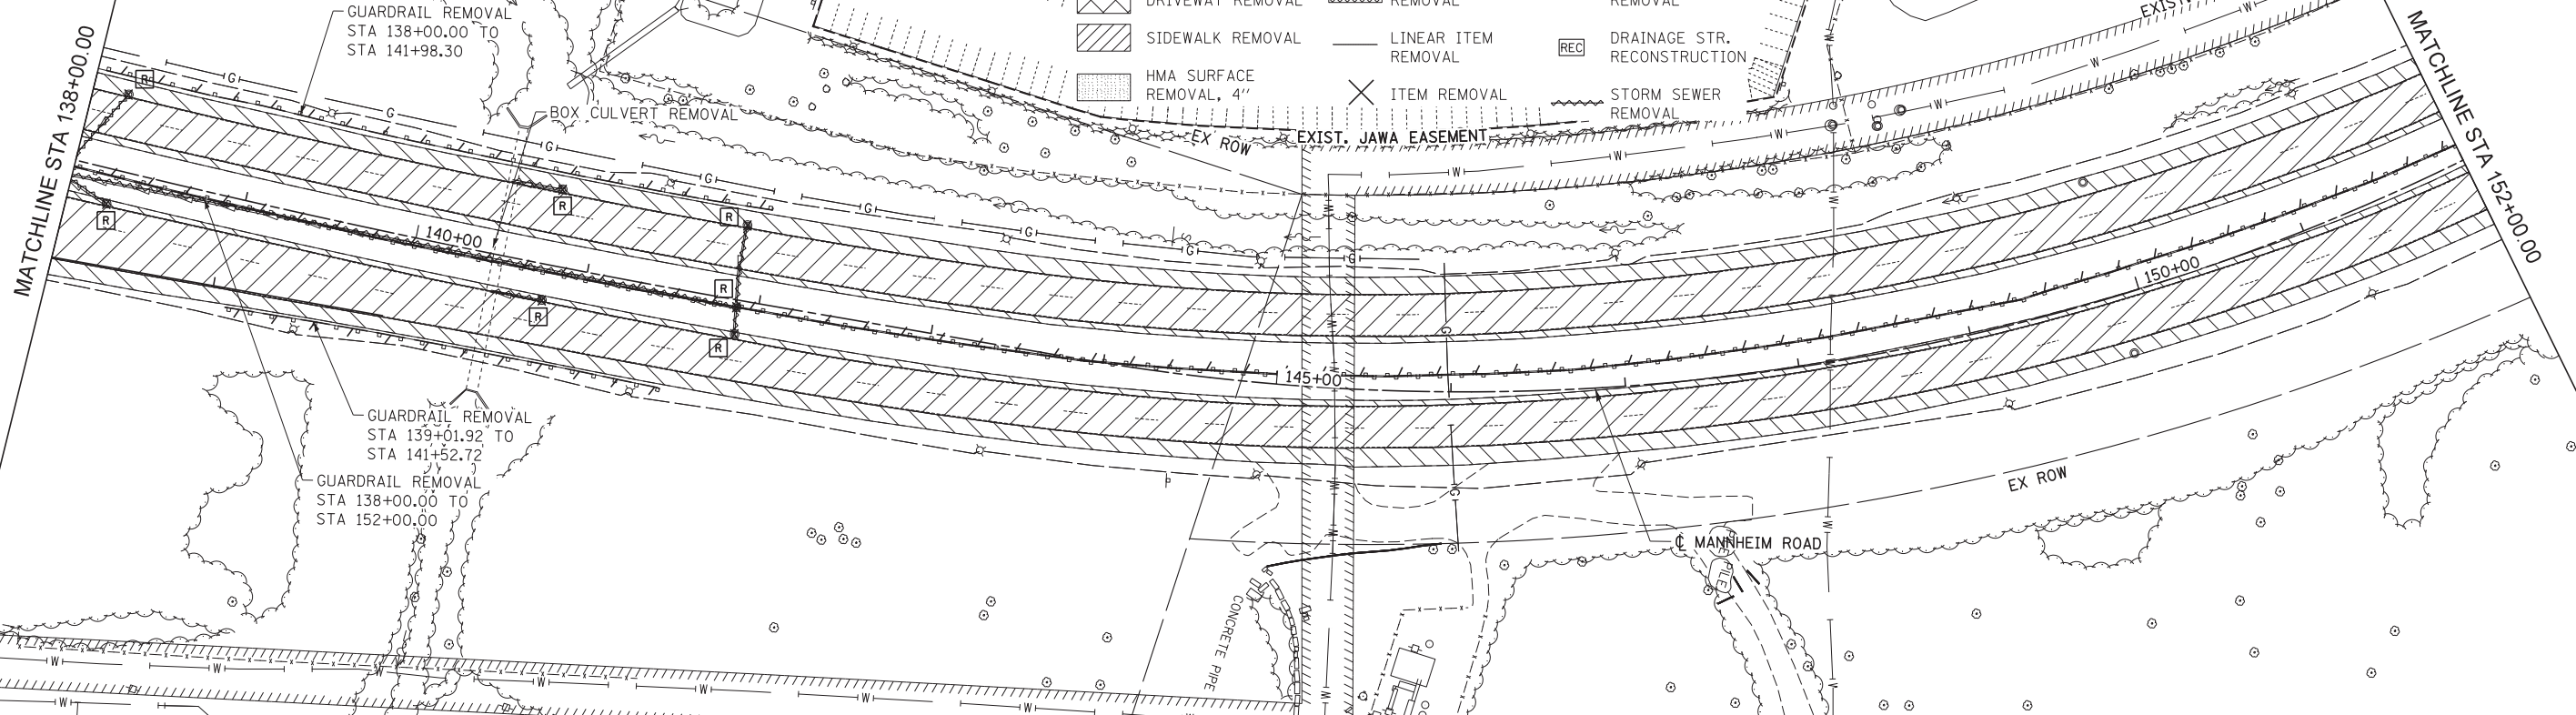

USER NAME = mikosir	DESIGNED LLS/MMK	REVISED -
PLOT SCALE = 50:1	DRAWN MMK	REVISED -
PLOT DATE = 23-OCT-2012	CHECKED LLS	REVISED -
	DATE 10/19/12	REVISED -

STATE OF ILLINOIS
DEPARTMENT OF TRANSPORTATION

**REMOVAL PLAN
MANNHEIM ROAD**

SCALE: 1" = 50' SHEET NO. 2 OF 5 SHEETS STA. 124+00.00 TO STA. 152+00.00

F.A.P. RTE.	SECTION	COUNTY	TOTAL SHEETS	SHEET NO.
330	0105-WRS	COOK	537	56
CONTRACT NO. 60P35				
ILLINOIS FED. AID PROJECT				

REM-02