



NOTES:

1. ALL STATIONS AND OFFSETS CORRESPOND TO MANNHEIM CENTERLINE AND ARE MEASURED FROM THE EDGE OF PAVEMENT UNLESS OTHERWISE NOTED.
2. ALL RADII FOR CURB AND GUTTER ARE TO THE EDGE OF PAVEMENT.
3. SEE PROPOSED DRAINAGE PLANS, OVERHEAD SIGNING PLANS, LANDSCAPING PLANS, TRAFFIC SIGNAL PLANS, AND LIGHTING PLANS FOR DRAINAGE STRUCTURE, PIPE, OVERHEAD SIGN, LANDSCAPING, TRAFFIC SIGNAL AND LIGHTING INFORMATION.
4. FOR ADDITIONAL DETAILS NOT SHOWN, SEE ROADWAY DETAIL SHEETS AND STANDARD DETAILS.
5. RAMP ALIGNMENTS AND CURVE INFORMATION ARE SHOWN ON THE ALIGNMENT AND TIE SHEETS.

PLAN	SURVEYED	DATE
	BY	
	NO.	
	CHECKED	
	DATE	
	BY	
	NO.	

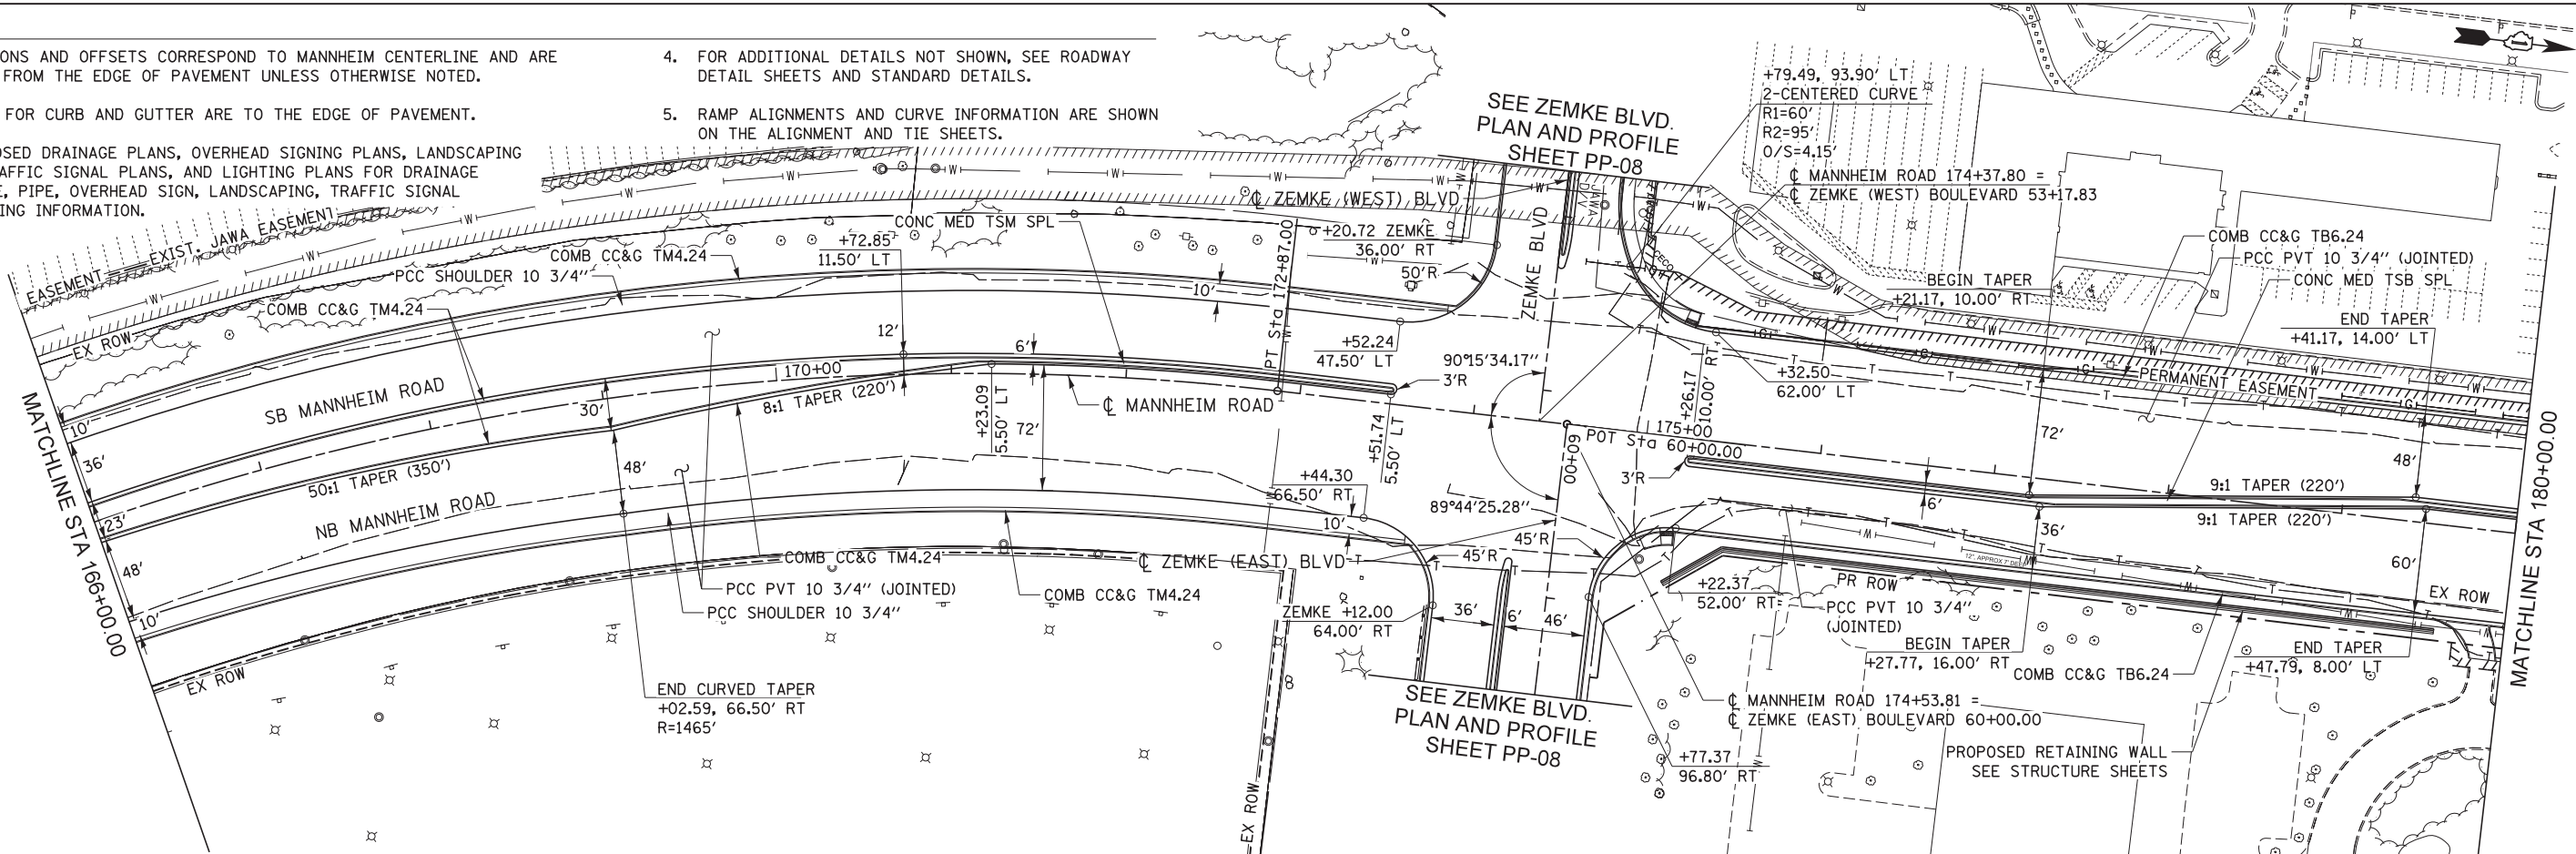

PROFILE	SURVEYED	DATE
	BY	
	NO.	
	CHECKED	
	DATE	
	BY	
	NO.	

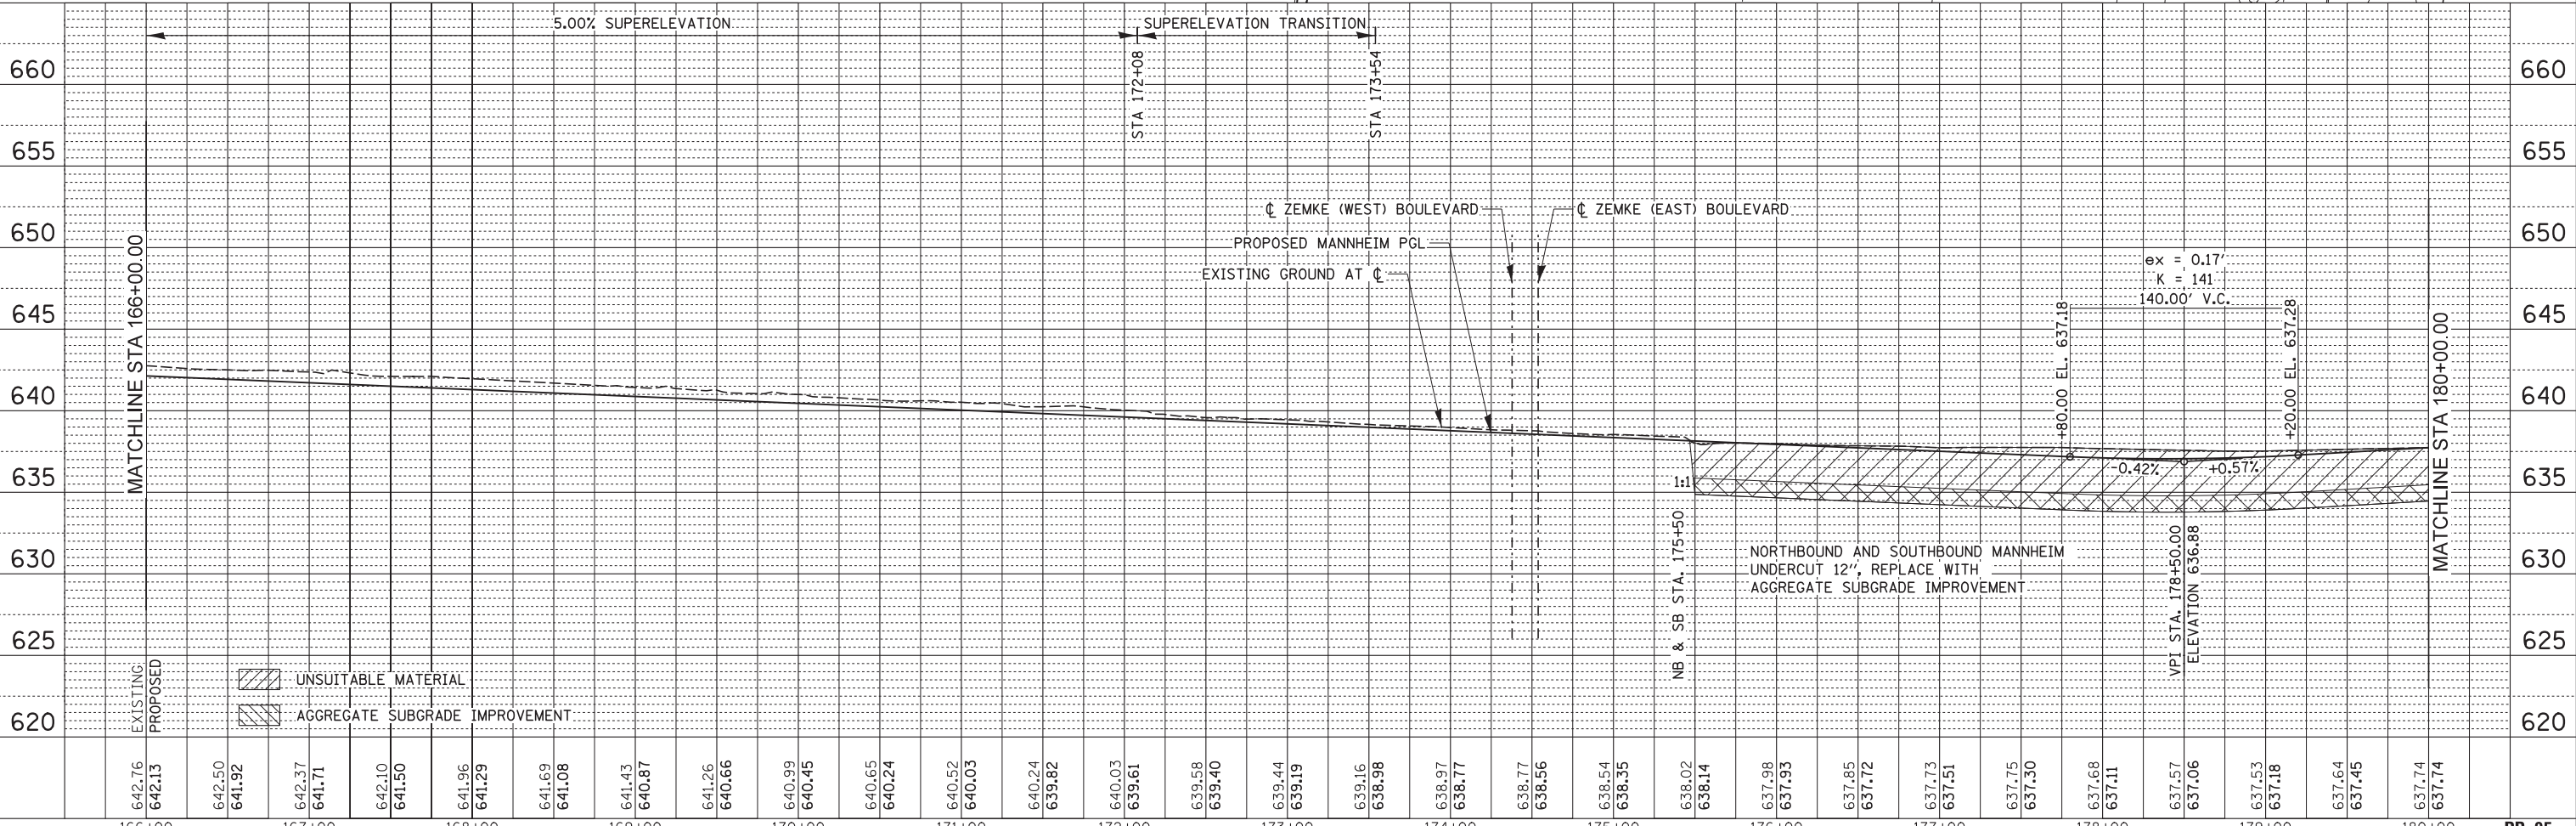

642.76	642.13	642.50	641.92	642.37	641.71	642.10	641.50	641.96	641.29	641.69	641.08	641.43	640.87	641.26	640.66	640.99	640.45	640.65	640.24	640.52	640.03	640.24	639.82	640.03	639.61	639.58	639.40	639.44	639.19	639.16	638.98	638.97	638.77	638.77	638.56	638.54	638.35	638.02	638.14	637.98	637.93	637.85	637.72	637.73	637.51	637.75	637.30	637.68	637.11	637.57	637.06	637.53	637.18	637.64	637.45	637.74	637.74
166+00	167+00	168+00	169+00	170+00	171+00	172+00	173+00	174+00	175+00	176+00	177+00	178+00	179+00	180+00											PP-05																																



USER NAME = mksosr
 DESIGNED LLS/MMK
 DRAWN MMK
 CHECKED LLS
 DATE 10/19/12

REVISD -
 REVISD -
 REVISD -
 REVISD -

STATE OF ILLINOIS
 DEPARTMENT OF TRANSPORTATION

PLAN AND PROFILE
 MANNHEIM ROAD

SCALE: 1" = 50' SHEET NO. 5 OF 10 SHEETS STA. 166+00.00 TO STA. 180+00.00

F.A.P. RTE.	SECTION	COUNTY	TOTAL SHEETS	SHEET NO.
330	0105-WRS	COOK	537	64
CONTRACT NO. 60P35				
ILLINOIS FED. AID PROJECT				