


NOTE:

1. THIS WORK SHALL BE CONSIDERED AS INCLUDED IN THE CONTRACT UNIT PRICE BID FOR THE STORM SEWER ITEMS.


**STORM SEWER PLUG**

**GRADING DETAILS**

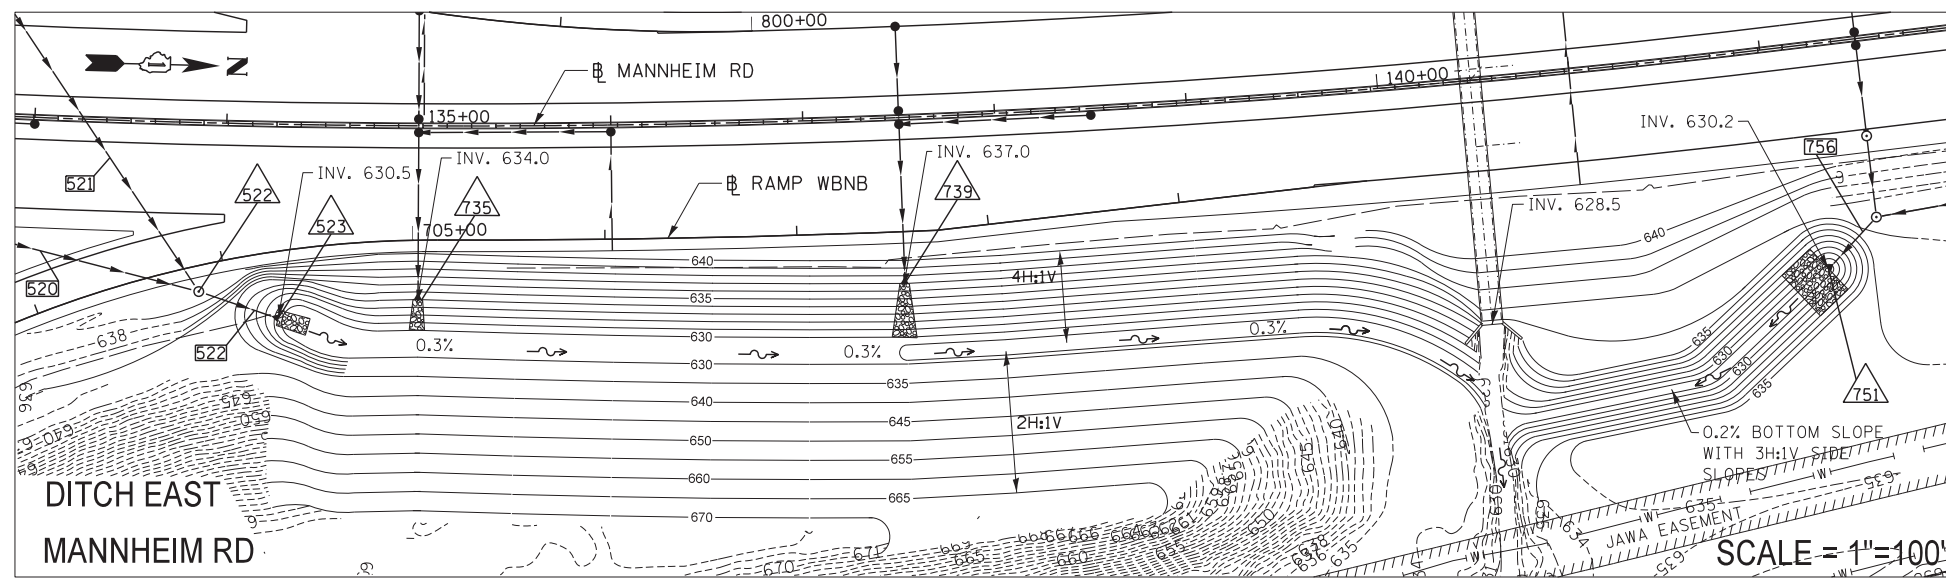

NOTE:

1. SEE MANNHEIM RD CROSS SECTIONS FOR FURTHER DITCH GRADING DETAILS.

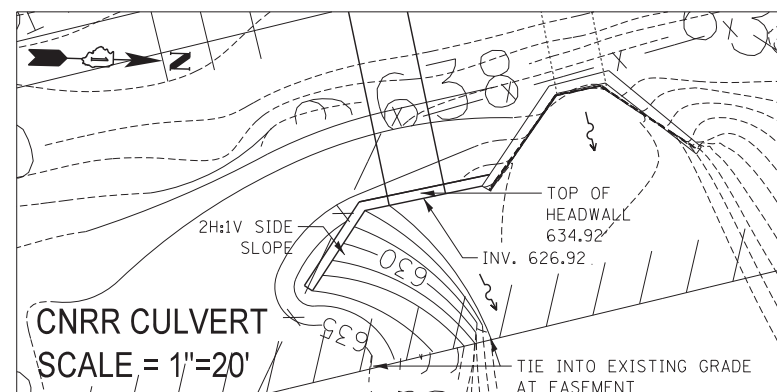

NOTE:

1. SEE PROPOSED CULVERT UNDER CNRR GENERAL PLAN SHEET FOR EROSION CONTROL DETAILS.

F:\0001\2584-02\COMMON\SET\TEMP\SET\TEMP\DRINET\_08.DGN  
 10-25-2012 14:53:34  
 BA\ZKJKJ

FILE NAME = #FILE#	USER NAME = #USER#	DESIGNED - TKL	REVISED -
		DRAWN - KC	REVISED -
	PLOT SCALE = #SCALE#	CHECKED - MCD	REVISED -
	PLOT DATE = #DATE#	DATE - 10/19/12	REVISED -

**STATE OF ILLINOIS  
DEPARTMENT OF TRANSPORTATION**

**DRAINAGE DETAILS**

SCALE: T.S. SHEET NO. OF SHEETS STA. TO STA.

F.A. RTE.	SECTION	COUNTY	TOTAL SHEETS	SHEET NO.
	0105-WRS	COOK	537	194
			CONTRACT NO. 60P35	
ILLINOIS FED. AID PROJECT				

DD-08