




SIGN NUMBER	214
WIDTH x HGHT.	11'-2" x 6'-3"
BORDER WIDTH	1.5"
CORNER RADIUS	6"
MOUNTING	Ground
BACKGROUND	TYPE: Reflective COLOR: Blue
LEGEND/BORDER	TYPE: Reflective COLOR: White/White

SYMBOL	ROT	X	Y	WID	HT
AR_Type A - Extended	90	57.7	5.6	8.1	18.5

Panel Style: DOA GENRAL.ssi
Dimensions are in inches.tenths

Letter locations are panel edge to lower left corner

LETTER POSITIONS (X)																LENGTH	SERIES/SIZE				
A	i	r	p	o	r	t											E 2000				
48.7	57.9	60.8	65.3	71.2	77.6	81.5											36.5	86			
M	a	l	n	t	e	n	a	n	c	e	C	o	m	p	l	e	x	E 2000			
9.6	18.6	24.8	27.7	33.4	37.6	43.6	49.6	55.8	61.9	67.6	72.6	80.6	88.3	94.6	104.3	110.5	113.1	118.4	114.7	86	
E	a	s	t		A	i	r		C	a	r	g	o					E 2000			
25.4	32.4	38.2	43.4	47.1	55.1	64.3	67.2	70.9	78.9	86.6	92.8	97.1	103.3							83	86
G	u	a	r	d		P	o	s	t		1	1						E 2000			
29.8	37.7	43.8	50	54.4	59.3	67.3	74.6	80.5	85.7	89.4	97.4	101.6								74.3	86

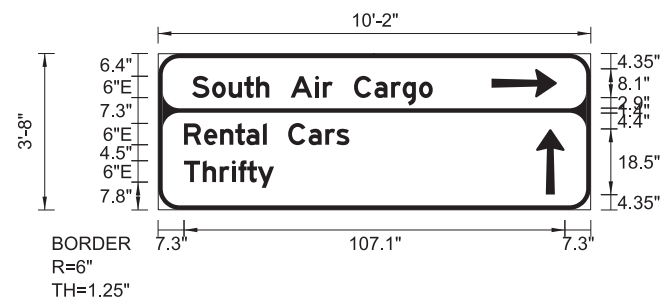


SIGN NUMBER	197
WIDTH x HGHT.	10'-2" x 3'-9"
BORDER WIDTH	1.25"
CORNER RADIUS	6"
MOUNTING	Ground
BACKGROUND	TYPE: Reflective COLOR: Blue /Blue
LEGEND/BORDER	TYPE: Reflective COLOR: White/White

SYMBOL	ROT	X	Y	WID	HT
AR_Type A - Extended	270	93.7	31.6	8.1	18.5
AR_Type A - Extended	0	106.3	4.3	8.1	18.5

Panel Style: DOA GENRAL.ssi
Dimensions are in inches.tenths

Letter locations are panel edge to lower left corner

LETTER POSITIONS (X)																LENGTH	SERIES/SIZE		
S	o	u	t	h		A	i	r		C	a	r	g	o				E 2000	
9.6	15.2	19.9	24.2	27.6	31.3	37.3	44.2	46.3	49.1	55.1	60.9	65.5	68.8	73.4				67.7	64.5
R	e	n	t	a	l		C	a	r	s								E 2000	
7.3	12.9	17.4	21.7	24.8	29.5	30.6	36.6	42.3	47	50.1								46.5	64.5
T	h	r	i	f	t	y												E 2000	
7.3	12.6	17.3	20.7	22.6	25.1	28												25.4	64.5

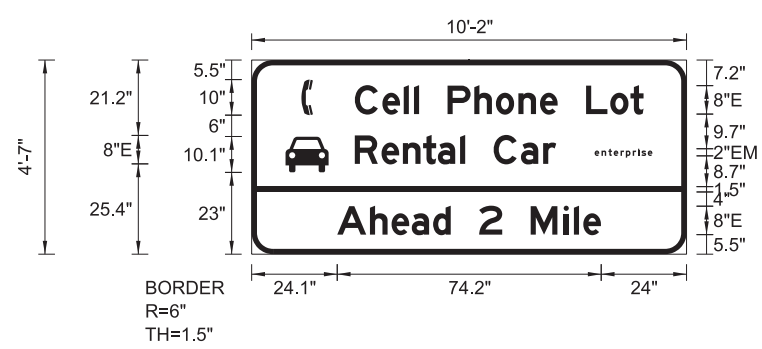


SIGN NUMBER	300
WIDTH x HGHT.	10'-2" x 4'-7"
BORDER WIDTH	1.5"
CORNER RADIUS	6"
MOUNTING	Ground
BACKGROUND	TYPE: Reflective COLOR: Blue /Blue
LEGEND/BORDER	TYPE: Reflective COLOR: White/White

SYMBOL	ROT	X	Y	WID	HT
Telephone	0	14	39.1	3.2	10
Automobile (Front)	0	9.5	23	12.2	10.1

Panel Style: DOA GENRAL.ssi
Dimensions are in inches.tenths

Letter locations are panel edge to lower left corner

LETTER POSITIONS (X)																LENGTH	SERIES/SIZE		
C	e	l	l		P	h	o	n	e		L	o	t					E 2000	
29	36.8	42.8	45.6	47.1	55.1	62.6	68.7	75	81.1	86	94	100.8	106.5					81.3	86
e	n	t	e	r	p	r	i	s	e									EM 2000	
96.4	98.4	100.3	101.8	103.7	105.2	107.2	108.6	109.6	111.4									16.4	21.5
R	e	n	t	a	l		C	a	r									E 2000	
29	36.5	42.5	48.2	52.4	58.6	60	68	75.7	82									56.7	86
A	h	e	a	d		2		M	i	l	e							E 2000	
24.1	33.3	39.3	45	51	56	64	70.5	78.5	87.7	90.6	93.3							74.2	86

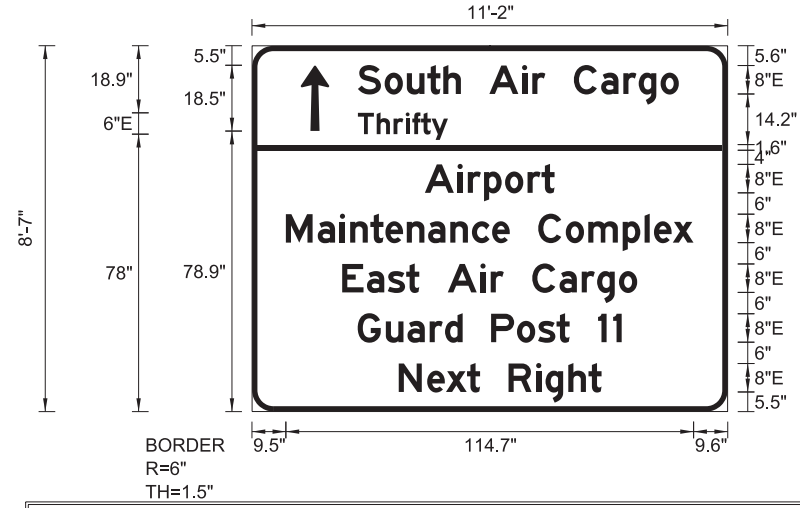

SIGN NUMBER	232
WIDTH x HGHT.	11'-2" x 8'-7"
BORDER WIDTH	1.5"
CORNER RADIUS	6"
MOUNTING	Ground
BACKGROUND	TYPE: Reflective COLOR: Blue /Blue
LEGEND/BORDER	TYPE: Reflective COLOR: White/White

SYMBOL	ROT	X	Y	WID	HT
AR_Type A - Extended	0	13.7	78.9	8.1	18.5

Panel Style: DOA GENRAL.ssi
Dimensions are in inches.tenths

Letter locations are panel edge to lower left corner

LETTER POSITIONS (X)																LENGTH	SERIES/SIZE				
S	o	u	t	h		A	i	r		C	a	r	g	o				E 2000			
29.8	37.3	43.6	49.3	53.8	58.8	66.8	76	78.8	82.5	90.5	98.2	104.4	108.8	114.9				90.3	86		
T	h	r	i	f	t	y												E 2000			
29.8	35.1	39.8	43.2	45.1	47.6	50.5												25.4	64.5		
A	i	r	p	o	r	t												E 2000			
48.6	57.8	60.7	65.3	71.2	77.5	81.4												36.6	86		
M	a	i	n	t	e	n	a	n	c	e	C	o	m	p	l	e	x	E 2000			
9.5	18.5	24.7	27.6	33.3	37.5	43.5	49.5	55.8	61.9	67.5	72.5	80.5	88.3	94.6	104.3	110.4	113.1	118.3	114.7	86	
E	a	s	t		A	i	r		C	a	r	g	o					E 2000			
25.4	32.3	38.2	43.4	47.1	55.1	64.3	67.1	70.8	78.8	86.5	92.7	97.1	103.2							83	86
G	u	a	r	d		P	o	s	t		1	1						E 2000			
29.7	37.7	43.7	50	54.3	59.3	67.3	74.5	80.5	85.7	89.3	97.3	101.6								74.3	86
N	e	x	t		R	i	g	h	t									E 2000			
41.3	49.3	54.6	60.5	64.2	72.2	79.9	82.6	89	94.6									57.1	86		



USER NAME = micosir	DESIGNED DJJ	REVISED -
PLOT SCALE = 3:1	DRAWN MMK	REVISED -
PLOT DATE = 08-OCT-2012	CHECKED LLS	REVISED -
	DATE 10/19/12	REVISED -

STATE OF ILLINOIS
DEPARTMENT OF TRANSPORTATION

SIGN PANEL DETAILS

SCALE: N.T.S.	SHEET NO. 2 OF 2 SHEETS	STA. TO STA.
---------------	-------------------------	--------------

F.A.P. RTE. 330	SECTION 0105-WRS	COUNTY COOK	TOTAL SHEETS 537	SHEET NO. 215
CONTRACT NO. 60P35				ILLINOIS FED. AID PROJECT

SGN-PD-02