



**TYPICAL SPLICE DETAIL**  
N.T.S.

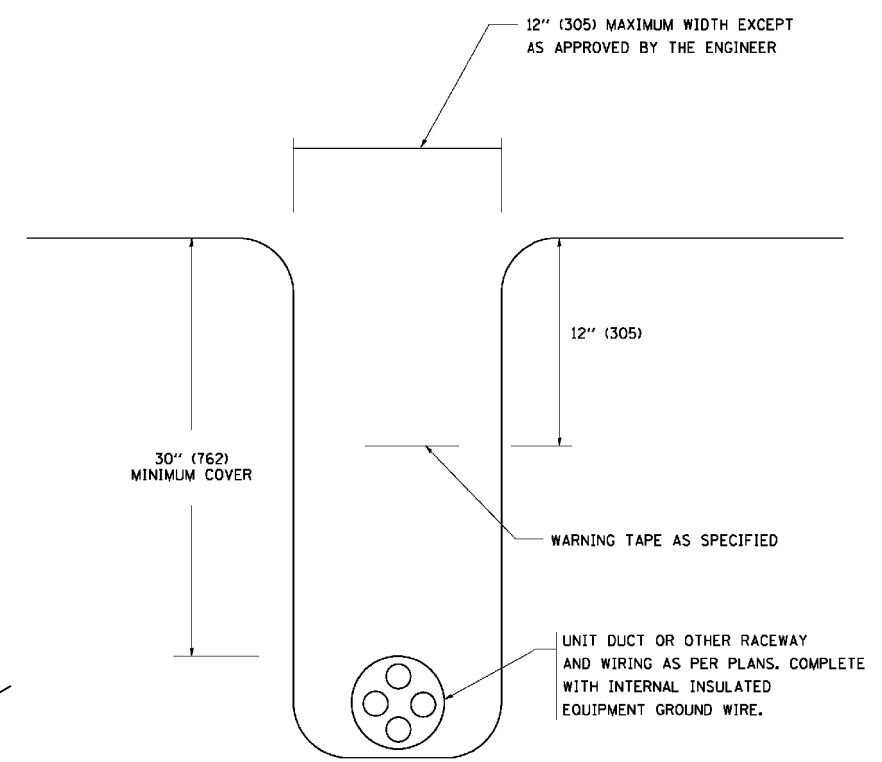

**TYPICAL WIRING IN TRENCH DETAIL**  
N.T.S.

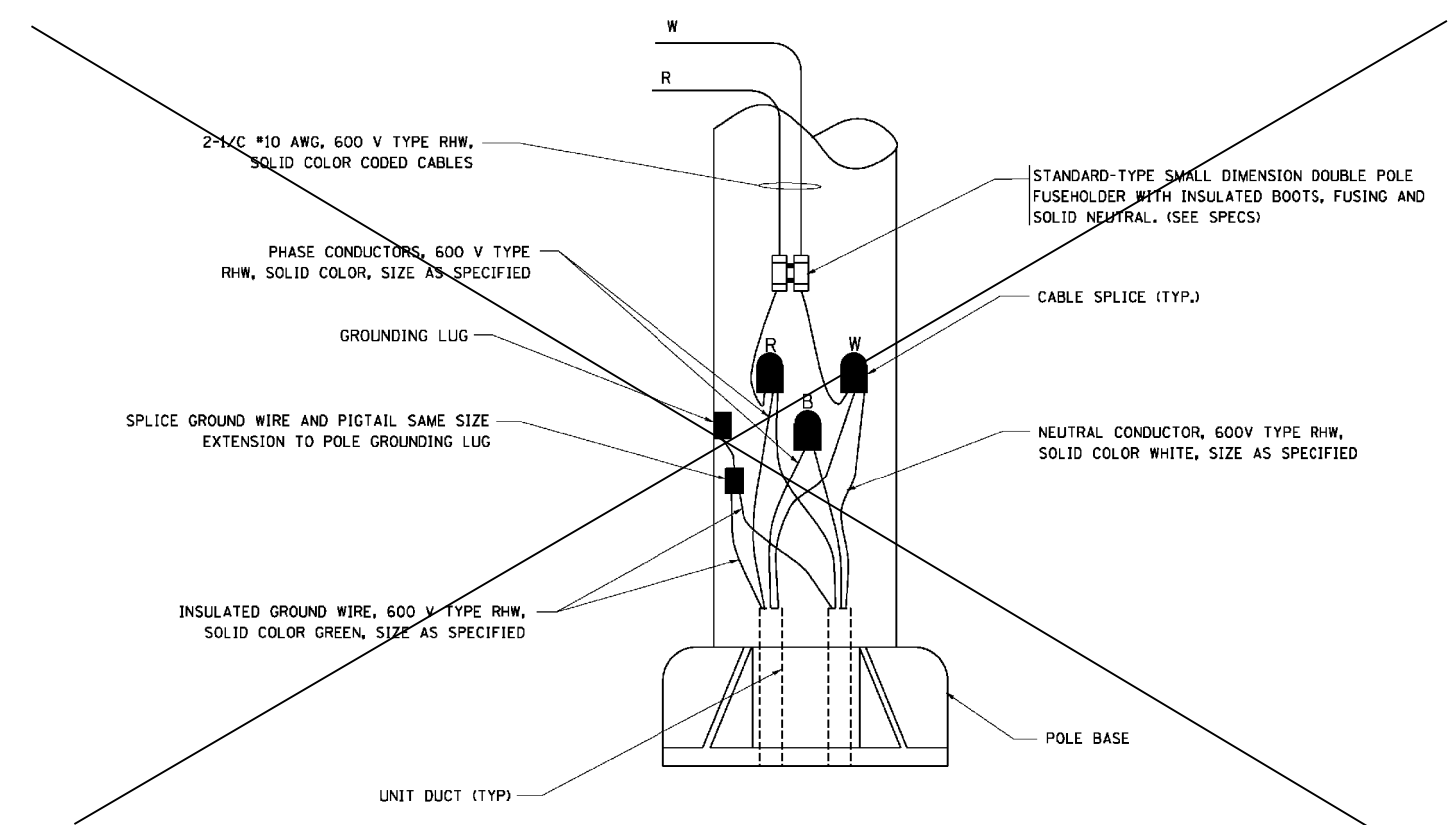

**POLE WIRING DETAIL**  
N.T.S.

FILE NAME = W:\distsatd\22x34\be702.dgn	USER NAME = ggallanob	DESIGNED -	REVISED - 08-08-03	<b>STATE OF ILLINOIS DEPARTMENT OF TRANSPORTATION</b>	<b>MISC. ELECTRICAL DETAILS SHEET A</b>			F.A.U. RTE.	SECTION	COUNTY	TOTAL SHEETS	SHEET NO.
		DRAWN -	REVISED -		SCALE: NONE	SHEET NO. 1 OF 1 SHEETS	STA. TO STA.	BE-702		CONTRACT NO.		
		CHECKED -	REVISED -		FED. ROAD DIST. NO. 1 ILLINOIS FED. AID PROJECT							
		DATE -	REVISED -									

<b>SINGH</b> SINGH & ASSOCIATES, INC. CONSULTING ENGINEERS	300 W. ADAMS ST. CHICAGO, IL 60606 TEL: (312) 629-0240 FAX: (312) 629-8449	USER NAME = user	DESIGNED - MK	REVISED -	<b>STATE OF ILLINOIS DEPARTMENT OF TRANSPORTATION</b>	<b>IDOT LIGHTING STANDARD DETAILS IL ROUTE 19 (IRVING PARK RD.)</b>			F.A.U. RTE.	SECTION	COUNTY	TOTAL SHEETS	SHEET NO.
			DRAWN - YJ	REVISED -		SCALE: NONE	SHEET NO. 6 OF 7 SHEETS	STA. TO STA.	32VB		CONTRACT NO. 60W01		
			CHECKED - LGP/GR	REVISED -		ILLINOIS FED. AID PROJECT							
			DATE - 11-02-2012	REVISED -									