



DECK DRAINAGE PLAN

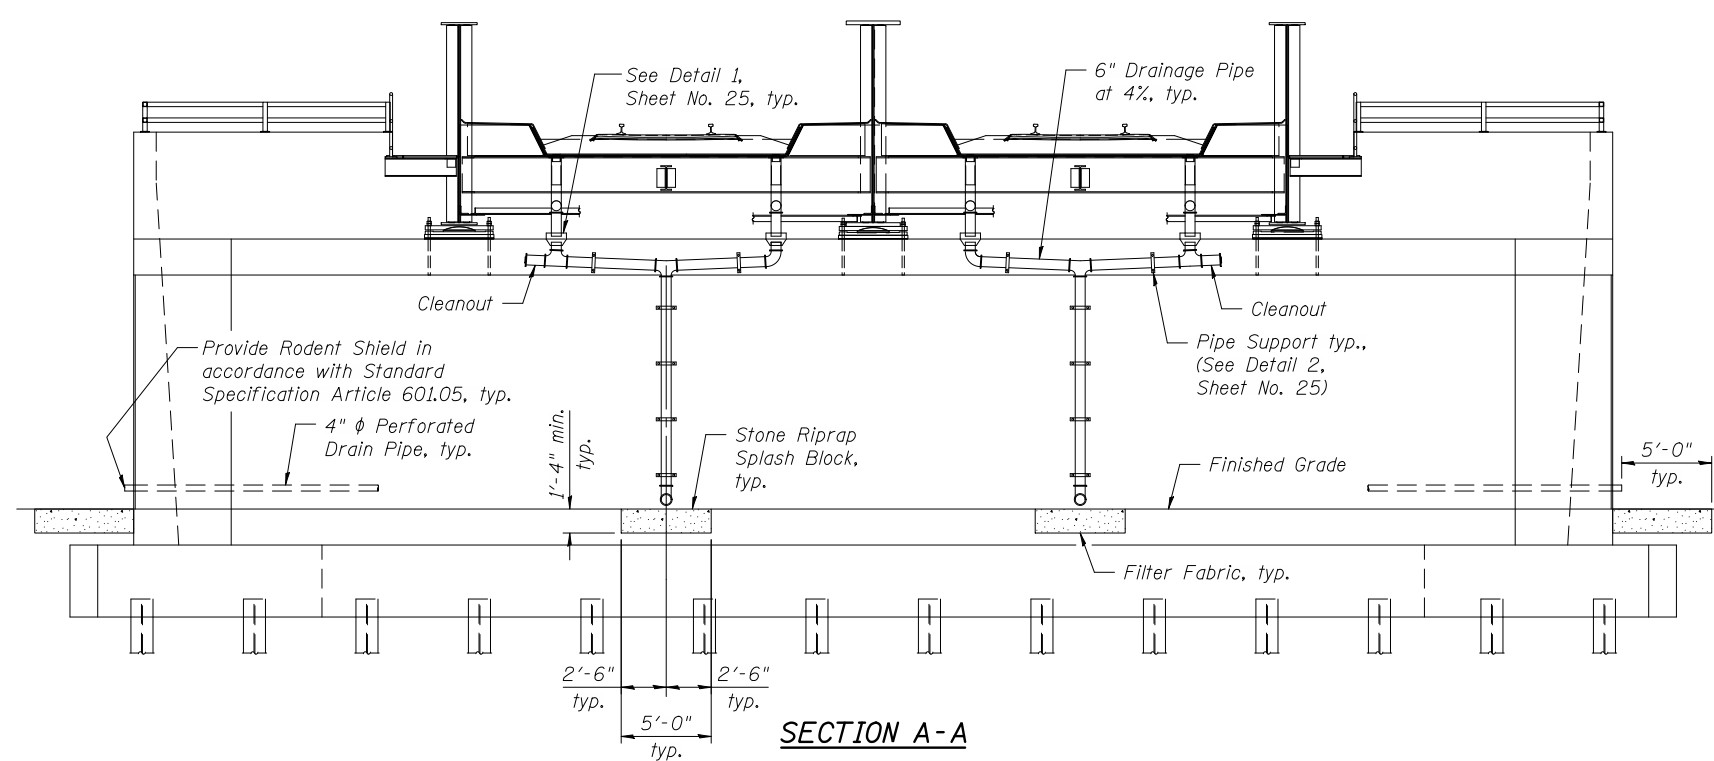

SECTION A-A

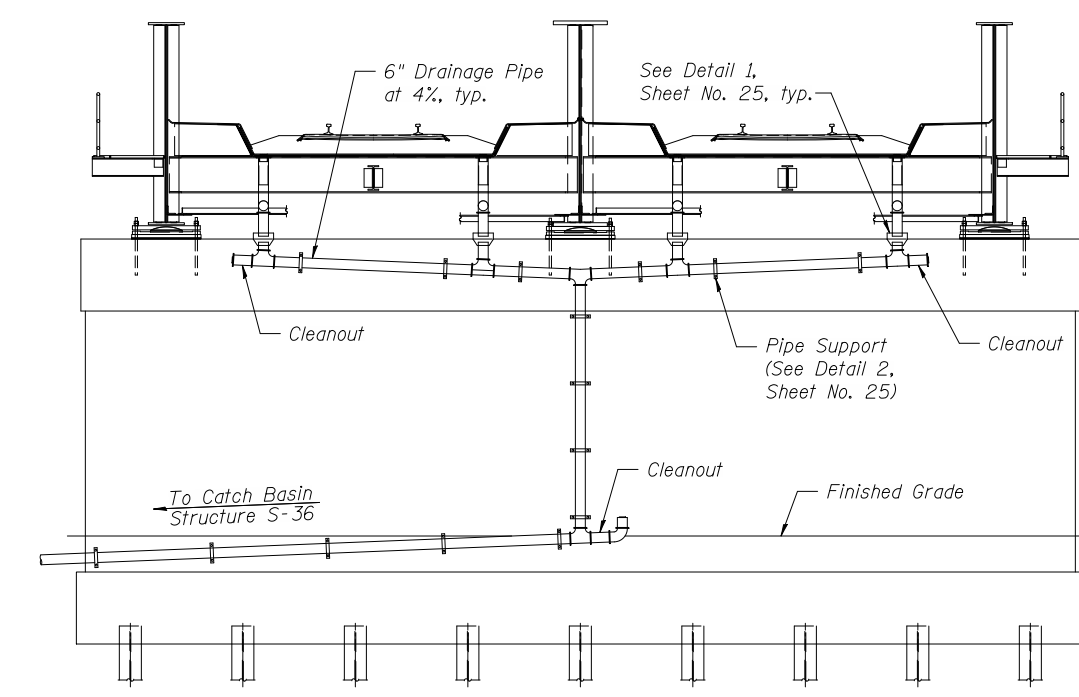

SECTION B-B

cc:\pwworking\oma\0463409\0220226-60B42-024-DDS.DGN
jmlgus

11/2/2012 11:25:02 AM



USER NAME = jmlgus	DESIGNED - AMM	REVISED -
FILE NAME = 0220226-60B42-024-DDS.DGN	CHECKED - LAG	REVISED -
PLOT SCALE = NONE	DRAWN - RMA	REVISED -
PLOT DATE = 11/2/2012	CHECKED - AMM	REVISED -

**STATE OF ILLINOIS
DEPARTMENT OF TRANSPORTATION**

**DECK DRAINAGE SYSTEM
STRUCTURE NO. 022-0226**

SHEET NO. 24 OF 43 SHEETS

F.A.U. RTE.	SECTION	COUNTY	TOTAL SHEETS	SHEET NO.
1321	32VB	DU	388	165
CONTRACT NO. 60W01				

ILLINOIS FED. AID PROJECT