

STATE OF ILLINOIS  
DEPARTMENT OF TRANSPORTATION  
DIVISION OF HIGHWAYS

**PLANS FOR PROPOSED  
FEDERAL AID PROJECT**

FAU 1453 (WEST 22ND STREET)  
SPRING ROAD TO SALT CREEK  
STREETSCAPE ENHANCEMENTS  
SECTION NO: 11-00043-00-LS  
PROJECT NO: TE-00D1 (872)  
VILLAGE OF OAK BROOK  
DUPAGE COUNTY  
JOB NO: C-91-501-11

F.A.U. RTE. 1453	SECTION 11-00043-00-LS	COUNTY DU PAGE	TOTAL SHEETS 20	SHEET NO. 1
FED. ROAD DIST. NO. 1 ILLINOIS		FED. AID PROJECT TE-00D1 (872)		CONTRACT NO. 63663




INDEX OF SHEETS

SHEET NO.	SHEET DESCRIPTION
1	COVER SHEET
2	SUMMARY OF QUANTITIES, GENERAL NOTES, AND HIGHWAY STANDARDS
3	EXISTING CONDITIONS
4	TYPICAL SECTIONS
5-8	LAYOUT AND MATERIALS PLAN
7-8	LANDSCAPE PLAN
9	LANDSCAPE DETAILS AND NOTES
10-11	ELECTRICAL PLAN
12	ELECTRICAL DETAILS AND NOTES
13-14	IRRIGATION PLAN
15	IRRIGATION LEGEND AND NOTES
16	IRRIGATION DETAILS
17-20	CONSTRUCTION DETAILS HIGHWAY STANDARDS

TRAFFIC DATA

ADT = 29,700 VPD (2011)  
POSTED SPEED LIMIT = 40 MPH  
FUNCTIONAL CLASSIFICATION = MINOR ARTERIAL


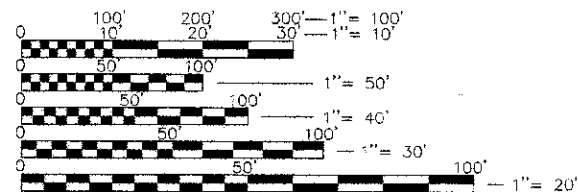


FULL SIZE PLANS HAVE BEEN PREPARED USING STANDARD ENGINEERING SCALES. REDUCED SIZED PLANS WILL NOT CONFORM TO STANDARD SCALES. IN MAKING MEASUREMENTS ON REDUCED PLANS, THE ABOVE SCALES MAY BE USED.

**Call Before You Dig**

**TULIE**

CONTACT JULIE 48 HOURS (2 WORKING DAYS) BEFORE YOU DIG AT 811 OR 800-892-0123 WITH THE FOLLOWING:  
COUNTY: DU PAGE  
VILLAGE: OAK BROOK  
TOWNSHIP: YORK

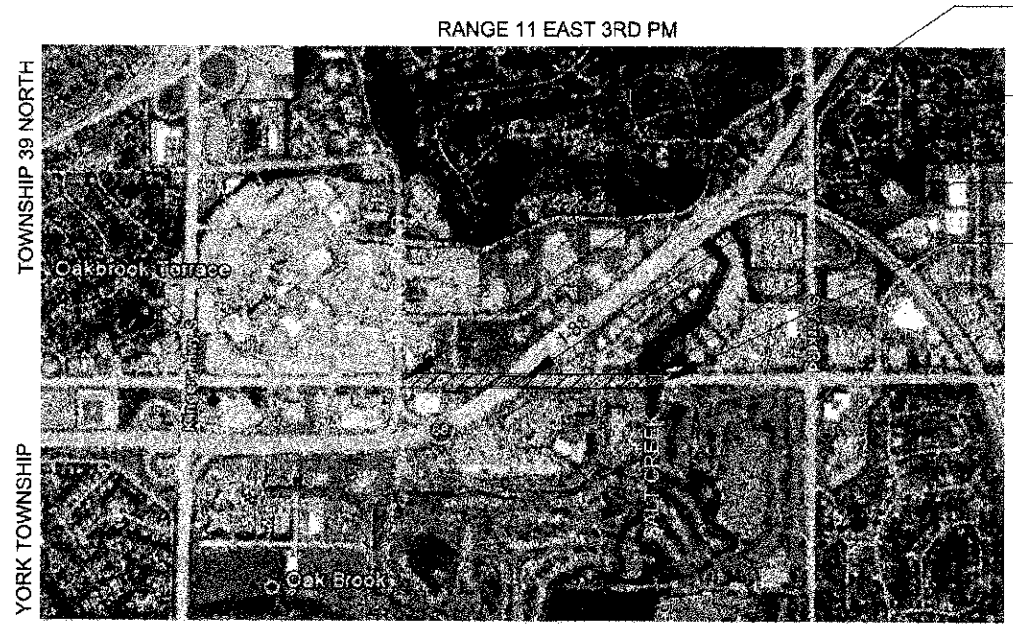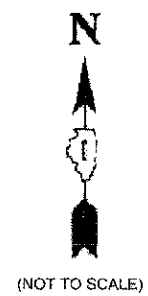

LOCATION MAP  
SCALE: 1" = 500'  
GROSS LENGTH OF IMPROVEMENT: 3,095 FT (0.586 MILES)  
NET LENGTH OF IMPROVEMENT: 3,095 FT (0.586 MILES)

PROJECT BEGINS  
STA 2106+83.00

EXISTING STRUCTURE NOS. 022-9801  
022-9941  
022-9942

EXISTING STRUCTURE NO. 022-0084

PROJECT ENDS  
STA 2137+78.00

John F. Mayer, P.E.  
IL. P.E. NO. 062-047345  
Expires November 30, 2013

STATE OF ILLINOIS  
DEPARTMENT OF TRANSPORTATION  
DIVISION OF HIGHWAYS

APPROVED 12/16 20 11  
[Signature]  
VILLAGE REPRESENTATIVE

PASSED JANUARY 5 20 12  
[Signature]  
DISTRICT 1 ENGINEER OF LOCAL ROADS & STREETS

RELEASING FOR BID  
BASED ON LIMITED  
REVIEW JANUARY 6 20 12  
[Signature]  
DEPUTY DIRECTOR OF HIGHWAYS, REGION ONE ENGINEER

PRINTED BY THE AUTHORITY  
OF THE STATE OF ILLINOIS

PROGRAM AND OFFICE ENGINEER: CHARLES F. RIDDLE, P.E. 847-705-4406 SCHAUMBURG, IL

CONTRACT NO. 63663

HDG PROJECT NO: 03-0745-008-01-06 DATE: 12-19-11