



 




LEGEND

-  EXISTING LIGHT FIXTURE
-  MODIFY EXISTING STREET LIGHT CIRCUIT
-  PROPOSED UNIT DUCT, 1" (2#8, #6G XLP-USE)
-  PROPOSED GALVANIZED STEEL CONDUIT
-  EXISTING ELECTRICAL CONTROL CABINET



J:\PROJECTS\7975\7975-0745-VILLAGE OF OAK BROOK\008-22ND STREET TEP ENHANCEMENT\SW GRAPHICS\05-00-00\11 ELECTRICAL.DWG 10
 Plotted: 12/19/2011 11:40 AM By: TSKC
 Copyright © 2011, by Hitchcock Design Group

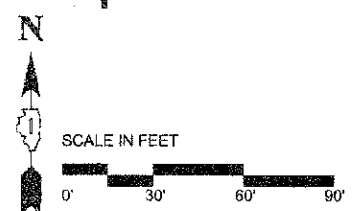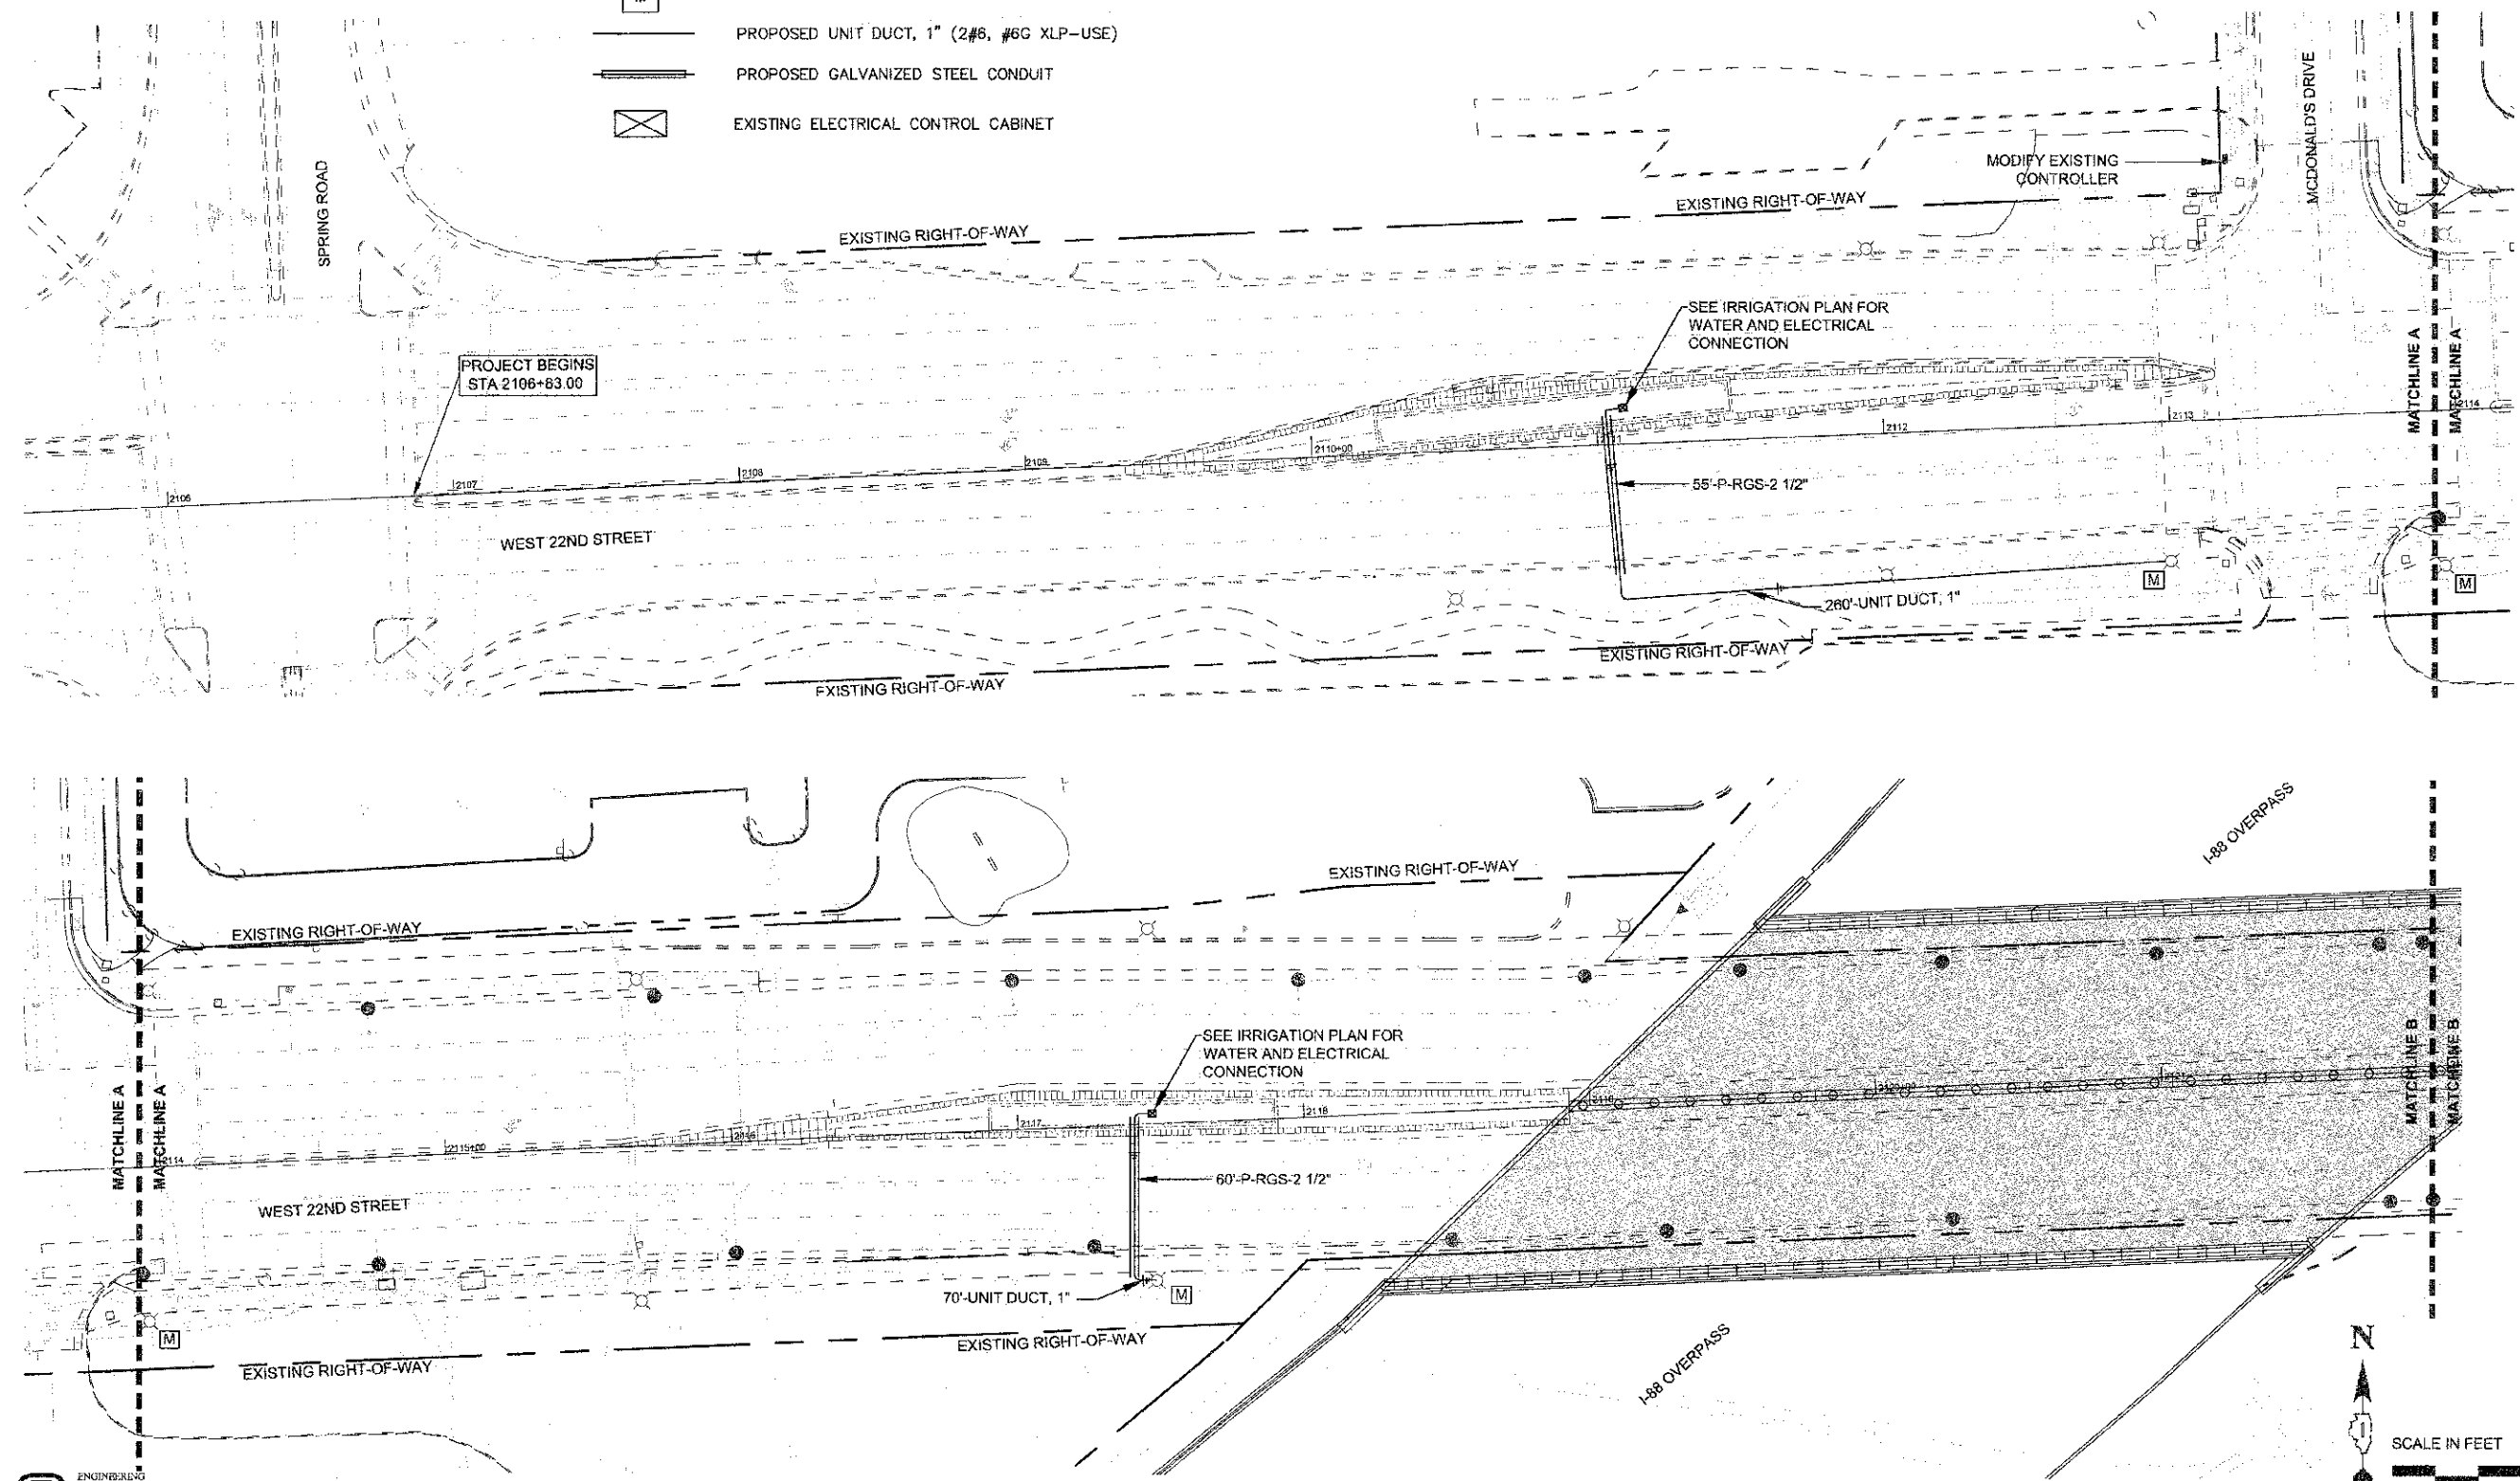

DESIGNED - MEU	REVISED -
DRAWN - BLG	REVISED -
CHECKED - TCK	REVISED -
DATE - 12-19-11	REVISED -

STATE OF ILLINOIS
DEPARTMENT OF TRANSPORTATION

ELECTRICAL PLAN

SCALE: 1" = 30'
 PROJECT - 03-0745-008 STA. 2105+83.00 TO STA. 2122+83.00

F.A.U. RTE.	SECTION	COUNTY	TOTAL SHEETS	SHEET NO.
1463	11-03043-00-LS	DUPAGE	20	10
CONTRACT 53863				
FED. ROAD DIST. NO. 1 ILLINOIS FED. AID PROJECT TE-001 (872)				