
 




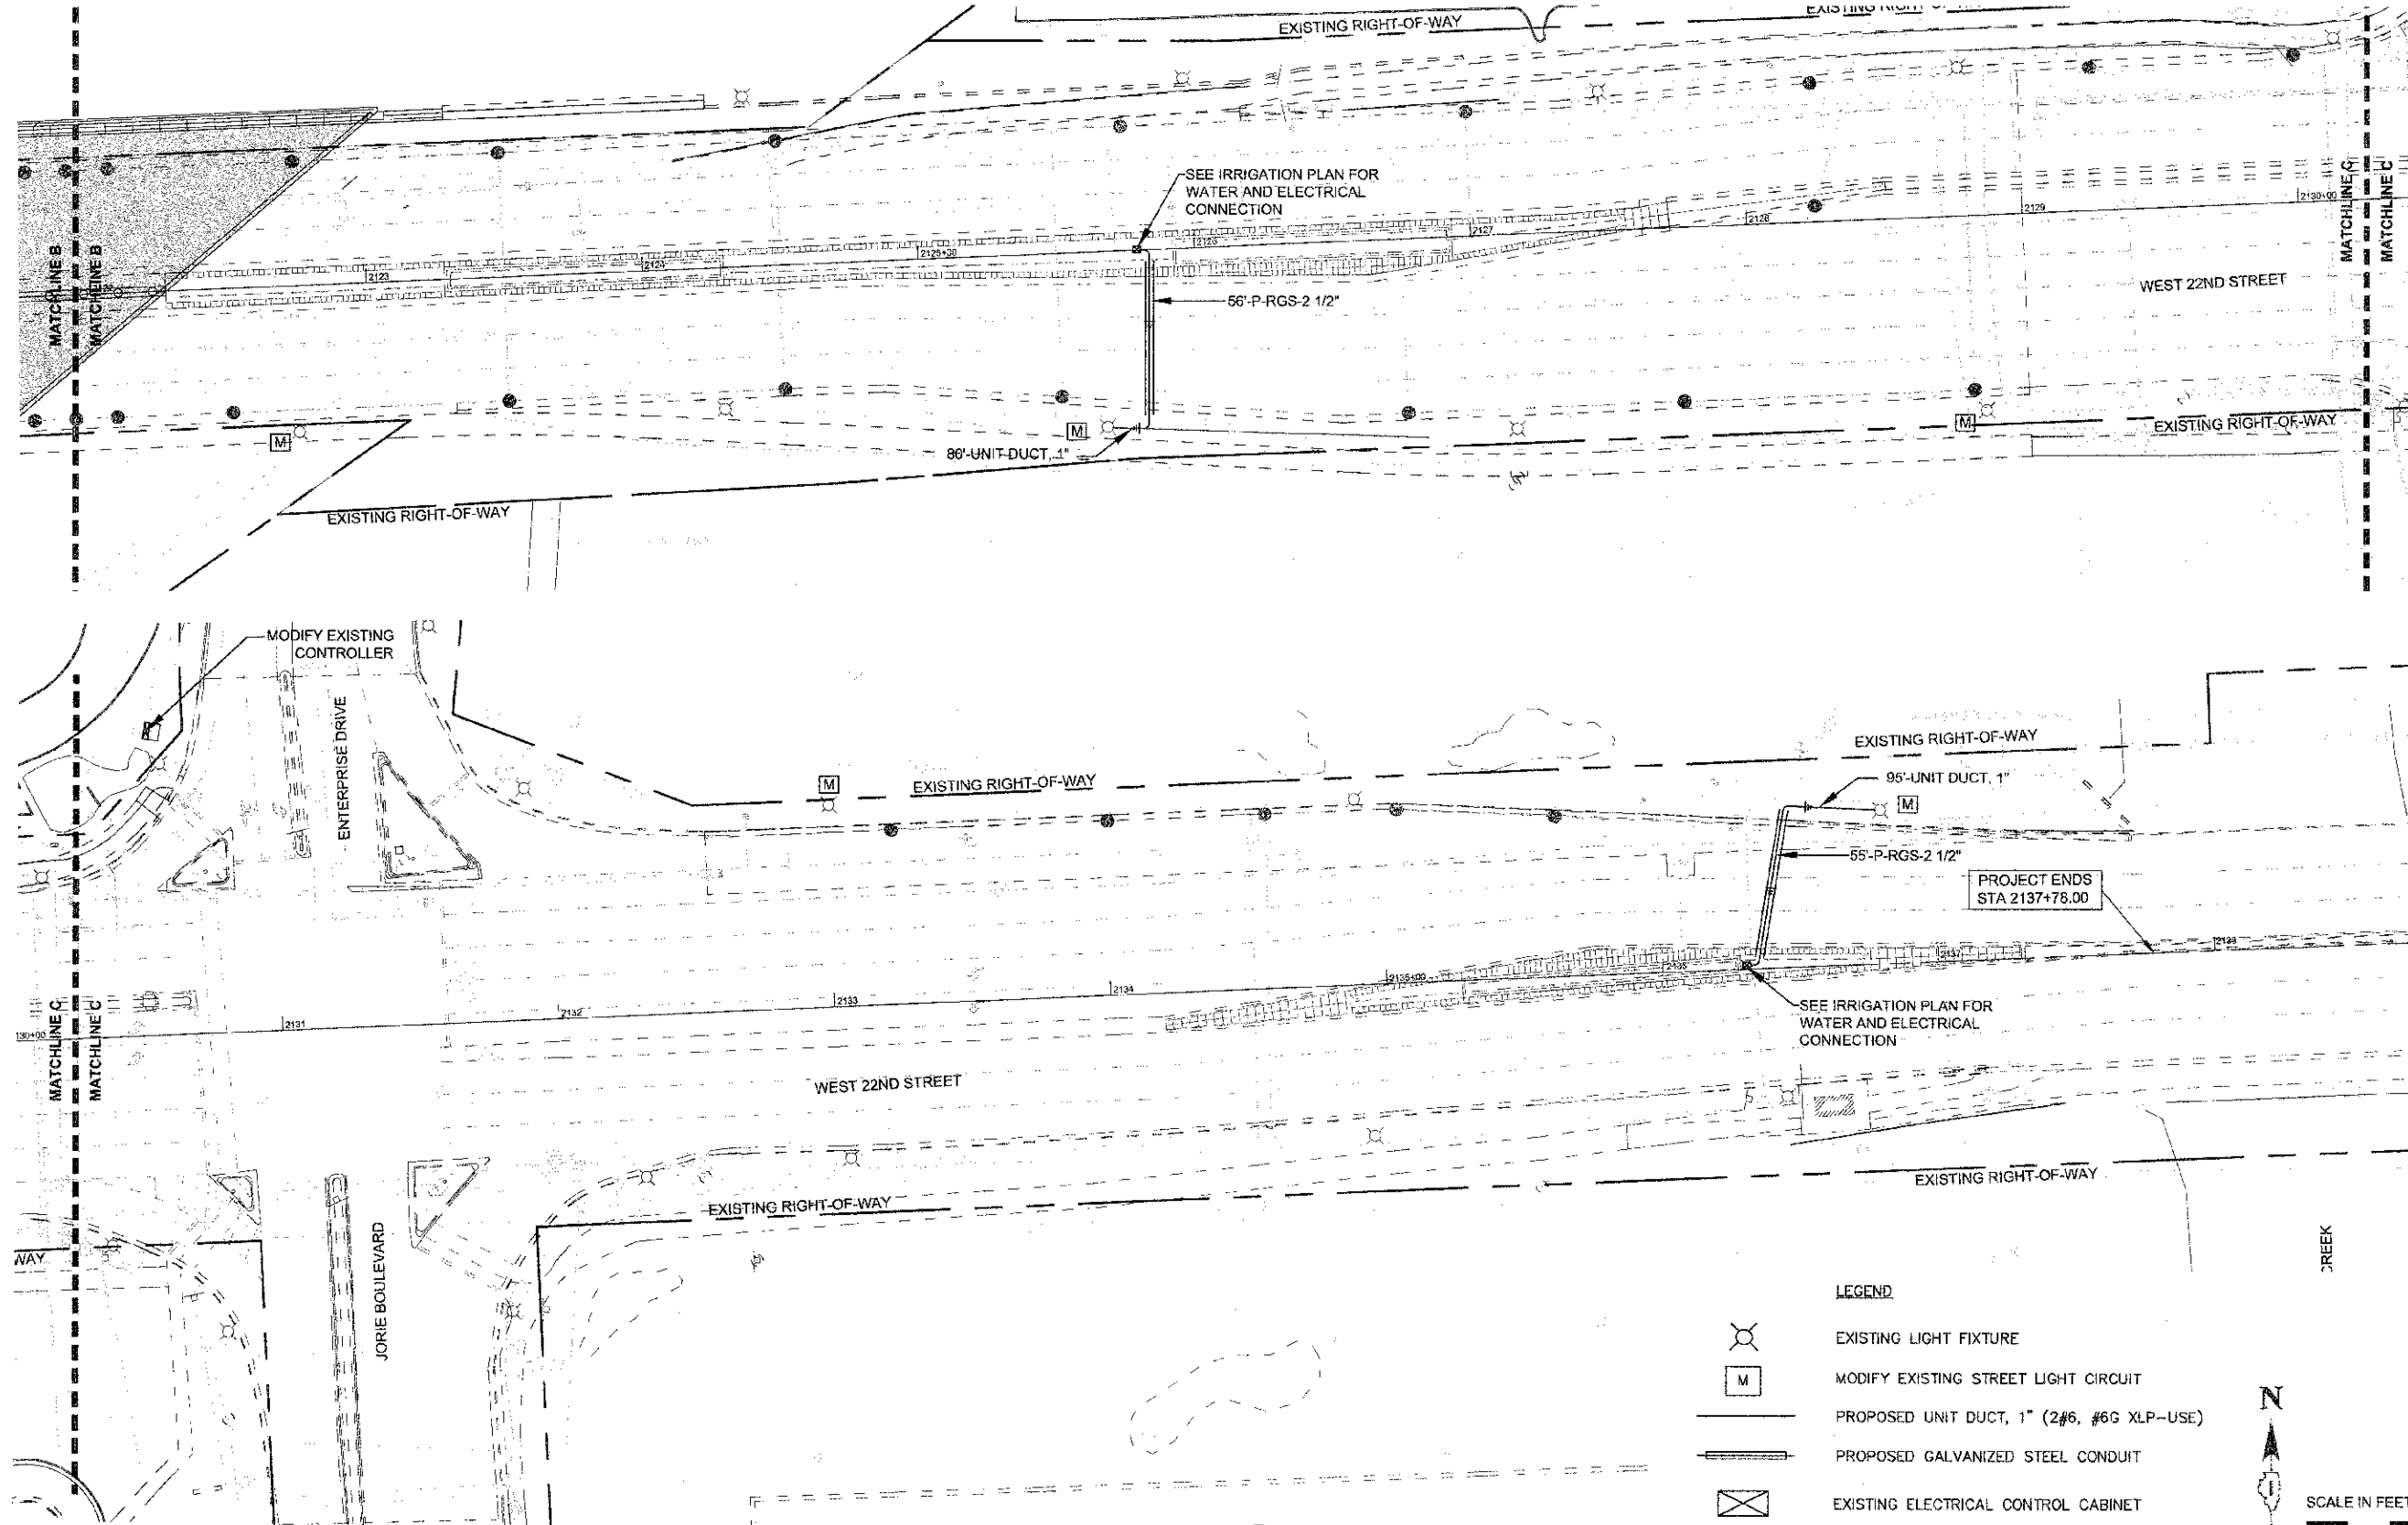


PROJECT: 03-0745-001 DAK BROOK JOB 22ND STREET FEP ENHANCEMENT V.H. 03-0745-001-02-00-11-C-0000A.DWG 11
 Plotted: 12/19/2011 11:47 AM By: IKING
 Copyright © 2011, by Hitchcock Design Group



- LEGEND**
-  EXISTING LIGHT FIXTURE
 -  MODIFY EXISTING STREET LIGHT CIRCUIT
 -  PROPOSED UNIT DUCT, 1" (2#6, #6G XLP-USE)
 -  PROPOSED GALVANIZED STEEL CONDUIT
 -  EXISTING ELECTRICAL CONTROL CABINET

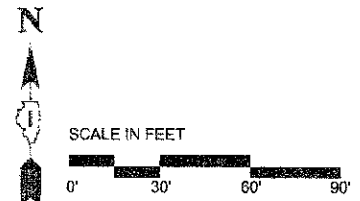

DESIGNED - MEU	REVISED -
DRAWN - BLG	REVISED -
CHECKED - TCK	REVISED -
DATE - 12-19-11	REVISED -

STATE OF ILLINOIS
DEPARTMENT OF TRANSPORTATION

ELECTRICAL PLAN

SCALE: 1" = 30'
 PROJECT - 03-0745-001 STA. 2122+63.00 TO STA. 2138+83.00

F.A.U. RTE.	SECTION	COUNTY	TOTAL SHEETS	SHEET NO.
14E3	11-00043-00-LS	DUPAGE	20	11
CONTRACT 83863		ILLINOIS FED. AID PROJECT TE-001 (872)		