
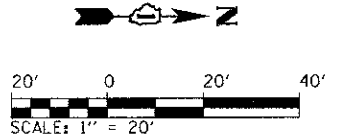


MATCHLINE STA.70+00.00

FOR LEGEND AND NOTES
SEE SHEET 48

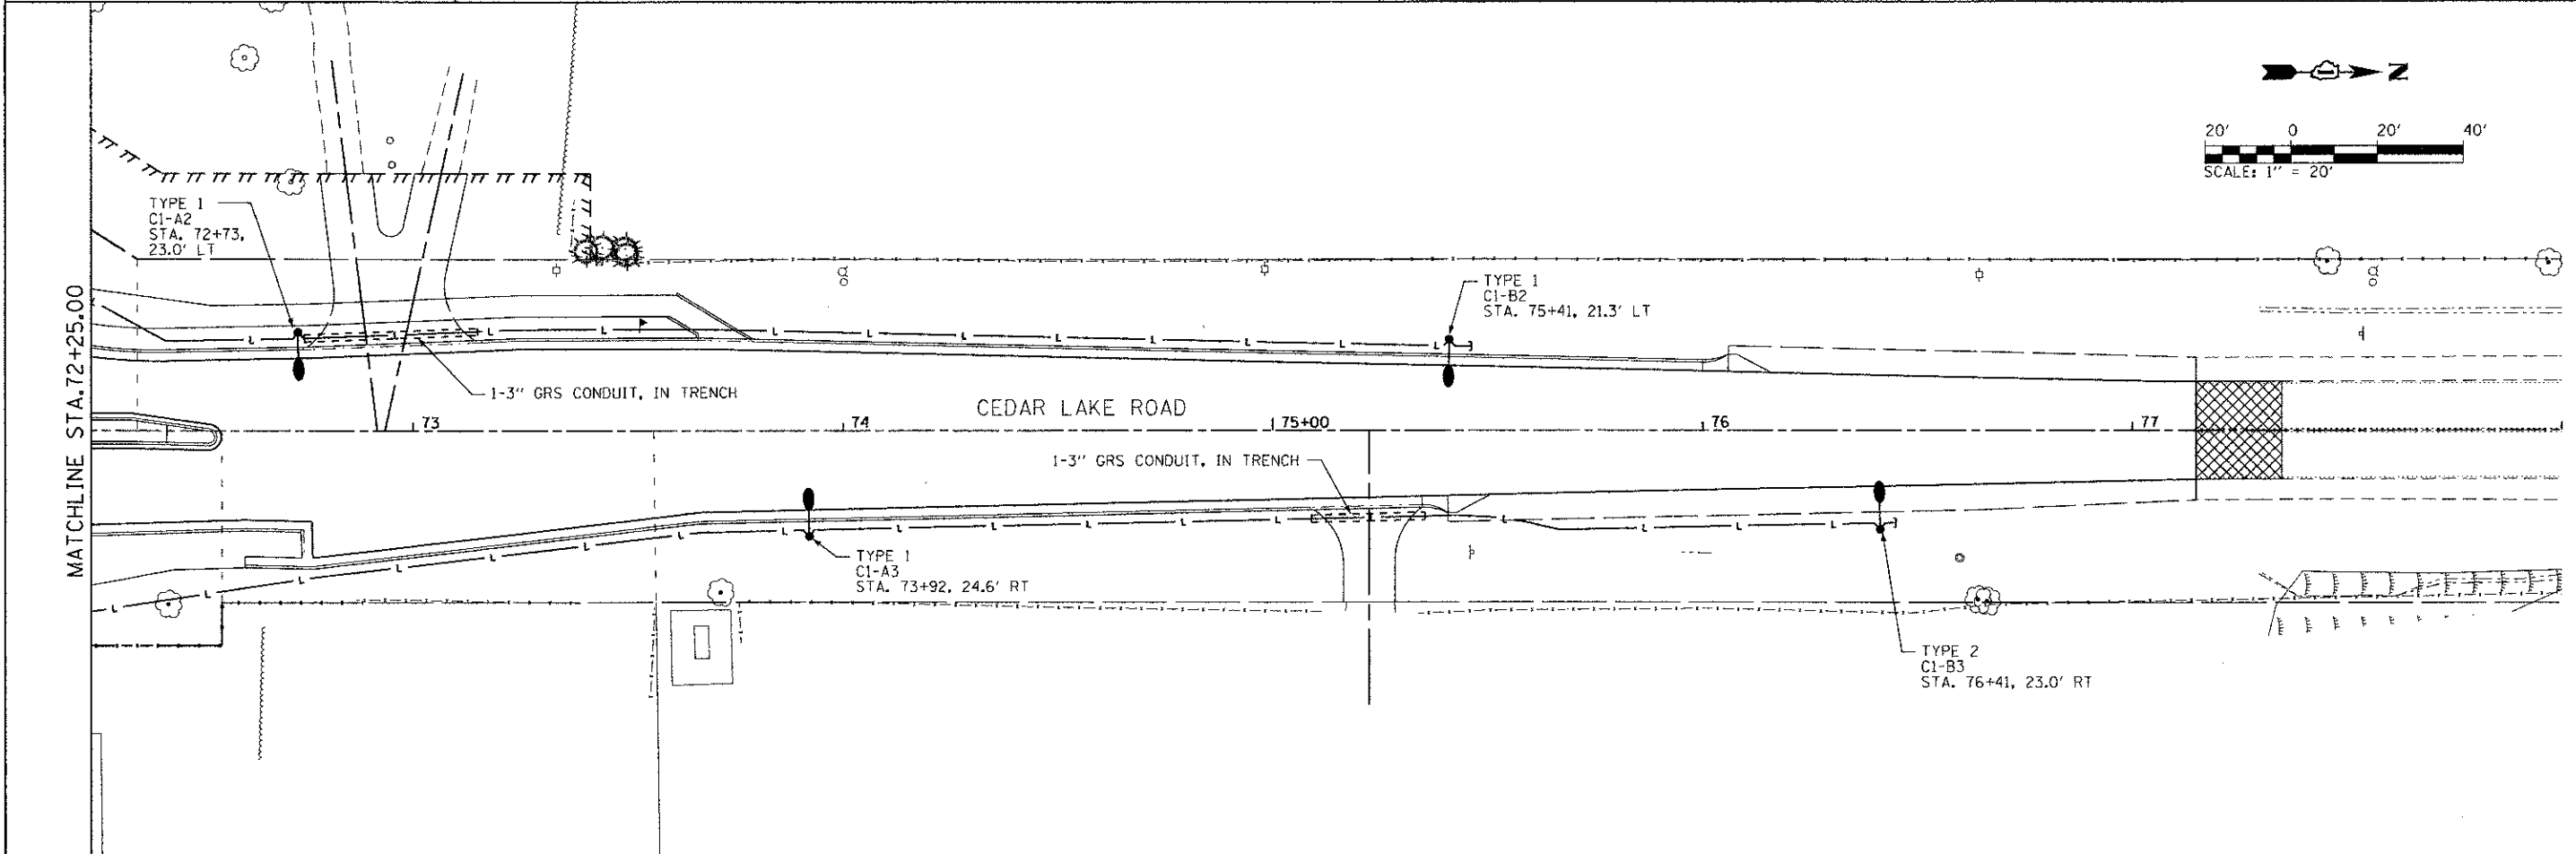

FILE NAME: L:\L\REV\122401\Draw\CADD\Sheets\Lighting_9_0100_2.dgn

CMT
CRAWFORD, MURPHY & TILLY, INC.
CONSULTING ENGINEERS
License No. 084-00063

USER NAME = Jeff Sedig	DESIGNED -	REVISED -
PLOT SCALE = 40,0000' / in.	DRAWN -	REVISED -
PLOT DATE = #PLOTDATE#	CHECKED -	REVISED -
	DATE -	REVISED -

**STATE OF ILLINOIS
DEPARTMENT OF TRANSPORTATION**

**LIGHTING AND CCTV PLAN
ROADWAY LIGHTING PLAN**

SHEET NO. 9 OF 9 SHEETS STA. TO STA.

F.A.U. RTE. 0192	SECTION 06-00153-07-CH	COUNTY LAKE	TOTAL SHEETS 120	SHEET NO. 56
CONTRACT NO. 63682				
FED. ROAD DIST. NO. ILLINOIS FED. AID PROJECT				